


REVISIONS AND ISSUES		DATE		DWG. NO.	
LOCATION OF REVISIONS ARE INDICATED ON DWG. AS 				RC-3BS-01	
ISSUED FOR PHASE 01		31/08/07			
ISSUED FOR TENDER DRAWING		24/04/08			



REVISIONS AND ISSUES		DATE		DATE	
LOCATION OF REVISIONS ARE INDICATED ON DWG. AS		31/08/27			
ISSUED FOR PHASE 01					
ISSUED FOR TENDER DRAWING		24/04/08			

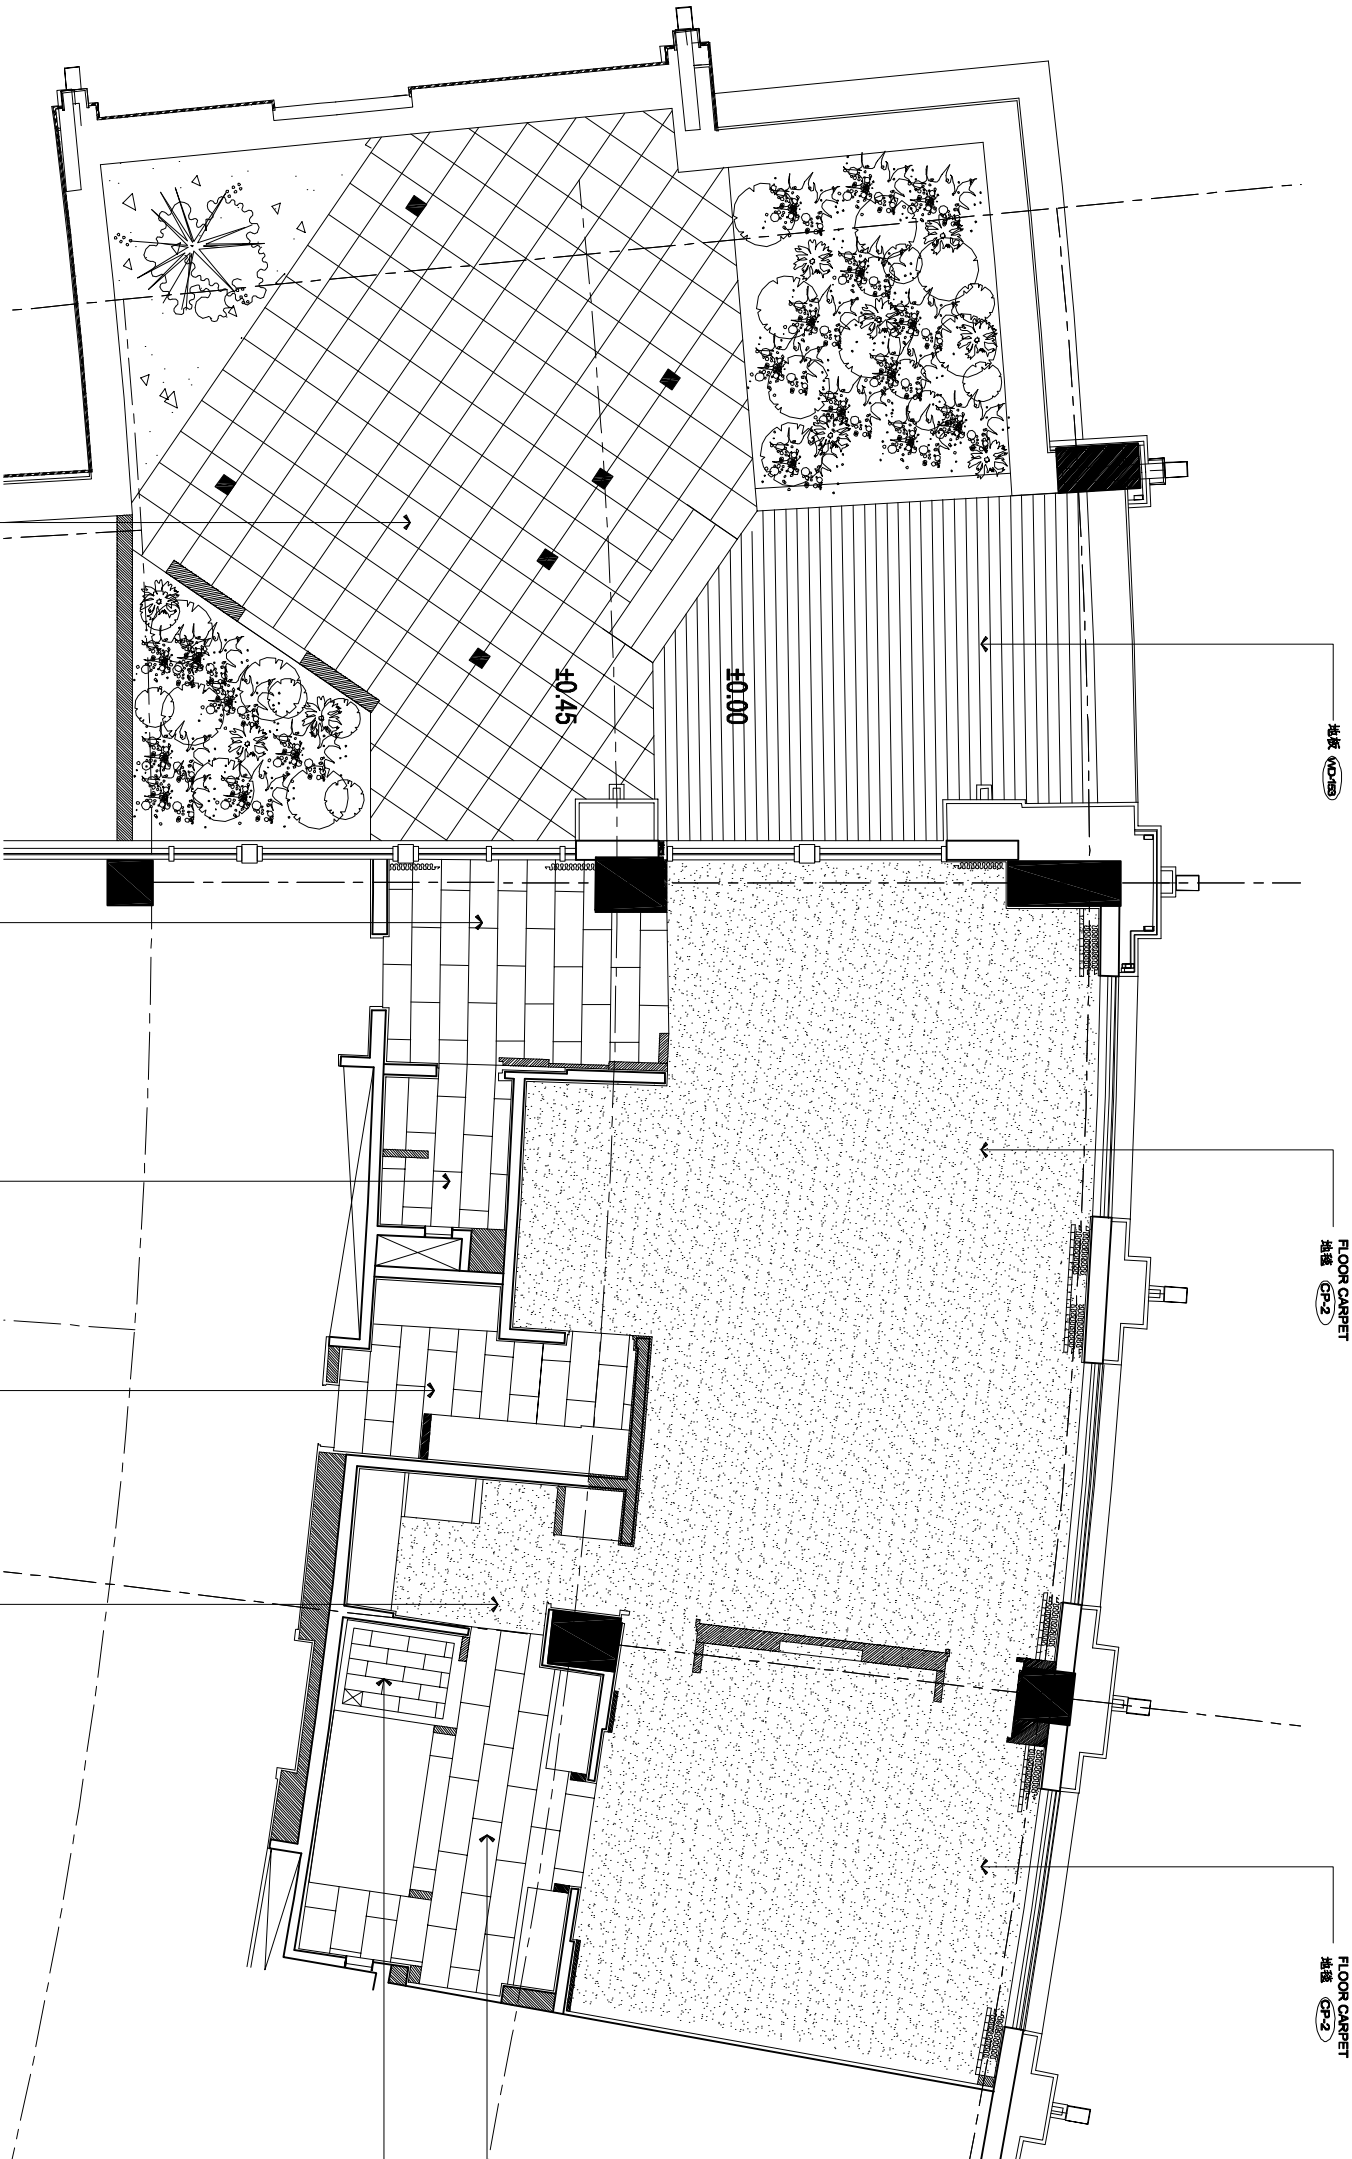

REVISIONS AND ISSUES				CHHADA SIEMBIEDA LEUNG				THE INTERCONTINENTAL SUZHOU				3 BAYS SUITE ROOM				DWG. NO.	
LOCATION OF REVISIONS ARE INDICATED ON DWG. AS				Limited, Design Consultants Hong Kong				JIANGSU, CHINA				FLOOR COVERING PLAN				FC-3BS-01	
1	ISSUED FOR PHASE 01	DATE	31/08/27	5				8				DATE	4/26/09	SCALE	1: 50 (A1) / 1: 100 (A3)	PROJECT NO.	07-01
2	ISSUED FOR TENDER DRAWING	24/04/09		6				10				DRAWN BY	STEPHEN	APPROVED BY			
3				7				11				FILE NAME	3 BAYS SUITE ROOM (A1-A3).dwg				REVISION / 2

[illegible][illegible]


ELECTRICAL SCHEDULE	
CODE	DESCRIPTION
1	TELEPHONE OUTLET
2	FACSIMILE OUTLET
3	TELEPHONE OUTLET FOR INTERNET
4	TV ANTENNA JACK
5	AV ANTENNA JACK
6	JUNCTIONBOX
7	ELECTRIC OUTLET
8	SHAVER OUTLET
9	JUNCTIONBOX
10	AC SUPPLY
11	SPEAKER UNIT
12	SMOKE DETECTOR
13	SPRINKLER HEAD
14	ELECTRIC OUTLET FOR HANDDRYER
15	DOOR BELL
16	SPEAKER
17	CHIME
18	WALL BOX PRESET CONTROL
19	DIMMER CONTROL PANEL
20	TRANSFORMER
21	EMERGENCY CIRCUIT
22	WALL MTD. SOCKET OUTLET
23	FLOOR MOUNTED SOCKET OUTLET
24	ON/OFF SWITCH
25	LOCAL DIMMER SWITCH
26	MICROSWITCH
27	MASTER SWITCH
28	CURTAIN SWITCH
29	THERMOSTAT CONTROL
30	
31	
32	
100	

DRAWING SCHEME		
CODE	DESCRIPTION	名称
①	FURNITURE ITEM	家具编号
LD	LAMP ITEM	灯具编号
CB	CARPET ITEM	地毯编号
CT	CERAMIC TILE ITEM	瓷砖编号
FA	FABRIC ITEM	面料编号
GL	GLASS ITEM	玻璃编号
MT	METAL ITEM	金属编号
PT	PAINT ITEM	油漆编号
ST	STONE MATERIAL ITEM	石材编号
WC	WALLCOVERING ITEM	墙纸编号
WD	WOOD ITEM	木材编号
BA	SANITARY WARE ITEM	卫生洁具编号
1 Ps	DETAIL ITEM	大样编号
2	DETAIL LOCATION	大样位置
RE.	REFER TO DETAIL	参考大样


DRAWING ITEM	
IE-1.2.03 (SMRPE)	
1E	DRAWING STYLE
1.2	FLOOR NO., SPACE NO.
03	DRAWING ORDER
	图式类号
	楼层编号, 空间编号
	图纸顺序编号

DRAWING STYLE	
CODE	DESCRIPTION
FF-	FLYTILE & FURNISHING PLAN
AR-	REFLECTED CEILING PLAN
AC-	ARCHITECTURAL & INFORMATION PLAN
EM-	ELECTRICAL & MECHANICAL PLAN
FC-	FLOOR COVERING PLAN
IE-	INTERIOR ELEVATION
FD-	FLYTILE DETAILS
FU-	FURNISHING DETAILS

BUILDING LOCATION[illegible]




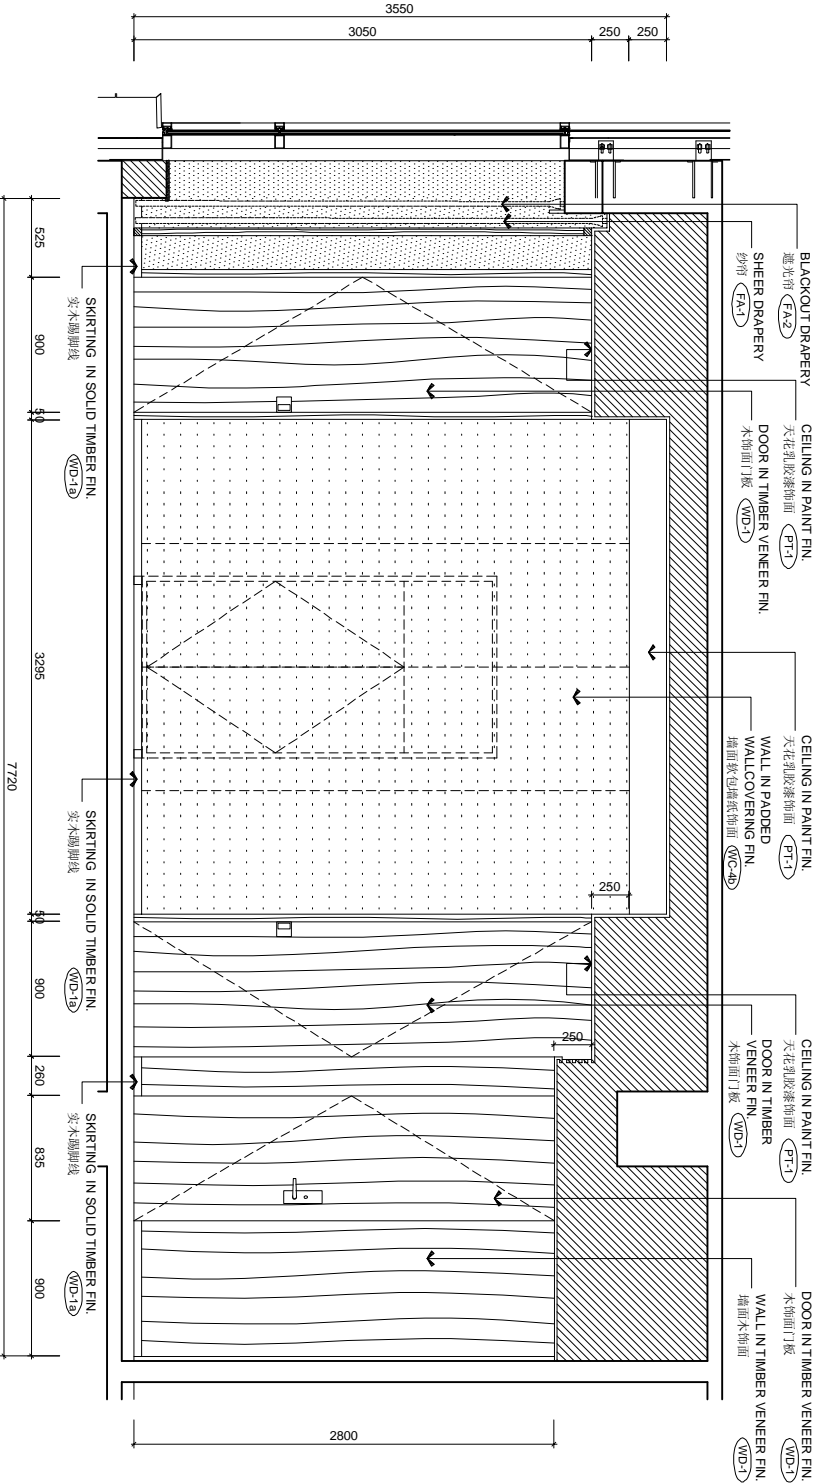


ELEVATION 3
SCALE 1:25

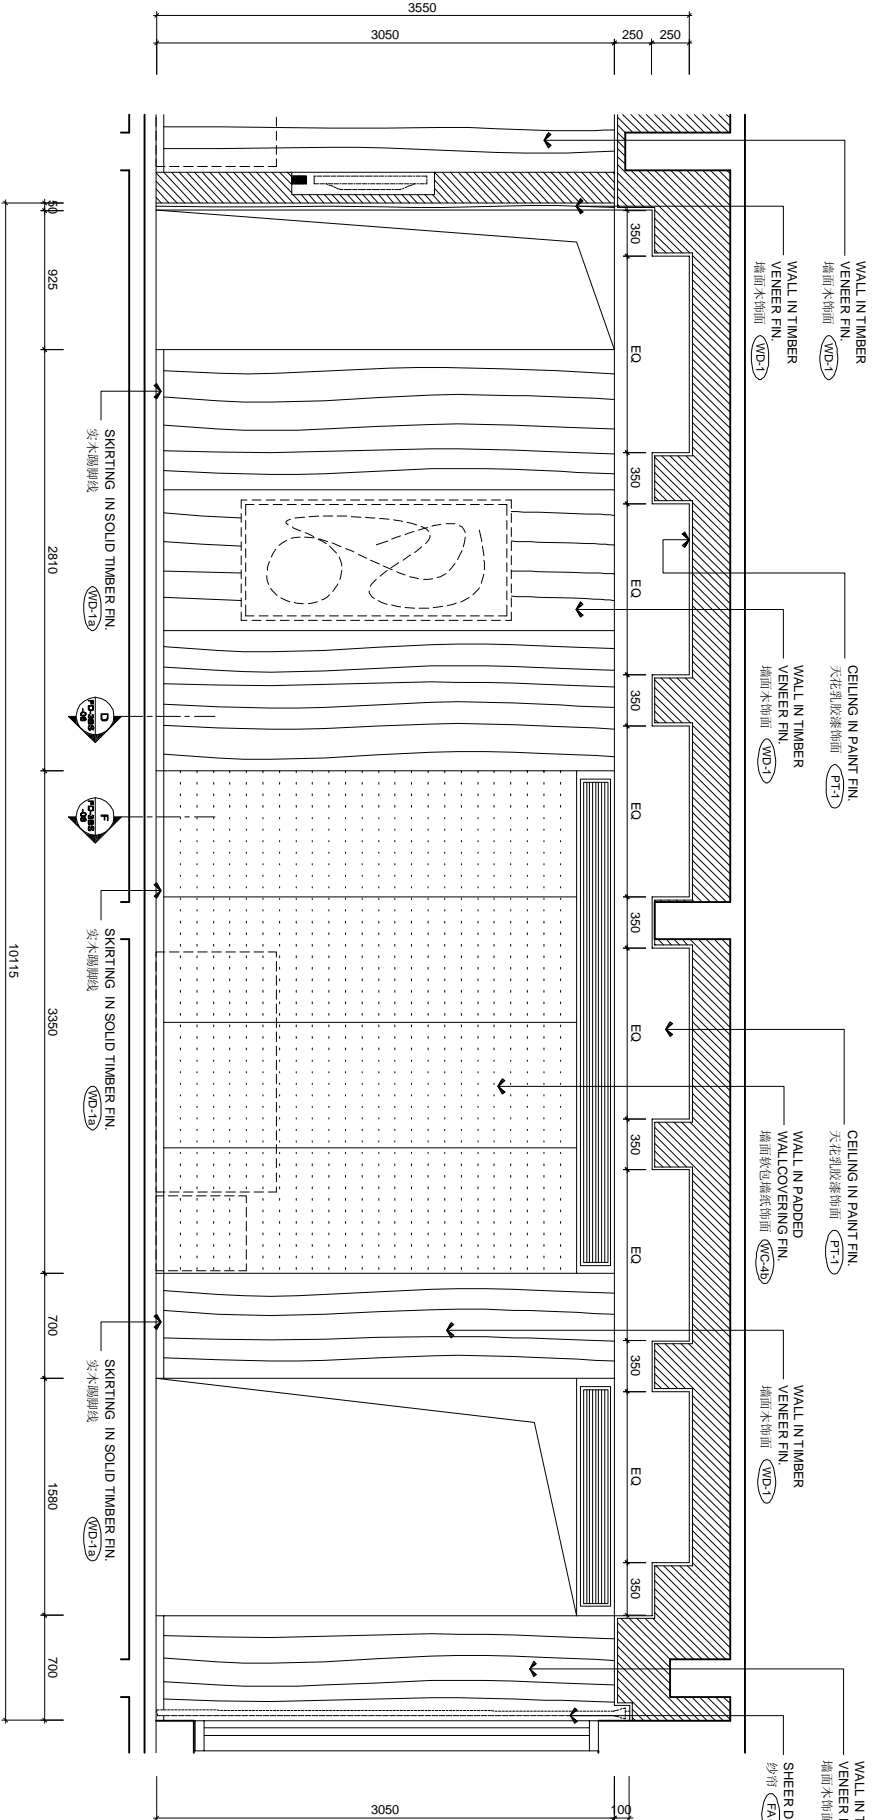

ELEVATION 4
SCALE 1:25

REVISIONS AND ISSUES										DATE									
LOCATION OF REVISIONS ARE INDICATED ON DWG. AS										24/04/09									
ISSUED FOR TENDER DRAWING																			
</																			

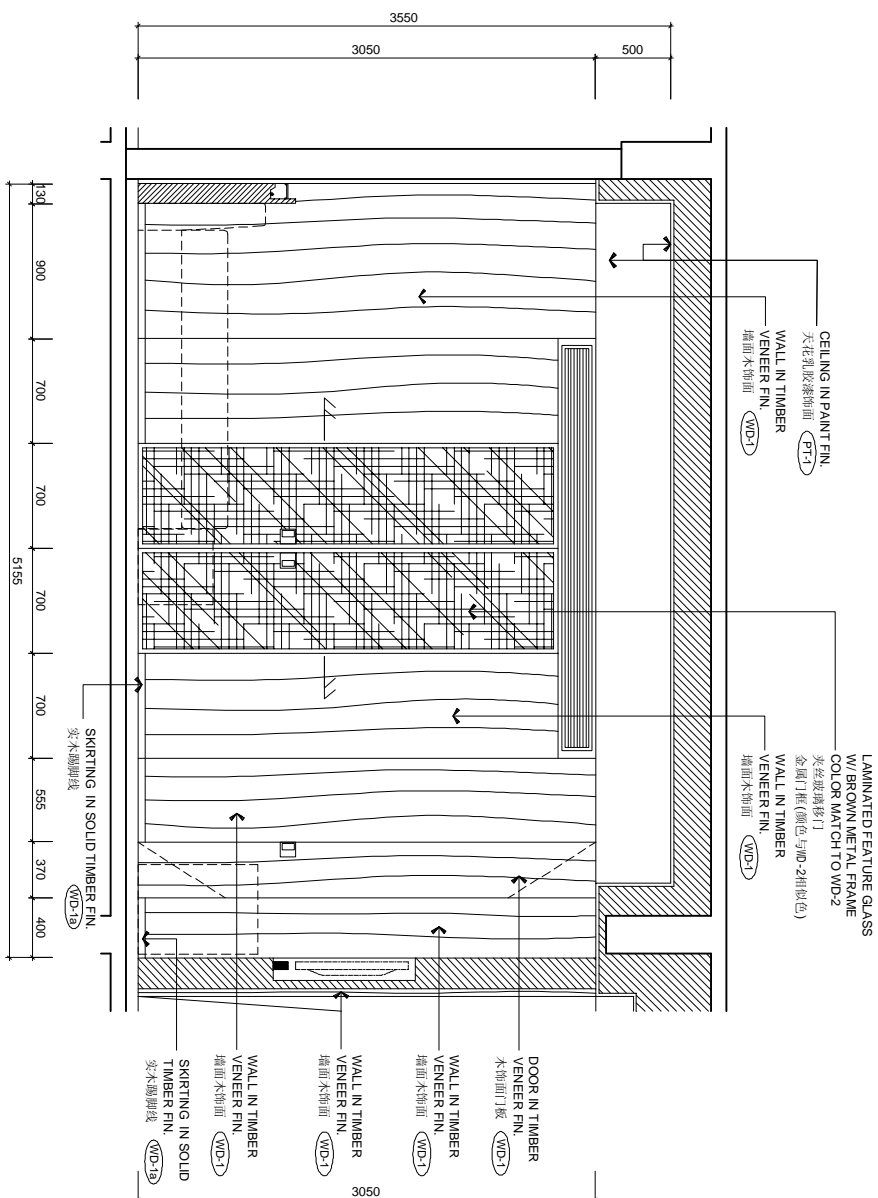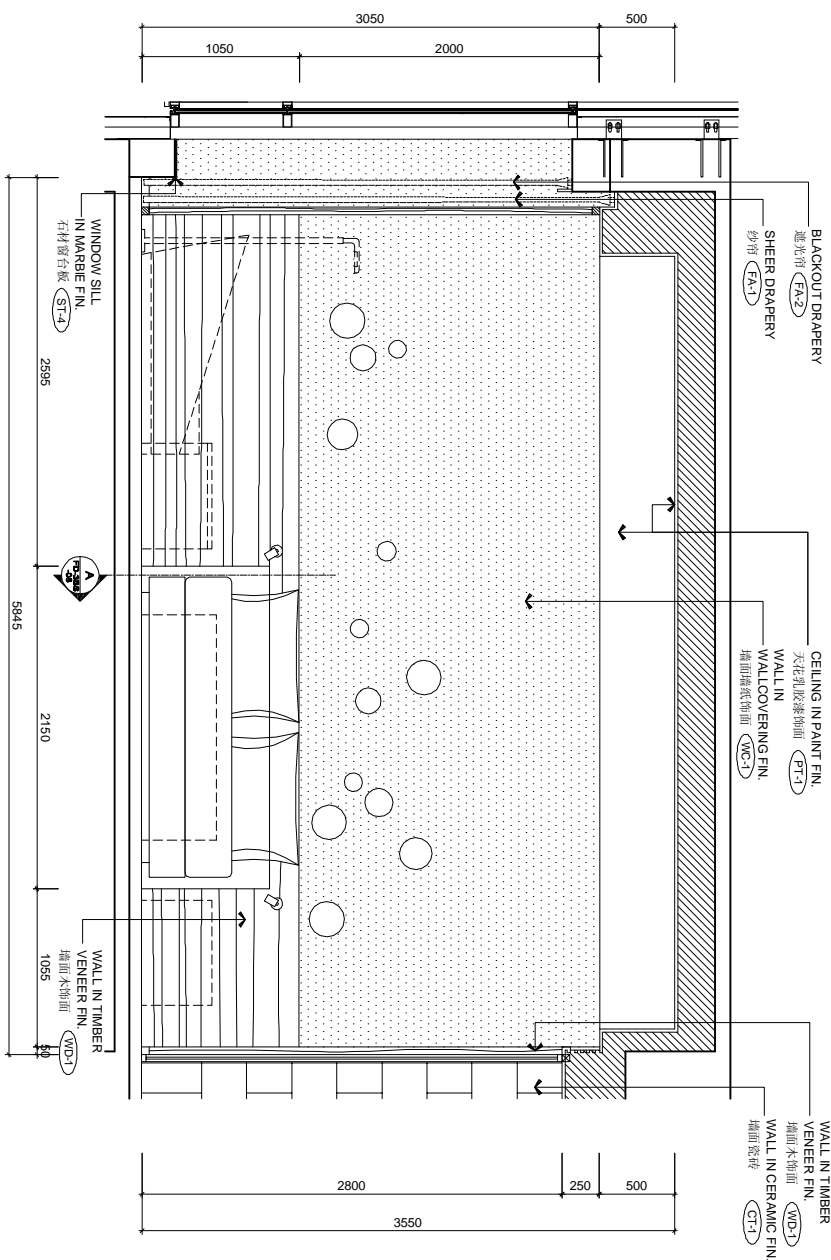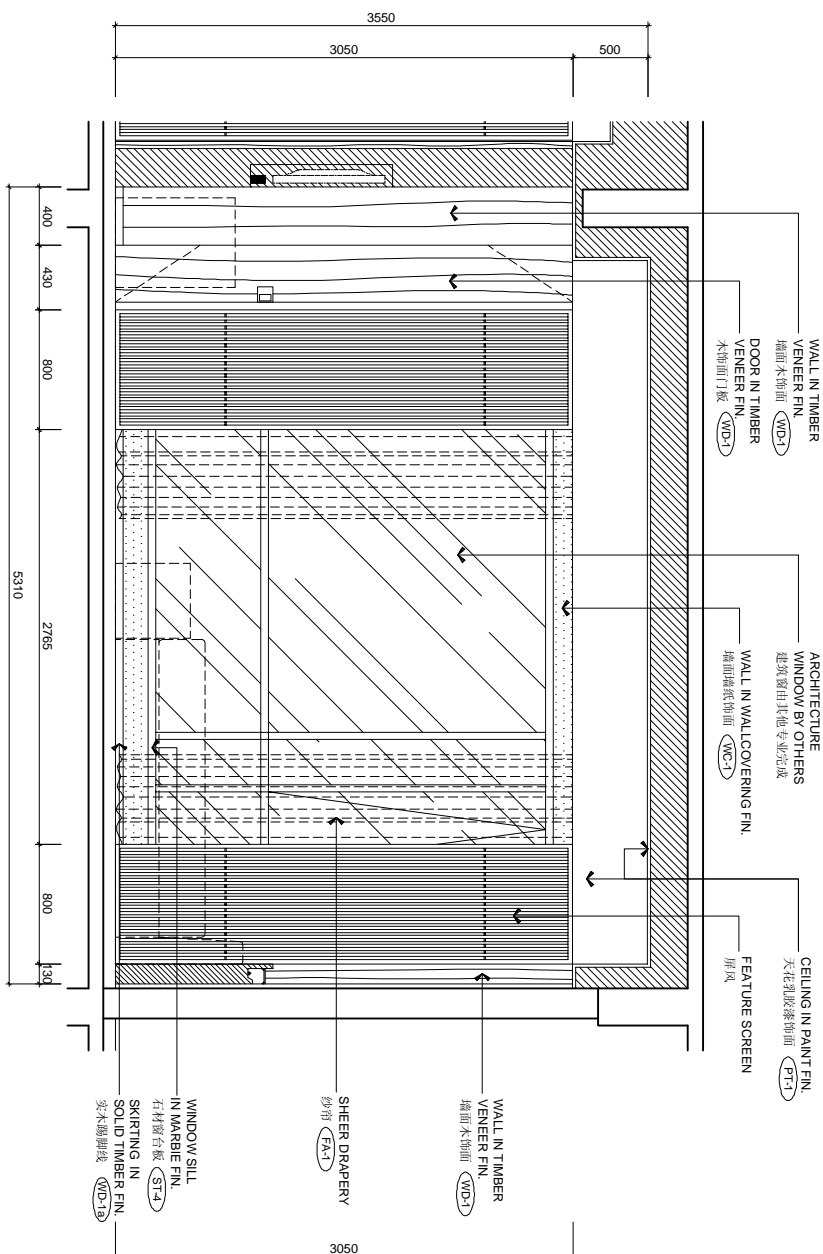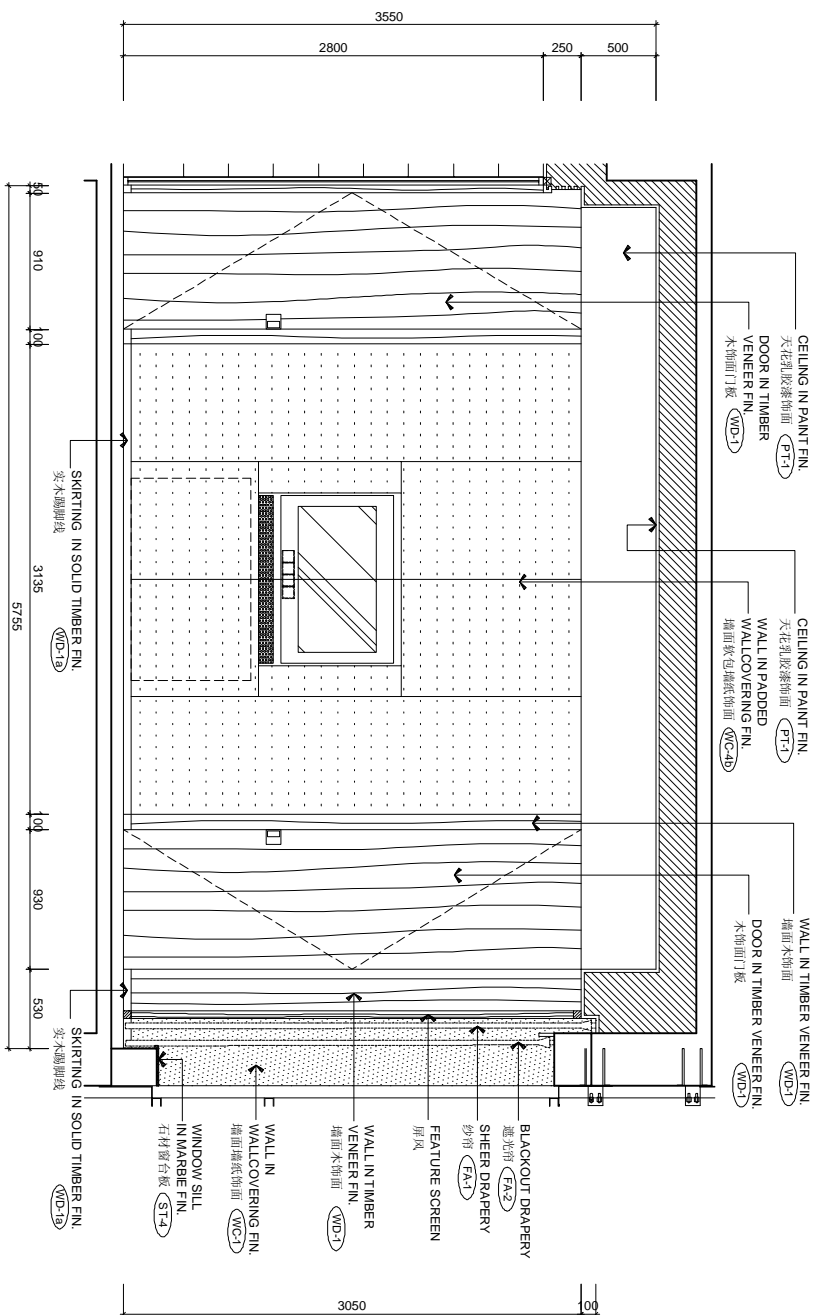

REVISIONS AND ISSUES		DATE	DWG. NO.	
LOCATION OF REVISIONS ARE INDICATED ON DWG. AS				
1	ISSUED FOR TENDER DRAWING	200408		
2				
3				

CHHADA SIEMBIEDA LEUNG
Limited Design Consultants Hong Kong

ALL DRAWINGS, PRINTING & SPECIFICATIONS ARE THE PROPERTY OF CHHADA SIEMBIEDA LEUNG. ANY UNAUTHORIZED REPRODUCTION OR DISTRIBUTION IS STRICTLY PROHIBITED. ANY DISCREPANCIES SHALL BE REPORTED IMMEDIATELY TO CHHADA SIEMBIEDA LEUNG LTD. IMMEDIATELY BY THE CONTRACTOR AND/OR PROJECT MANAGER.

THE INTERCONTINENTAL SUZHOU
JIANGSU, CHINA

3 BAYS SUITE ROOM ELEVATIONS

IE-3BS-03





DATE	SCALE	PROJECT NO.
4/25/09	1:250(1:1) : 50(1:3)	

DRAWN BY	APPROVED BY	07-01
STEPHEN		







FILE NAME: F:\VICTOR\PROJECTS\17-Drawing\17-0709\3Bays Suite\3Bays Suite\3Bays Suite.dwg

17-0709 (27)



REVISION: 1

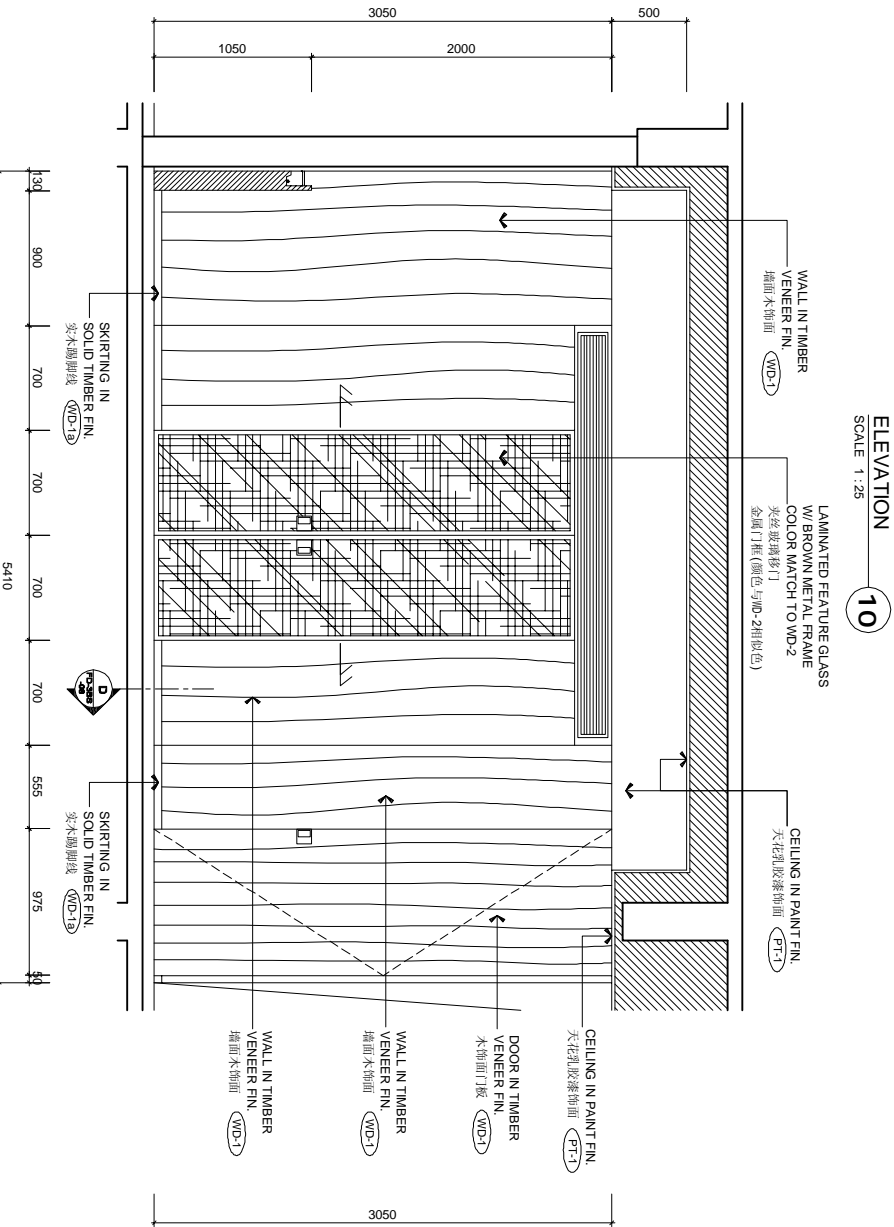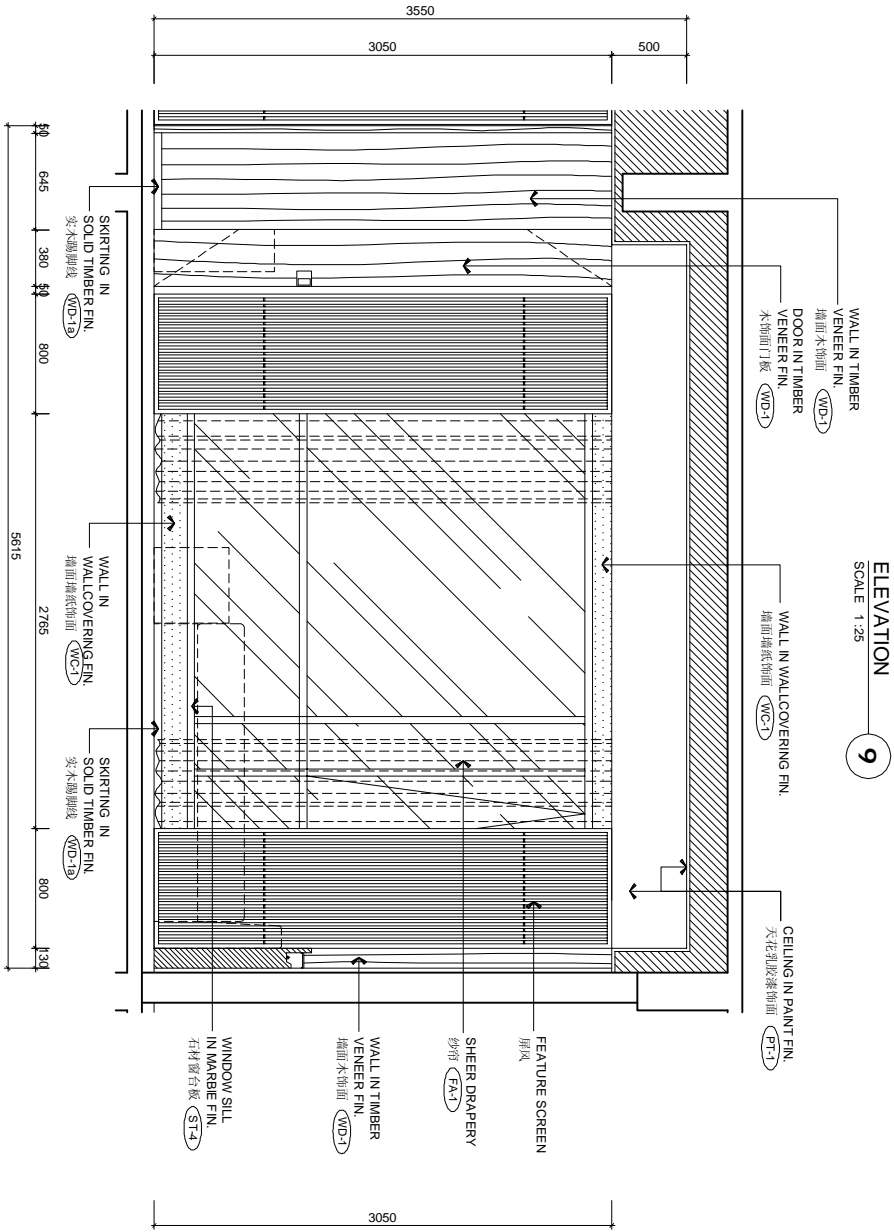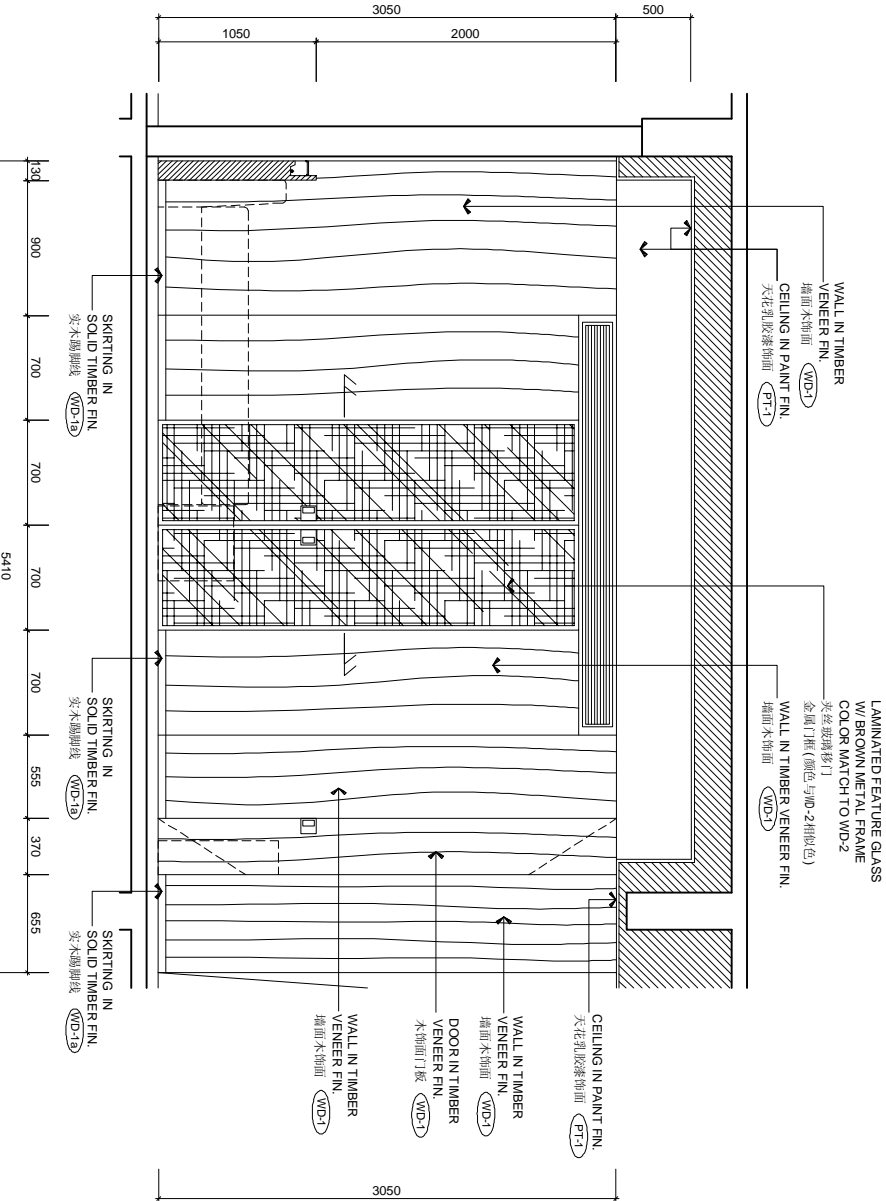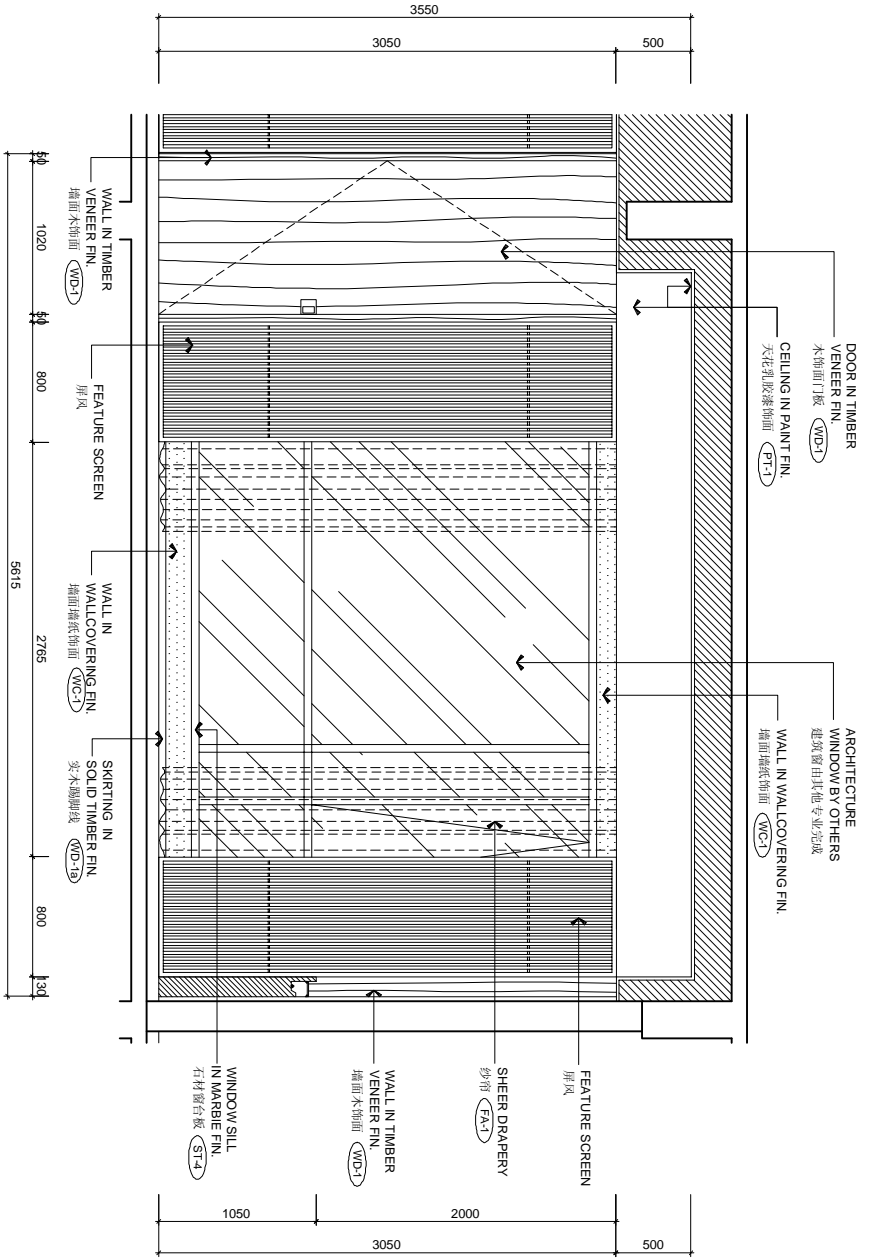



REVISIONS AND ISSUES				CHHADA SIEMBIEDA LEUNG			
LOCATIONS OF REVISIONS ARE INDICATED ON DWG. AS				Limited, Design Consultants Hong Kong			
1	ISSUED FOR TENDER DRAWING	DATE		THE INTERCONTINENTAL SUZHOU			
1		24/04/18		JIANGSU, CHINA			
2				3 BAYS SUITE ROOM ELEVATIONS			
3				DRAWN BY: STEPHEN			
4				APPROVED BY: 07-01			
5				PROJECT NO. IE-3BS-04			
6				DWG. NO. IE-3BS-04			
7				REVISION: A			

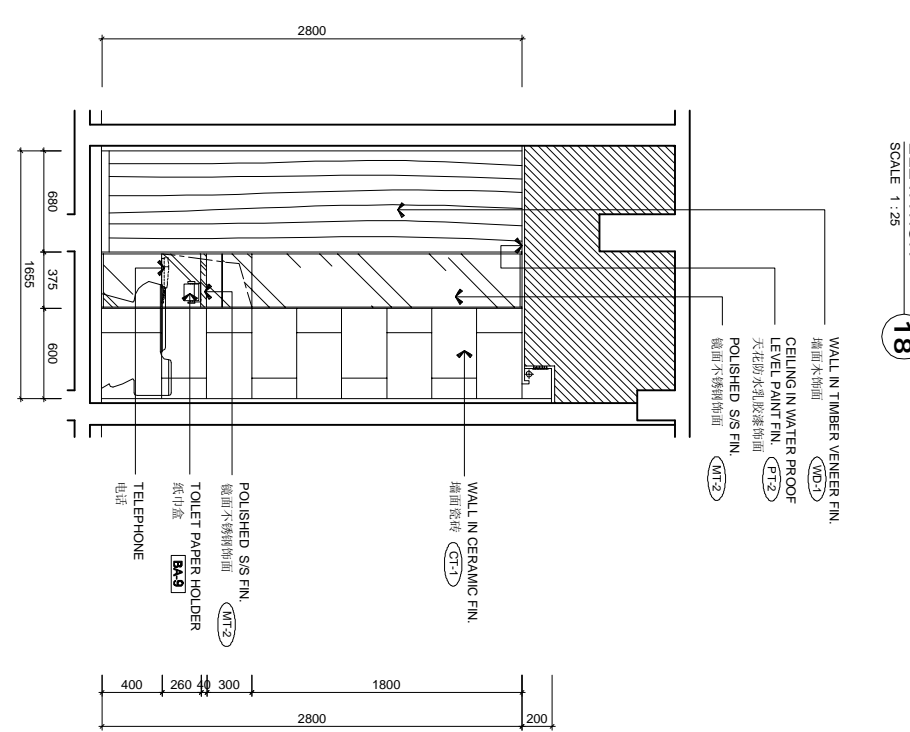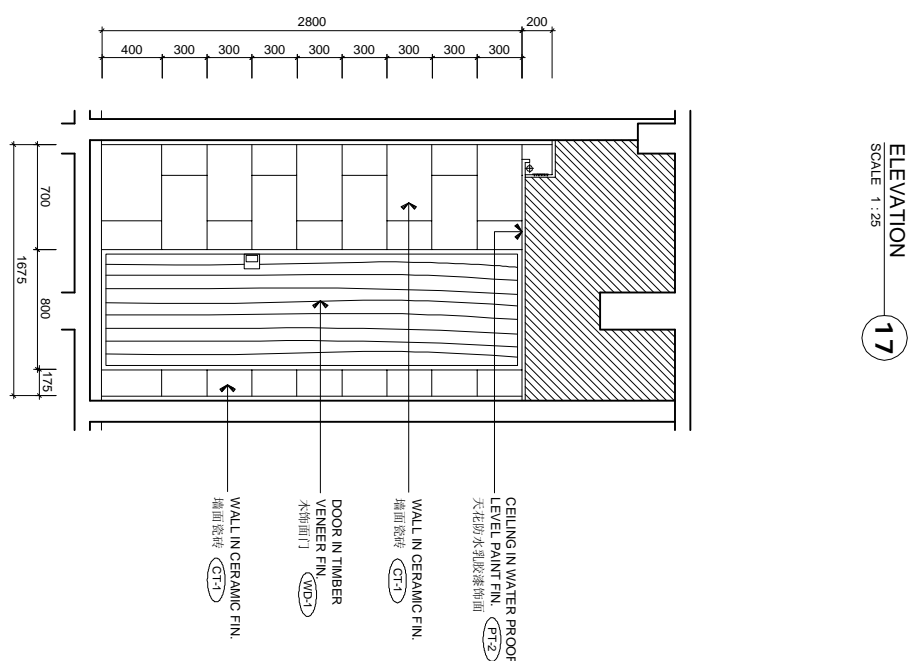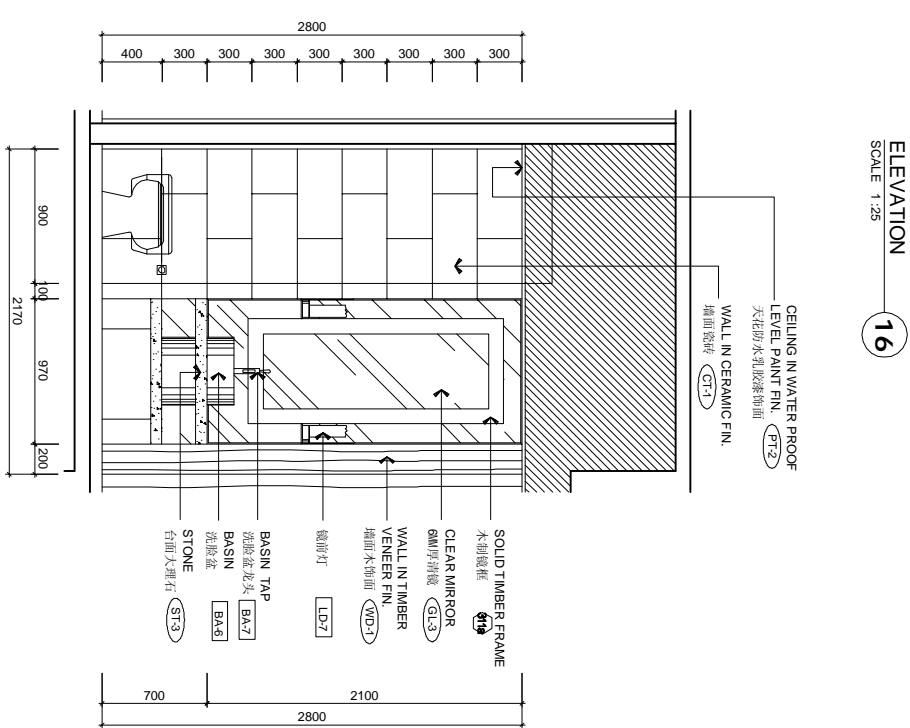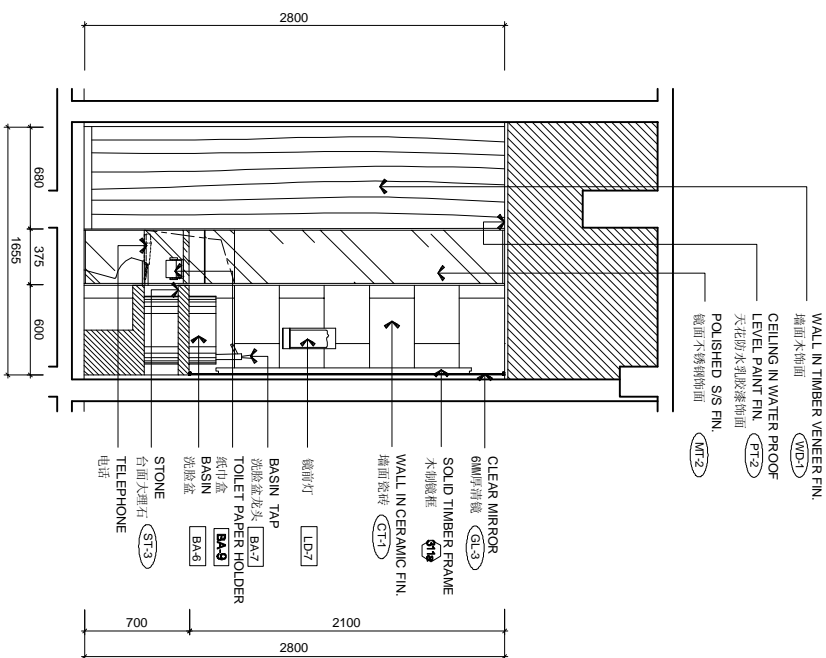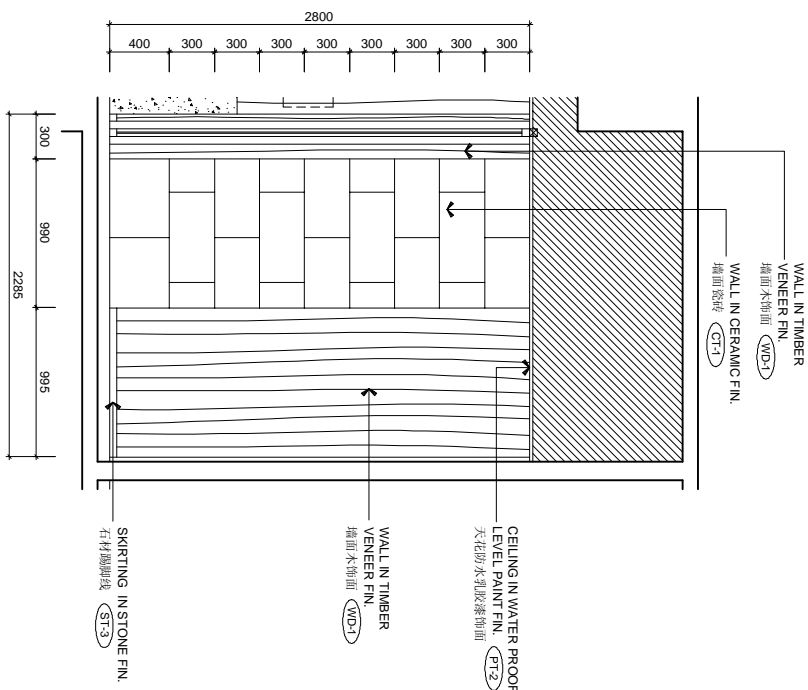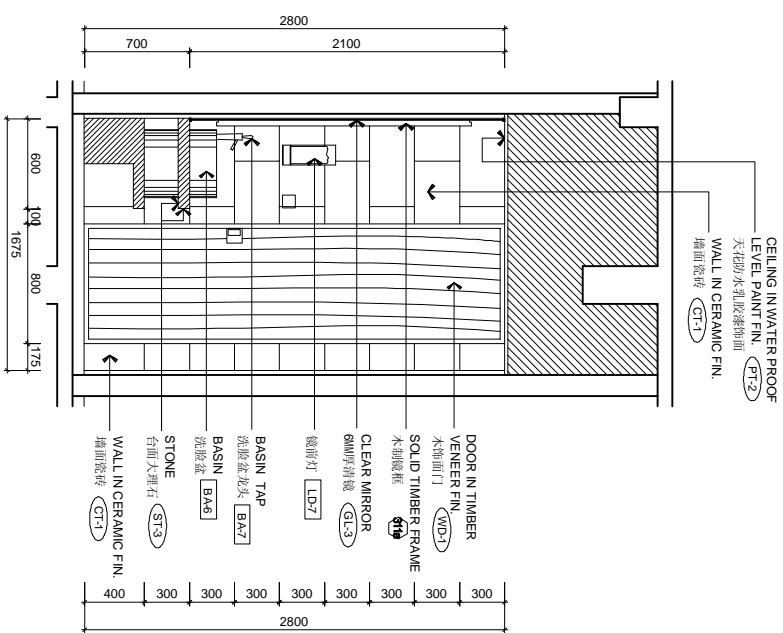

REVISIONS AND ISSUES									
LOCATION OF REVISIONS ARE INDICATED ON DWG. AS 									
REQUIRED FOR TENDER DRAWING									
		DATE							
		ZK0898							
									
									
									
									
CHI HADA SIEMBIEDA LEUNG Limited Design Consultants Hong Kong									
ALL REVISIONS MUST BE REPRODUCED AS THE PROPERTY OF CHI HADA SIEMBIEDA LEUNG. SAME SHALL BE RETURNED AT COMPLETION OF WORKS. DO NOT SCALE DRAWING. ANY CORRECTIONS SHALL BE REPORTED IMMEDIATELY TO CHI HADA SIEMBIEDA LEUNG S.T. IMMEDIATELY BY THE CONTRACTOR (PERSON) PRIOR TO PROCEED.									
THE INTERCONTINENTAL SUZHOU JIANGSU, CHINA									
3 BAYS SUITE ROOM ELEVATIONS									
IE-3BS-06									
DWG. NO.									
PROJECT NO.									
SCALE 1 : 20(=1) : 50(M)									
DATE 4/25/09									
DRAWN BY STEPHEN									
APPROVED BY									
07-01									
FILE NAME F:\CADD PROJECT\Drawing Intercontinental Hotel\Room & Kitchen Room\dwg\IE-3B-S-BAY.dwg									
E.C.D. dwg									
SURVEYOR (P.T.F.)									
REVISION 									

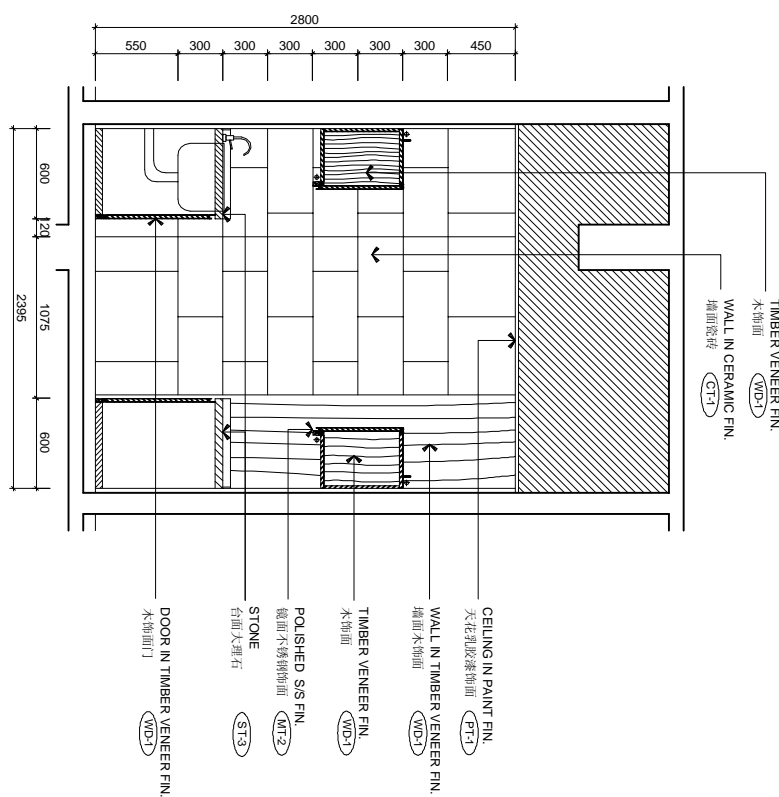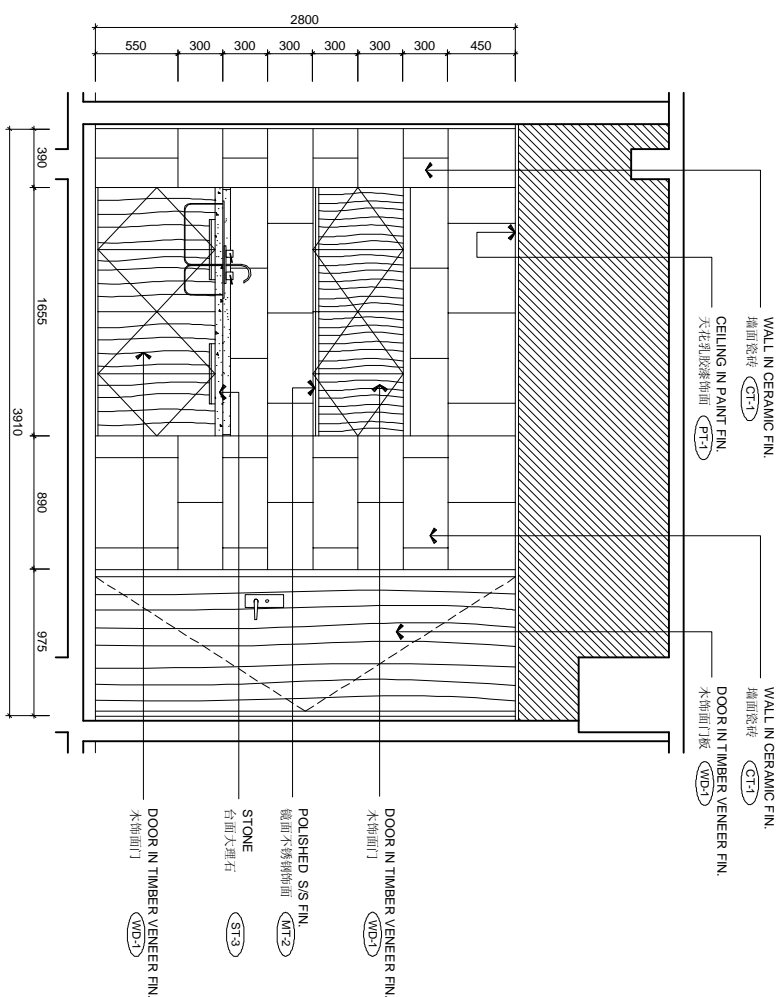

ELEVATION
SCALE 1:25
22

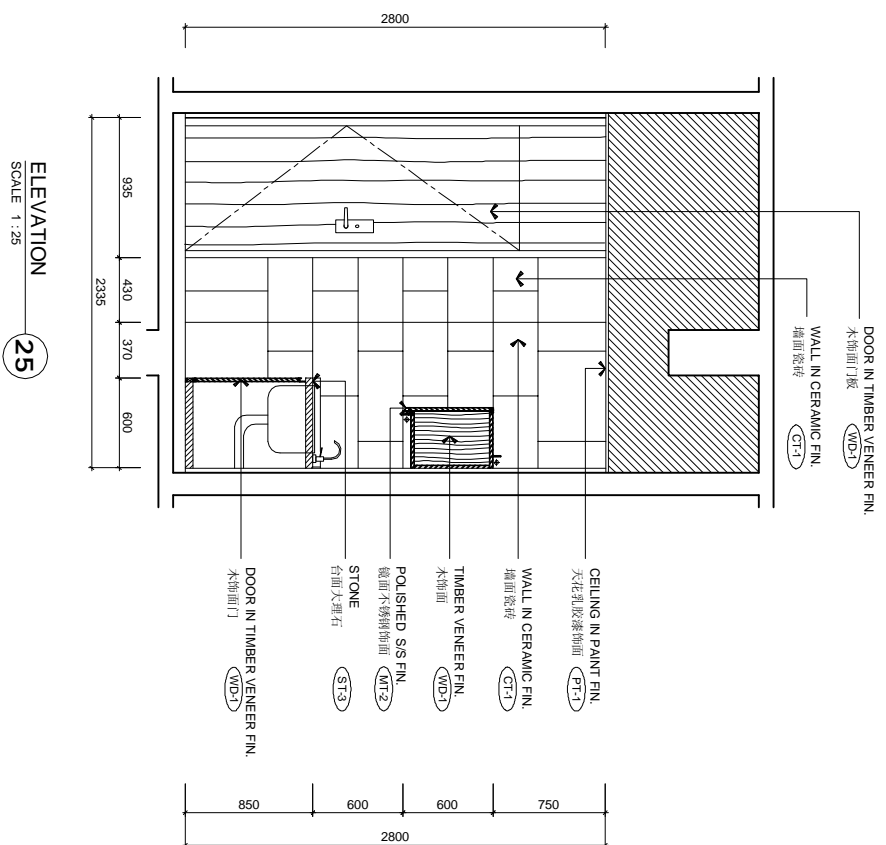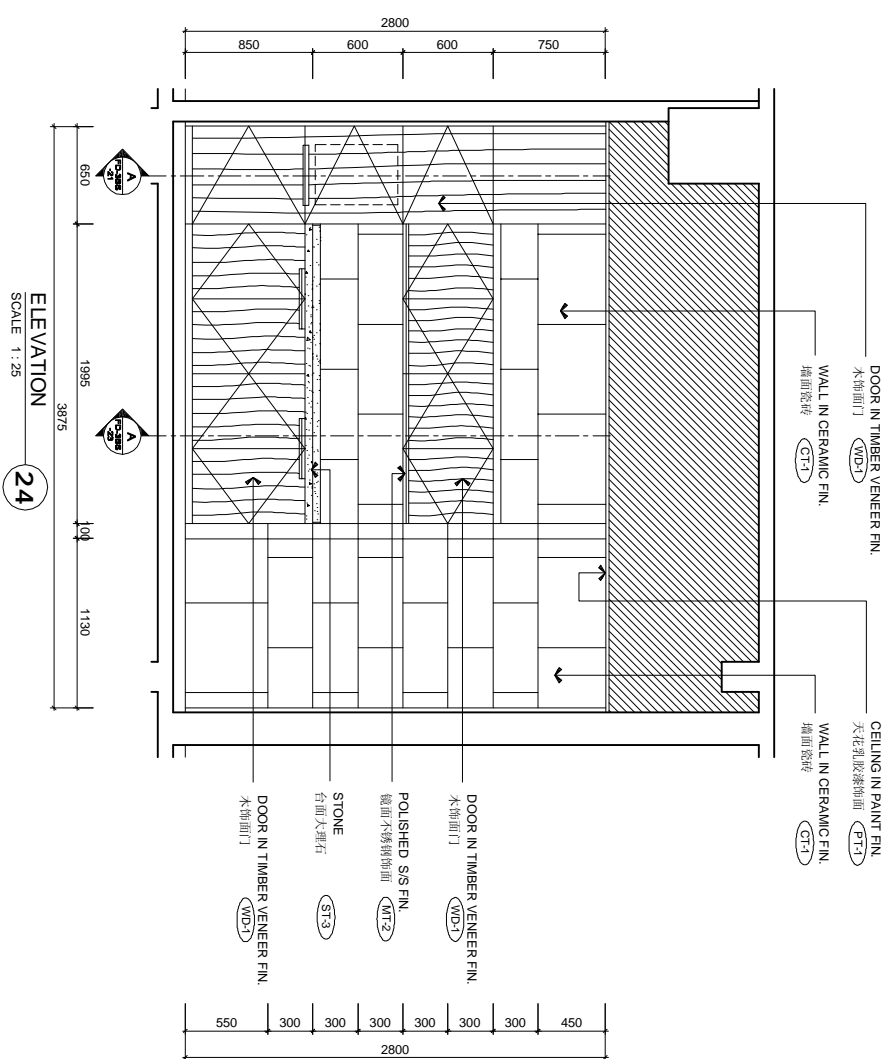

ELEVATION
SCALE 1:25
25

REVISIONS AND ISSUES		DATE	4	5
LOCATIONS OF REVISIONS ARE INDICATED ON DWG. AS				
1	ISSUED FOR TENDER DRAWING	24-04-2019	8	9
2			10	11
3			12	

CHHADA SIEMBIEDA LEUNG
Limited, Design Consultants Hong Kong

Limited. Design Consultants Hong Kong

THE INTERCONTINENTAL SUZHOU
JIANGSU CHINA

JIANGSU, CHINA

3 BAYS SUITE ROOM ELEVATIONS





DWG. NO.





IE-3BS-07


PROJECT NO.		07-01
DATE	4/25/09	SCALE 1:250(1)=50(A3)
DRAWN BY	STEPHEN	APPROVED BY
FILE NAME F:\LEID PROJECT\1-drawing 圖紙存檔\1-CSL\外網圖\1-Queen from a Workshop Room LE 01.dwg		

IE 01.dwg

REVISION 2

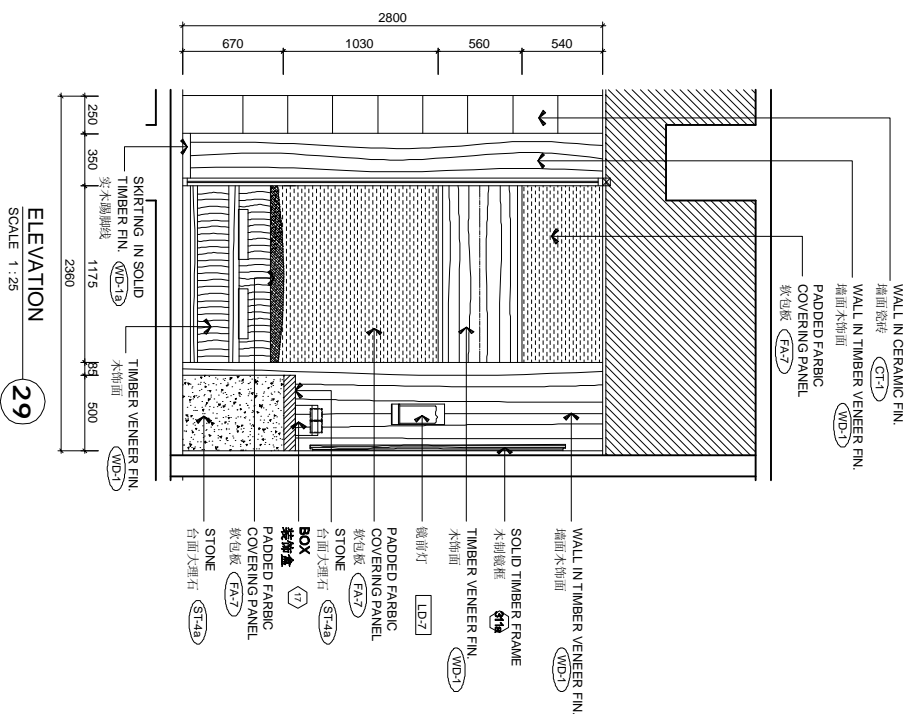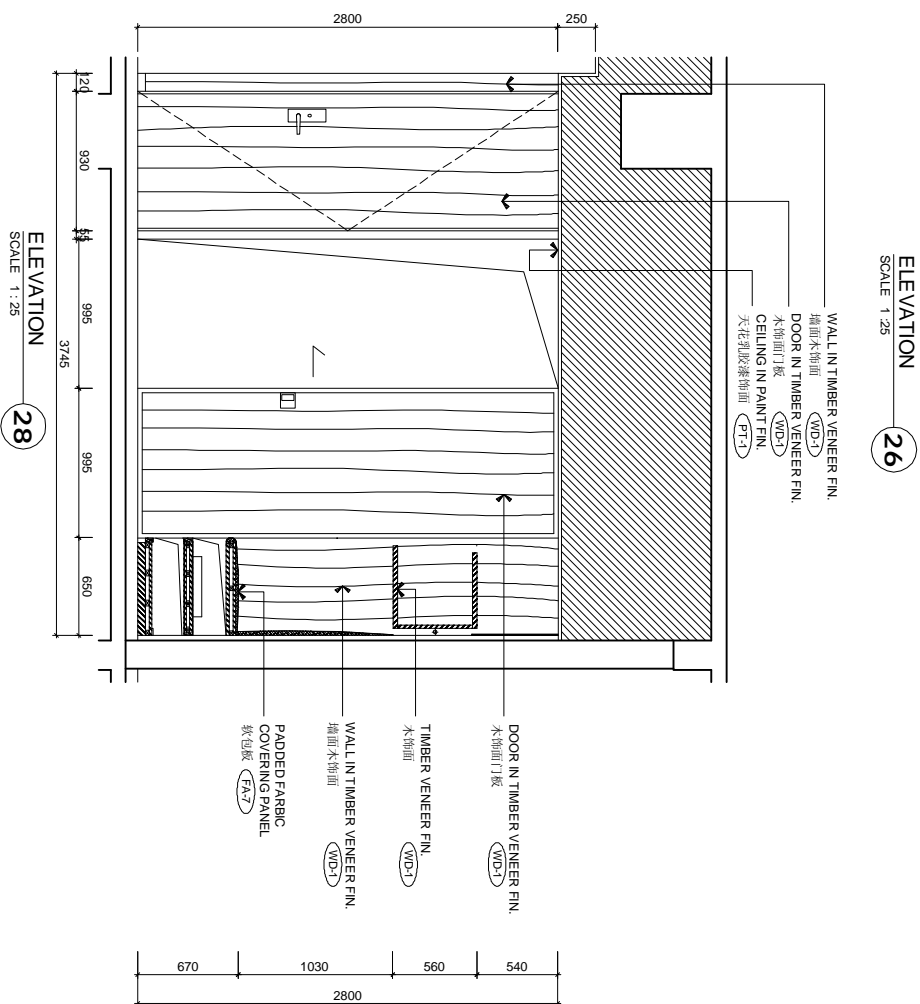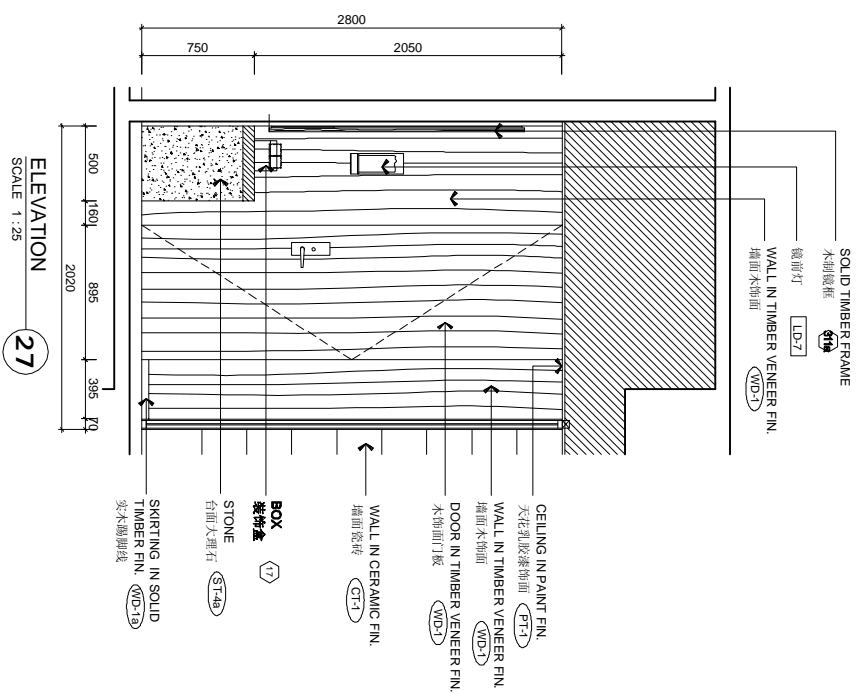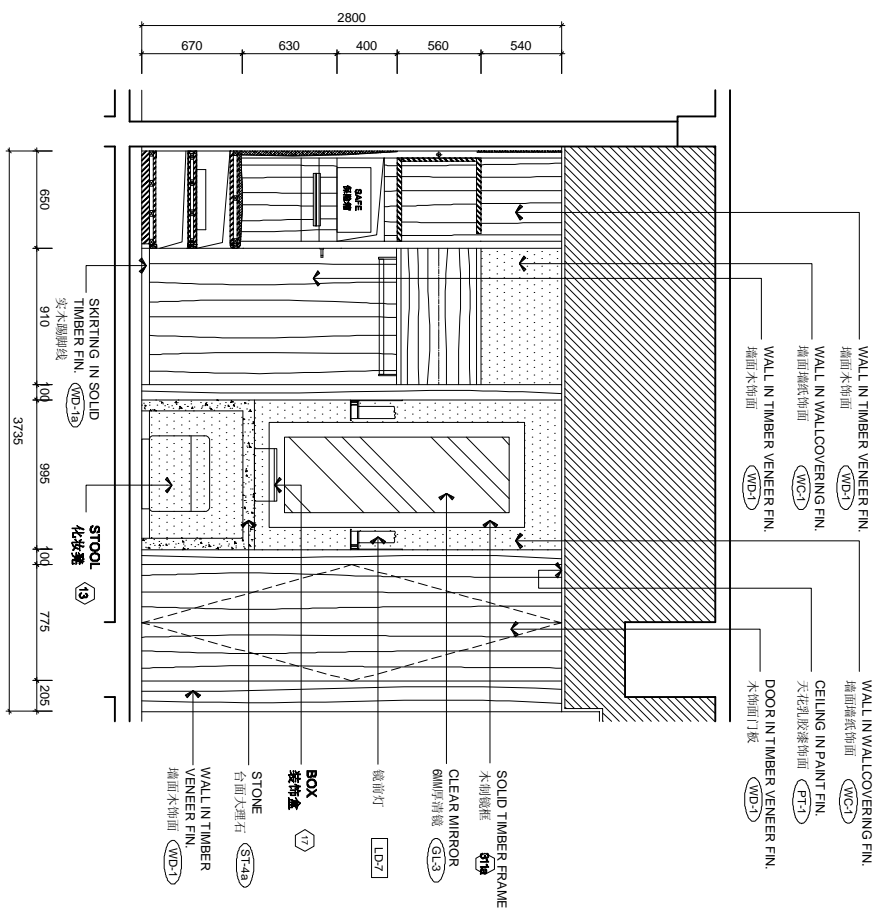[illegible]

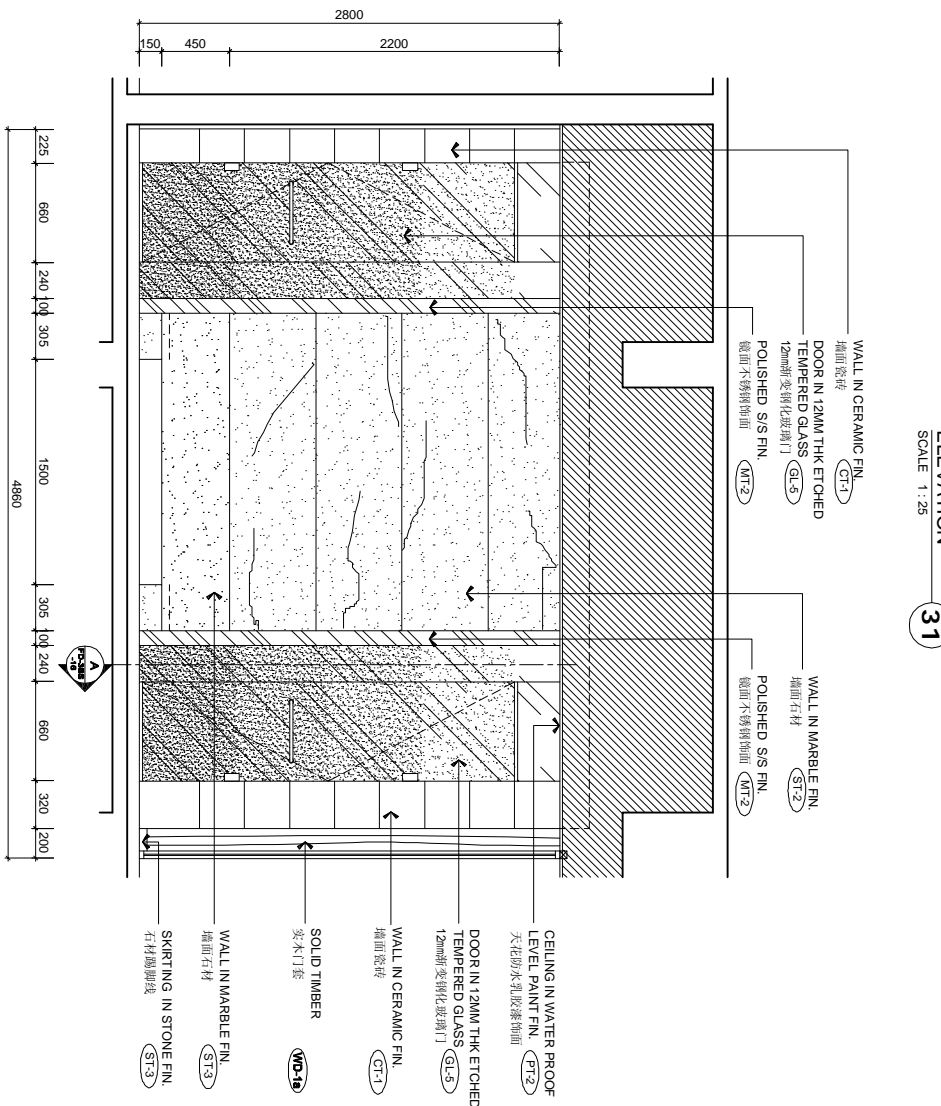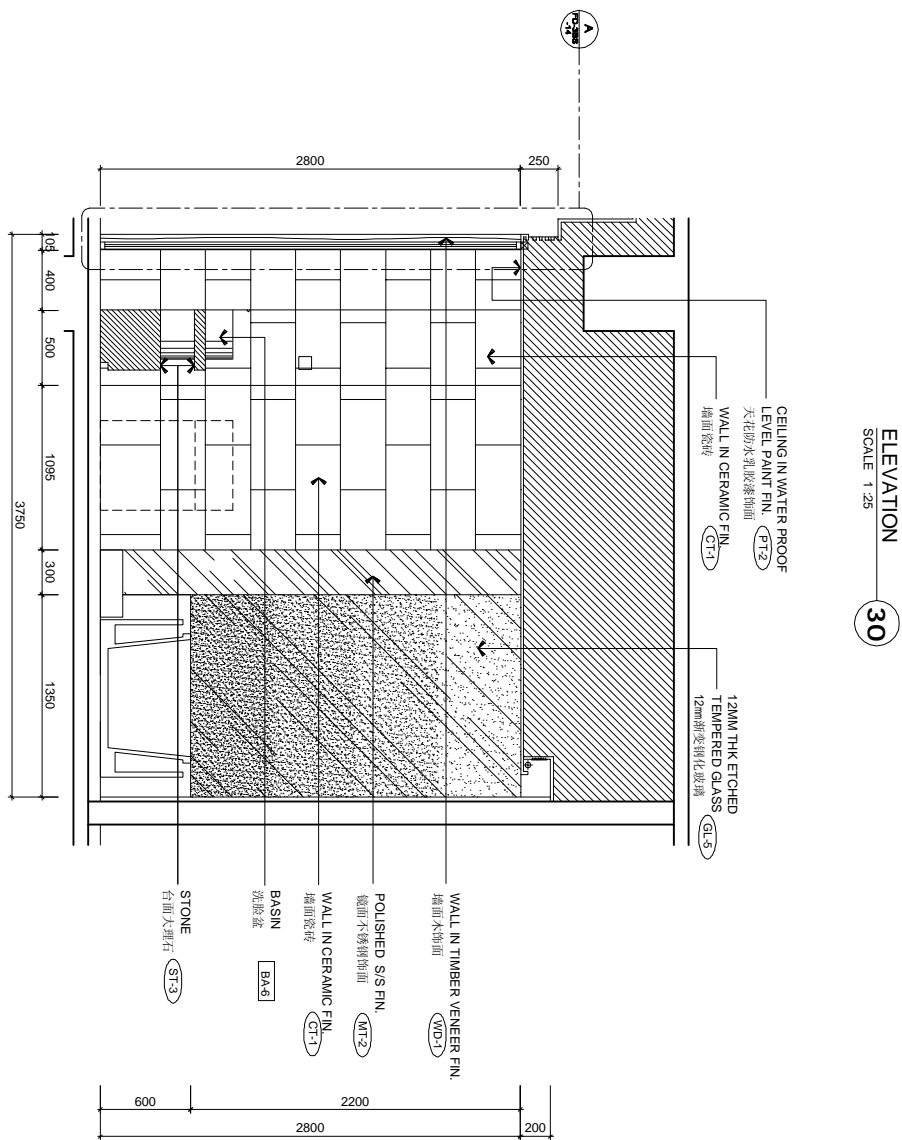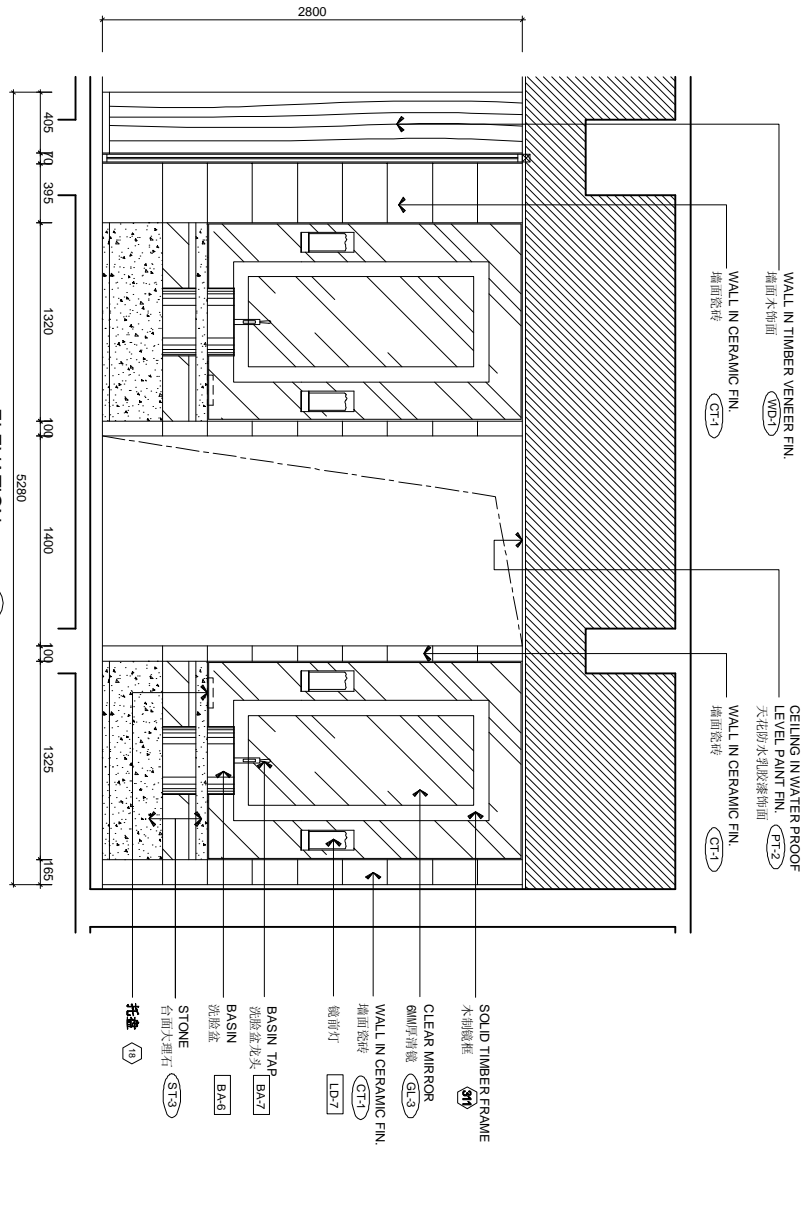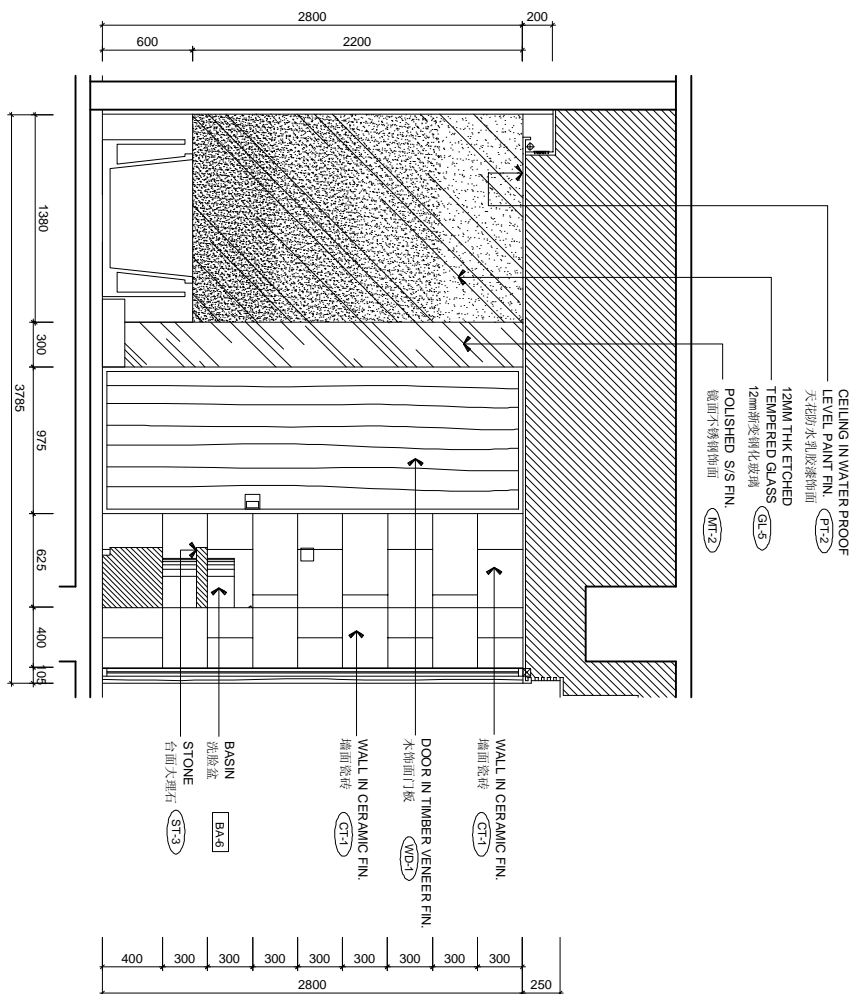

REVISIONS AND ISSUES		DATE		A		A	
LOCATIONS OF REVISIONS ARE INDICATED ON DWG. AS 							
ISSUED FOR TENDER DRAWING		2004/03		B		B	
1							
2							
3							

ELEVATION 32

SCALE 1:25

CHHADA SIEMBIEDA LEUNG
Limited, Design Consultants Hong Kong

ALL DESIGN, PRINTING & SPECIFICATIONS ARE THE PROPERTY OF CHHADA, SIEMBIEDA & LEUNG LTD. ANY REUSE OR REPRODUCTION OF ANY PART OF THIS DRAWING WITHOUT THE WRITTEN PERMISSION OF CHHADA, SIEMBIEDA & LEUNG LTD. IS STRICTLY PROHIBITED. ALL MEASUREMENTS MUST BE CHECKED AT THE SITE BY THE CONTRACTOR. ANY DISCREPANCIES MUST BE REPORTED TO THE CONTRACTOR IMMEDIATELY. CHHADA, SIEMBIEDA & LEUNG LTD. IMMEDIATELY BY THE CONTRACTOR AND/OR PROJECT MANAGER.

ELEVATION 33


SCALE 1:25







THE INTERCONTINENTAL SUZHOU
JIANGSU, CHINA


3 BAYS SUITE ROOM ELEVATIONS

DATE	4/25/09	SCALE	1:250(1/4"=50'-0")	PROJECT NO.	
DRAWN BY	STEPHEN	APPROVED BY			
FILE NAME	F:\CADD PROJECT\1-52-drawing\016267\01-0267-03\01011-01.dwg Room 3, 3-bay Suite Room (27F)				
16-09-09					


DWG. NO. IE-3BS-09

REVISION 

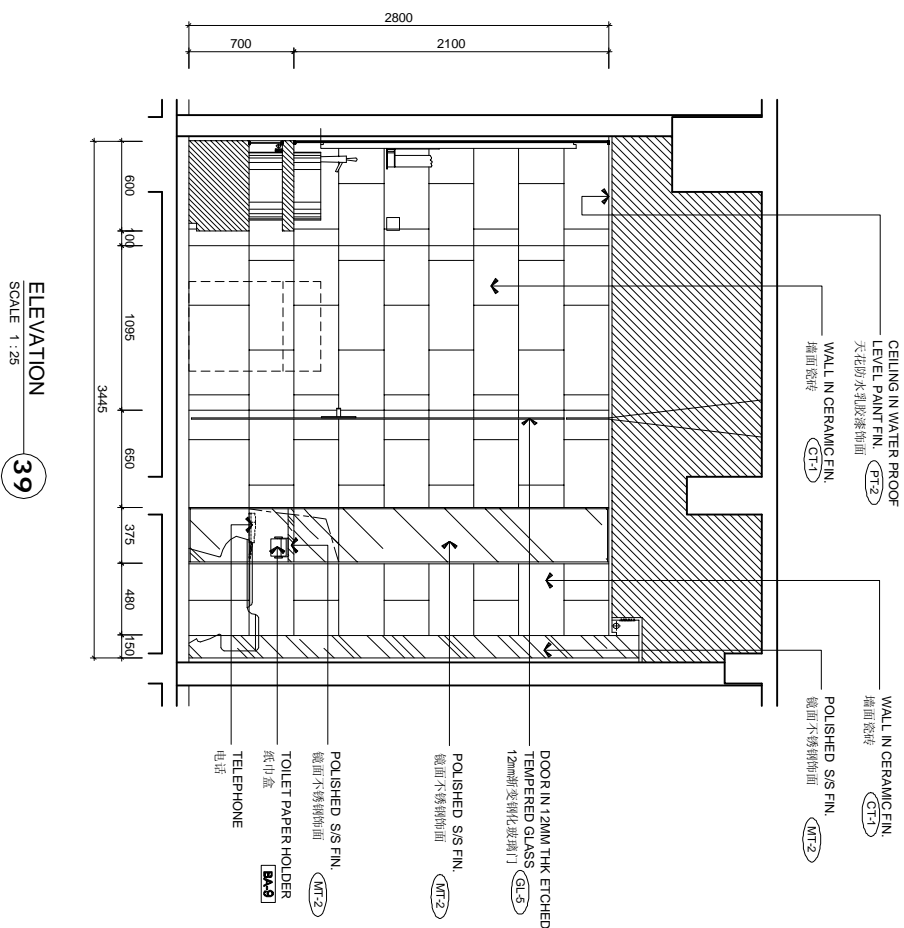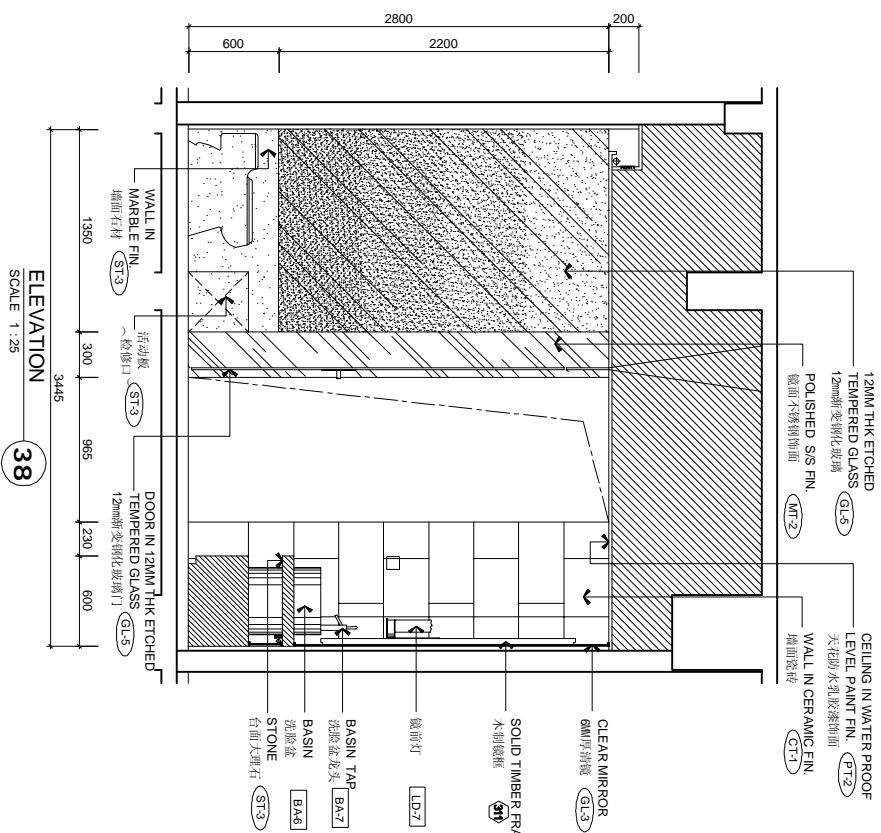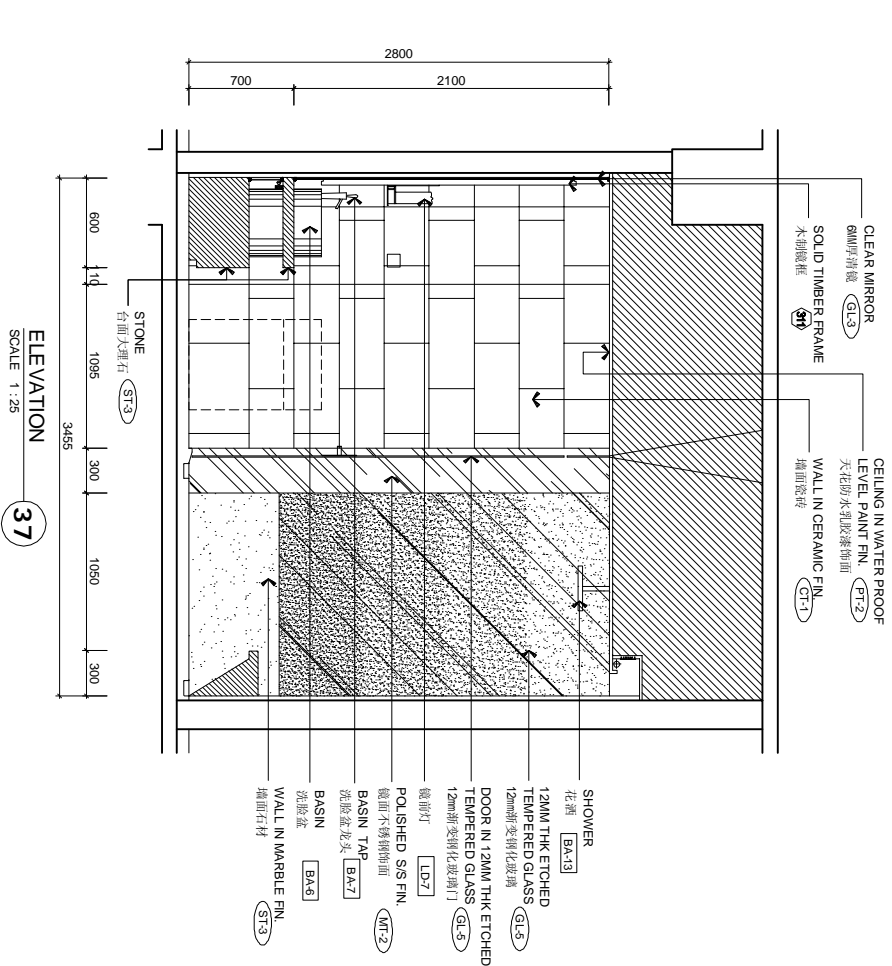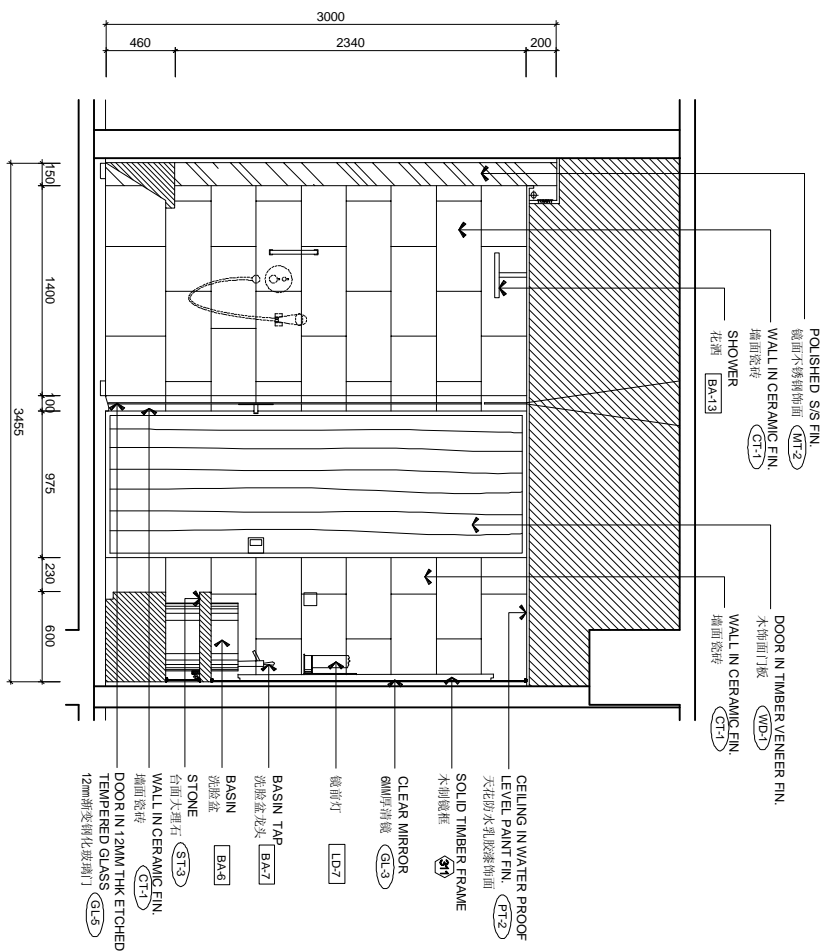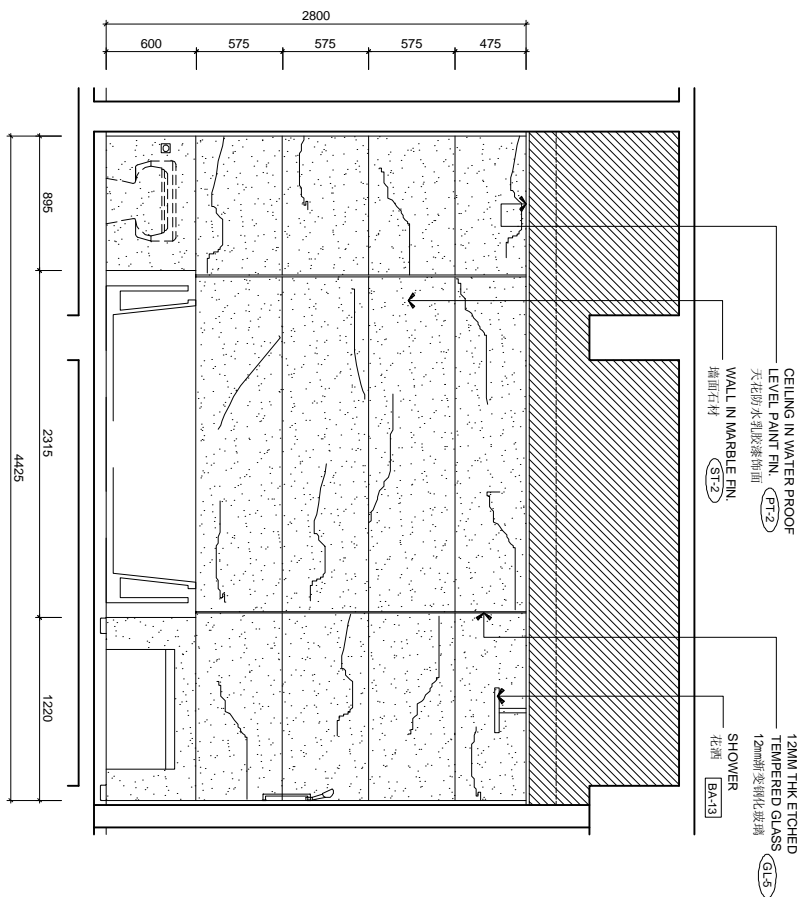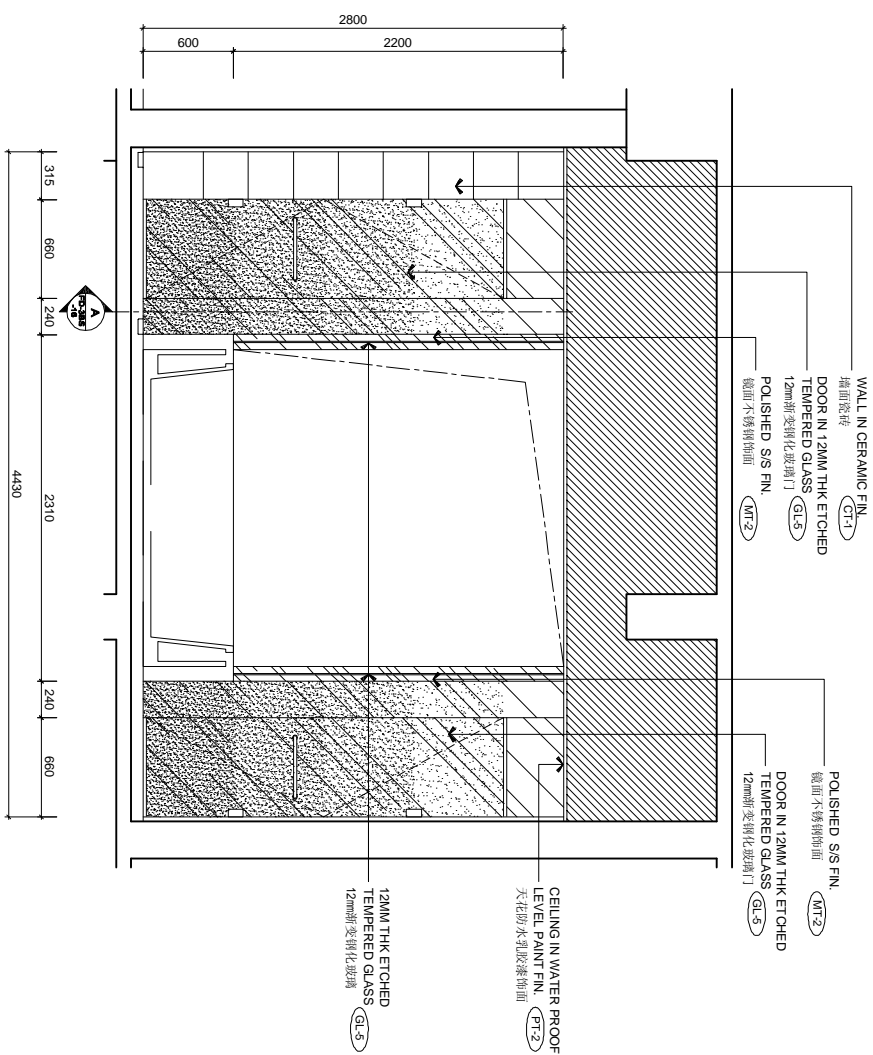
[illegible]

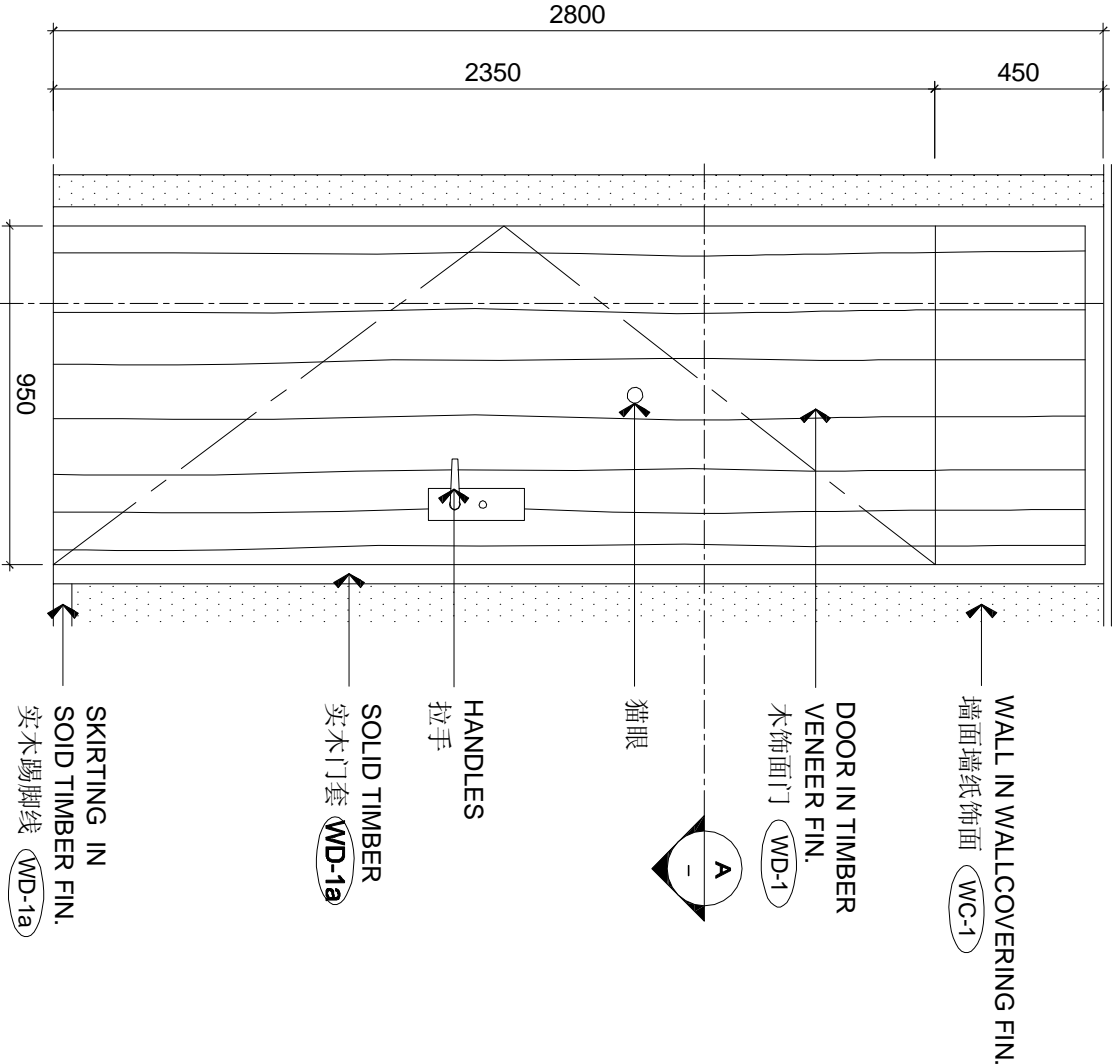


ELEVATION
SCALE 1 : 20
2

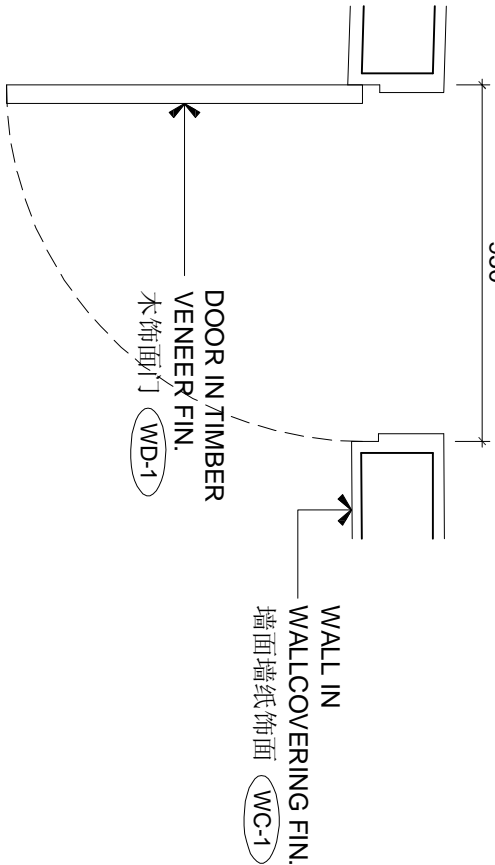

PLAN
SCALE 1 : 20
1

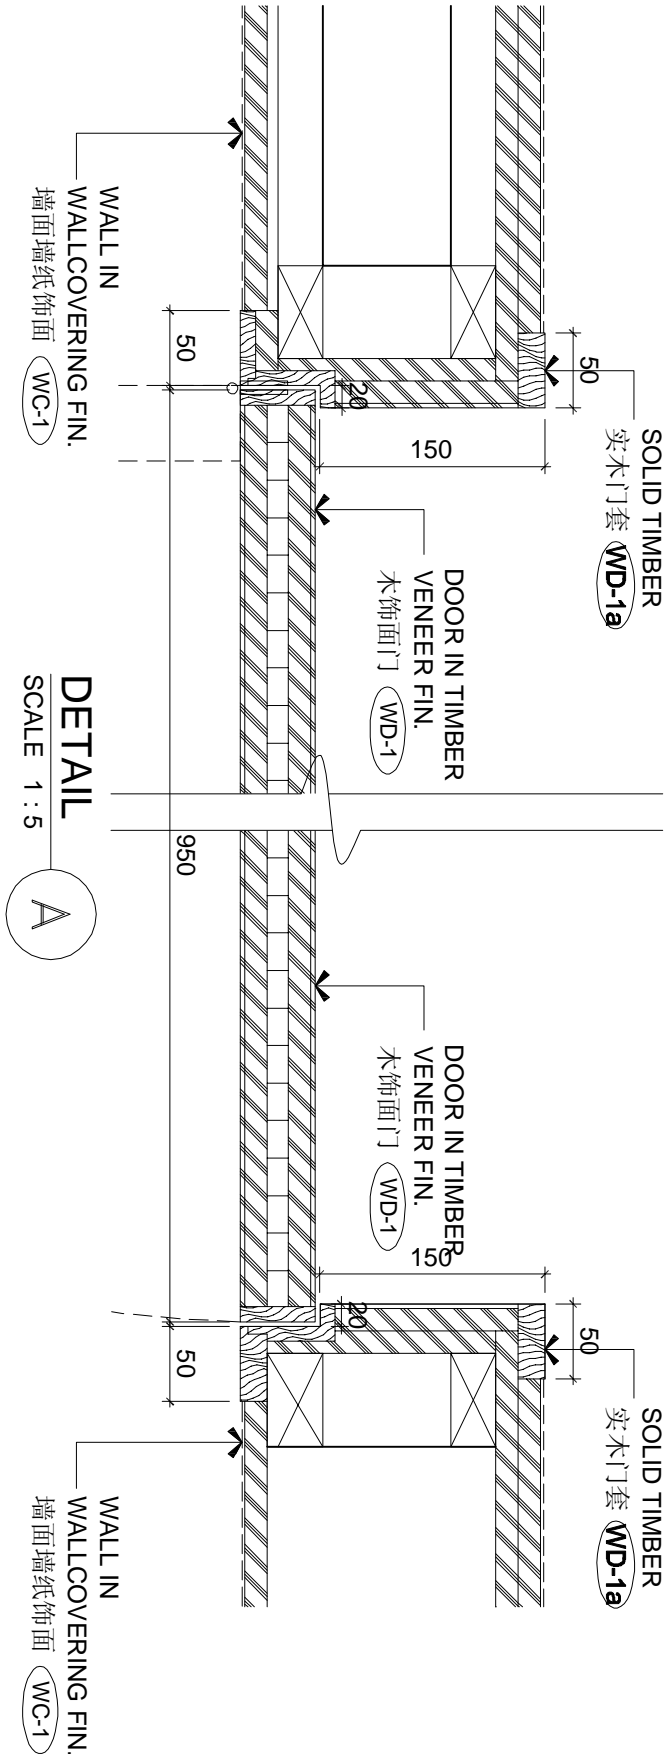


DETAIL
SCALE 1 : 5
A

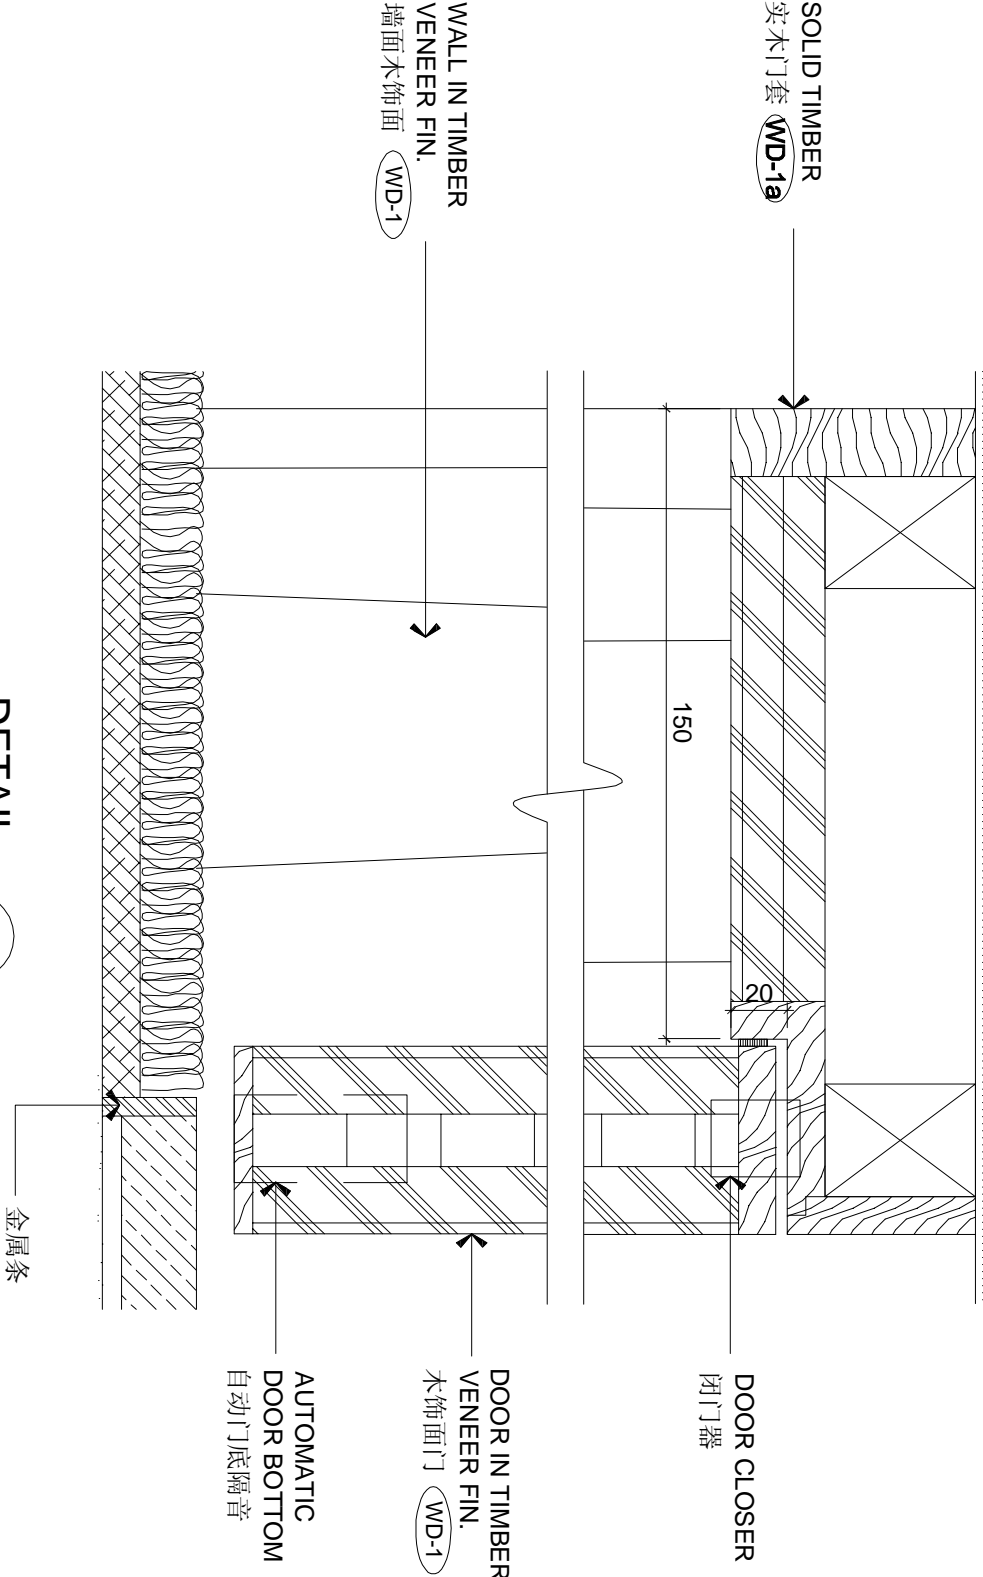


DETAIL
SCALE 1 : 2
B

REVISIONS AND ISSUES												CHHADA SIEMBIEDA LEUNG												THE INTERCONTINENTAL SUZHOU												3 BAYS SUITE ROOM - DETAILS												FD-3BS-01											
LOCATION OF REVISIONS ARE INDICATED ON DWG. AS												Limited, Design Consultants Hong Kong																																															
ISSUED FOR TENDER DRAWING																																																											
DATE												24/06/09																																															
1												2												3												4												5											
2												3												4												5												6											
3												4												5												6												7											

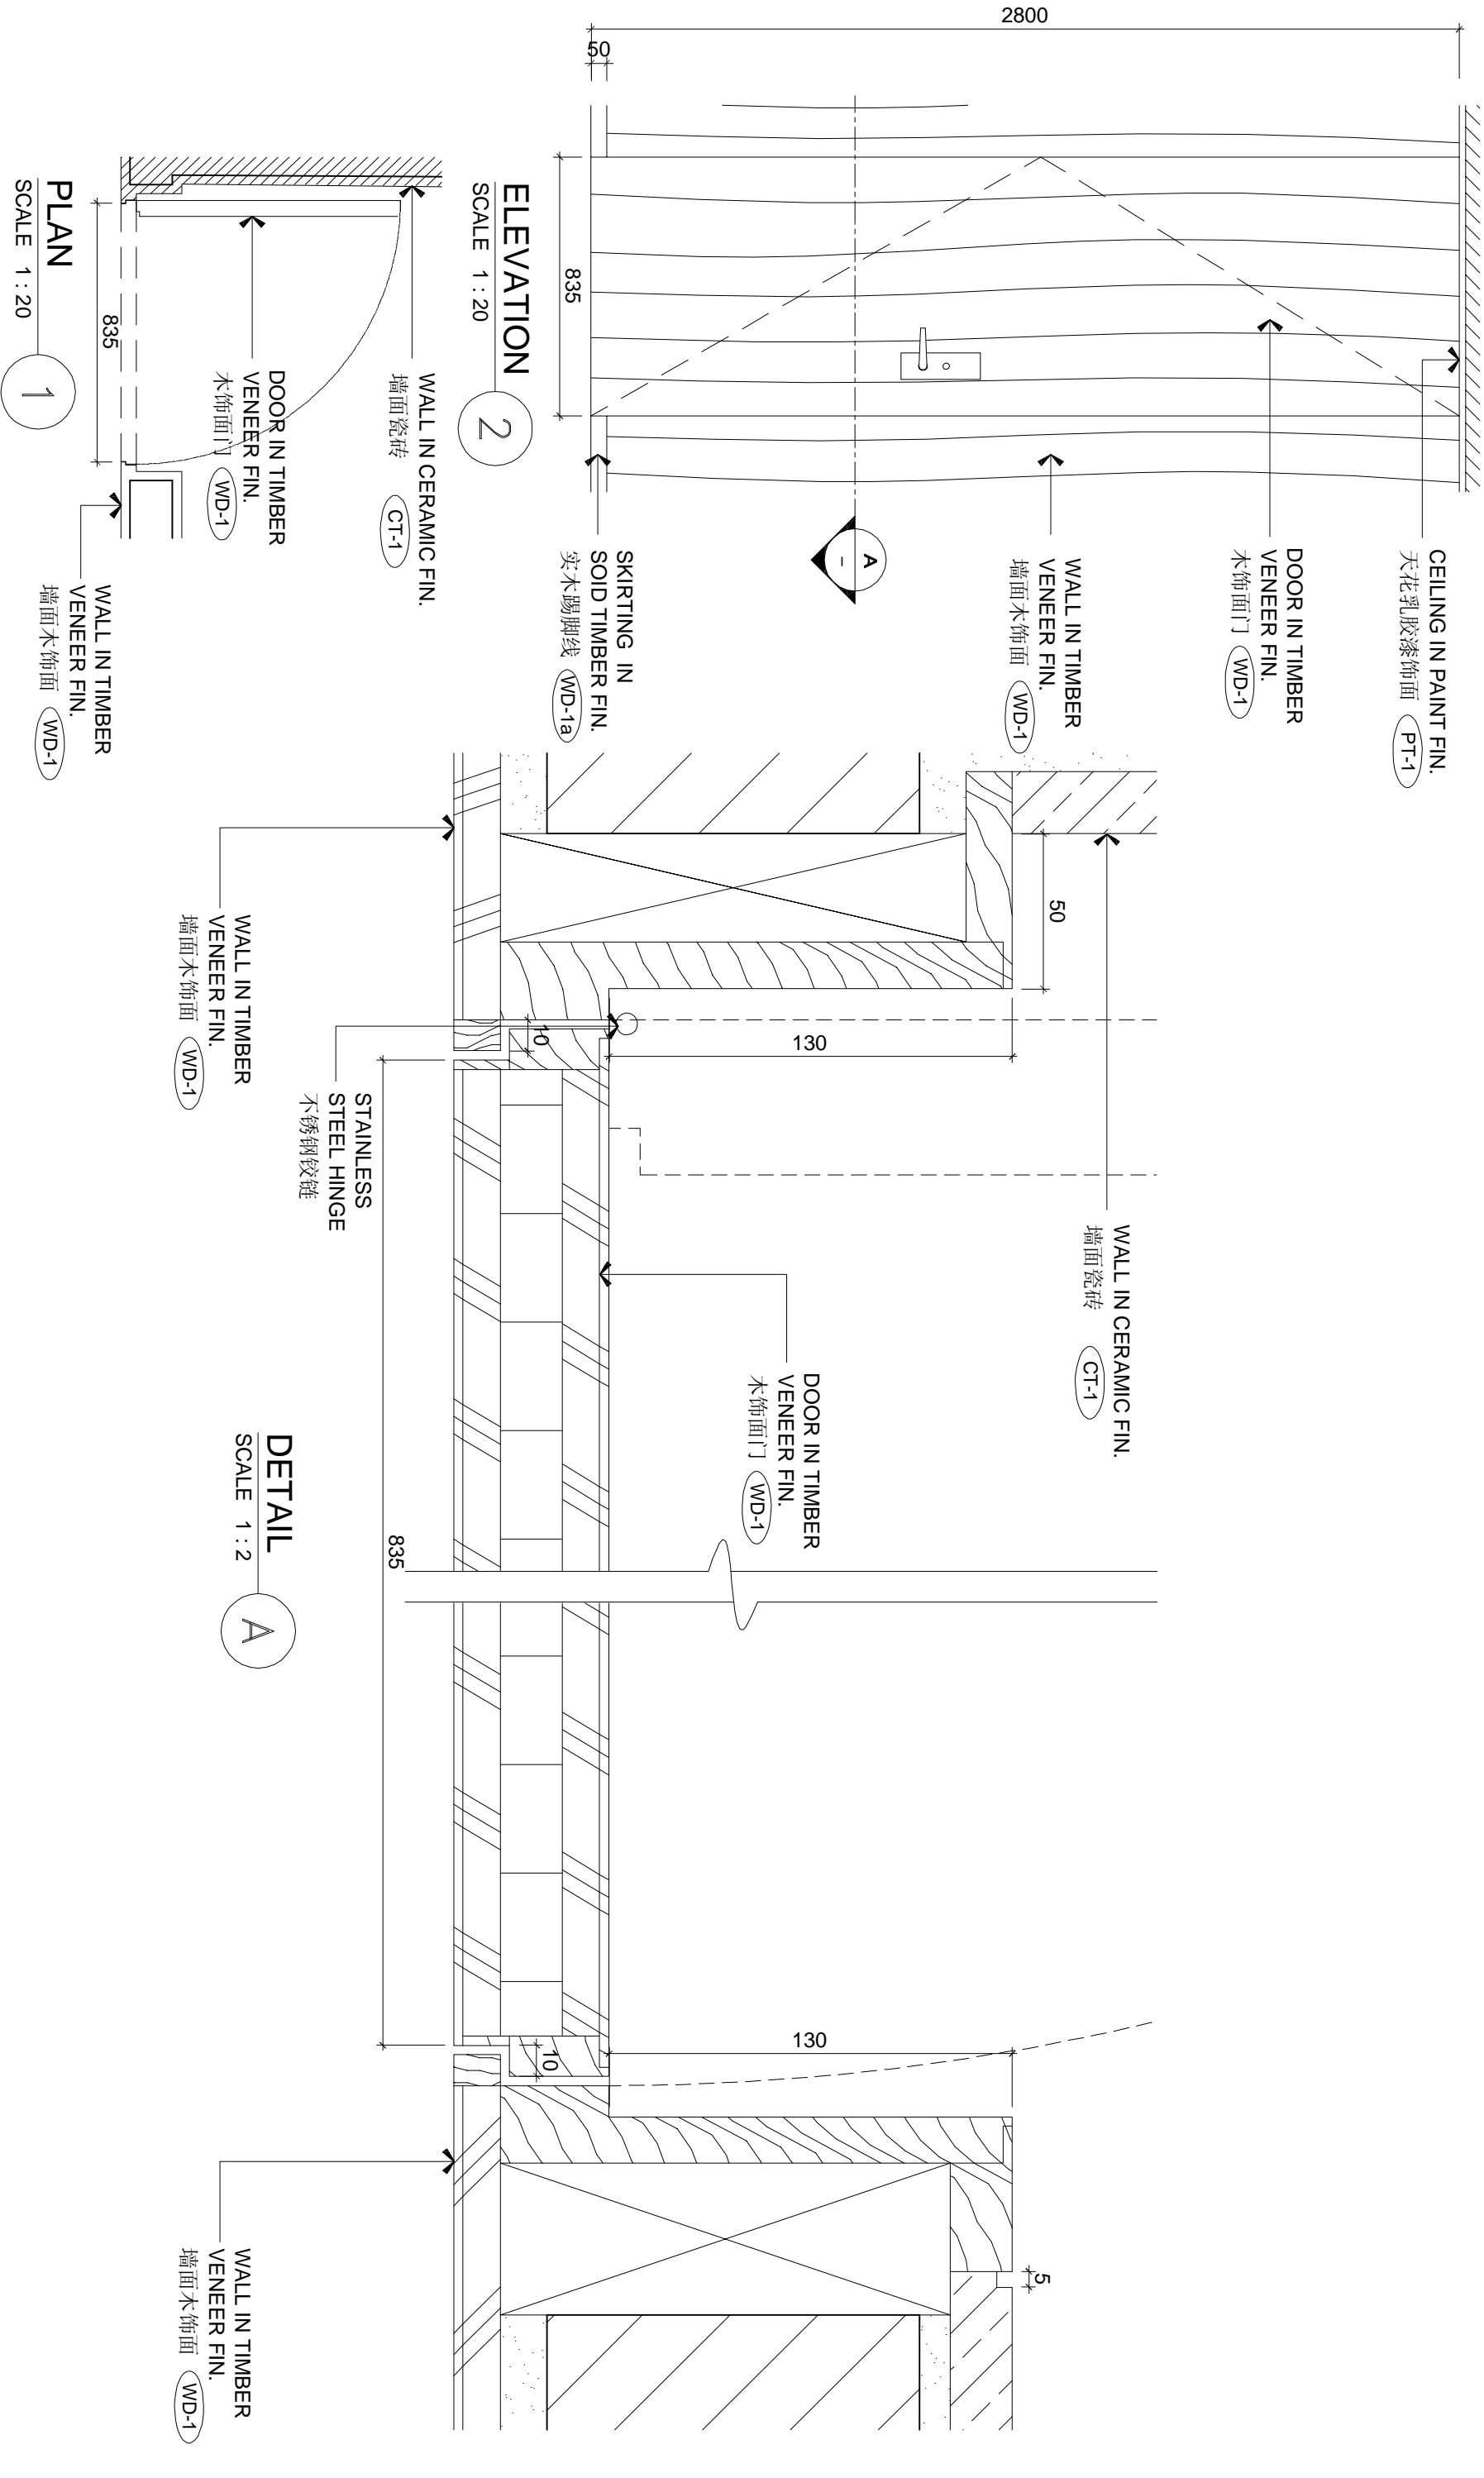

REVISIONS AND ISSUES				CHHADA SIEMBIEDA LEUNG			
LOCATIONS OF REVISIONS ARE INDICATED ON DWG. AS				Limited, Design Consultants Hong Kong			
ISSUED FOR TENDER DRAWING				THE INTERCONTINENTAL SUZHOU			
				JIANGSU, CHINA			
				3 BAYS SUITE ROOM - DETAILS			
				DWG. NO.			
				FD-3BS-02			
				DATE			
				4/25/09			
				DRAWN BY			
				STEPHEN			
				APPROVED BY			
				07-01			
				FILE NAME			
				FD-3BS-02-01.dwg			
				PROJECT NO.			
				07-01			
				REVISION			
				A			

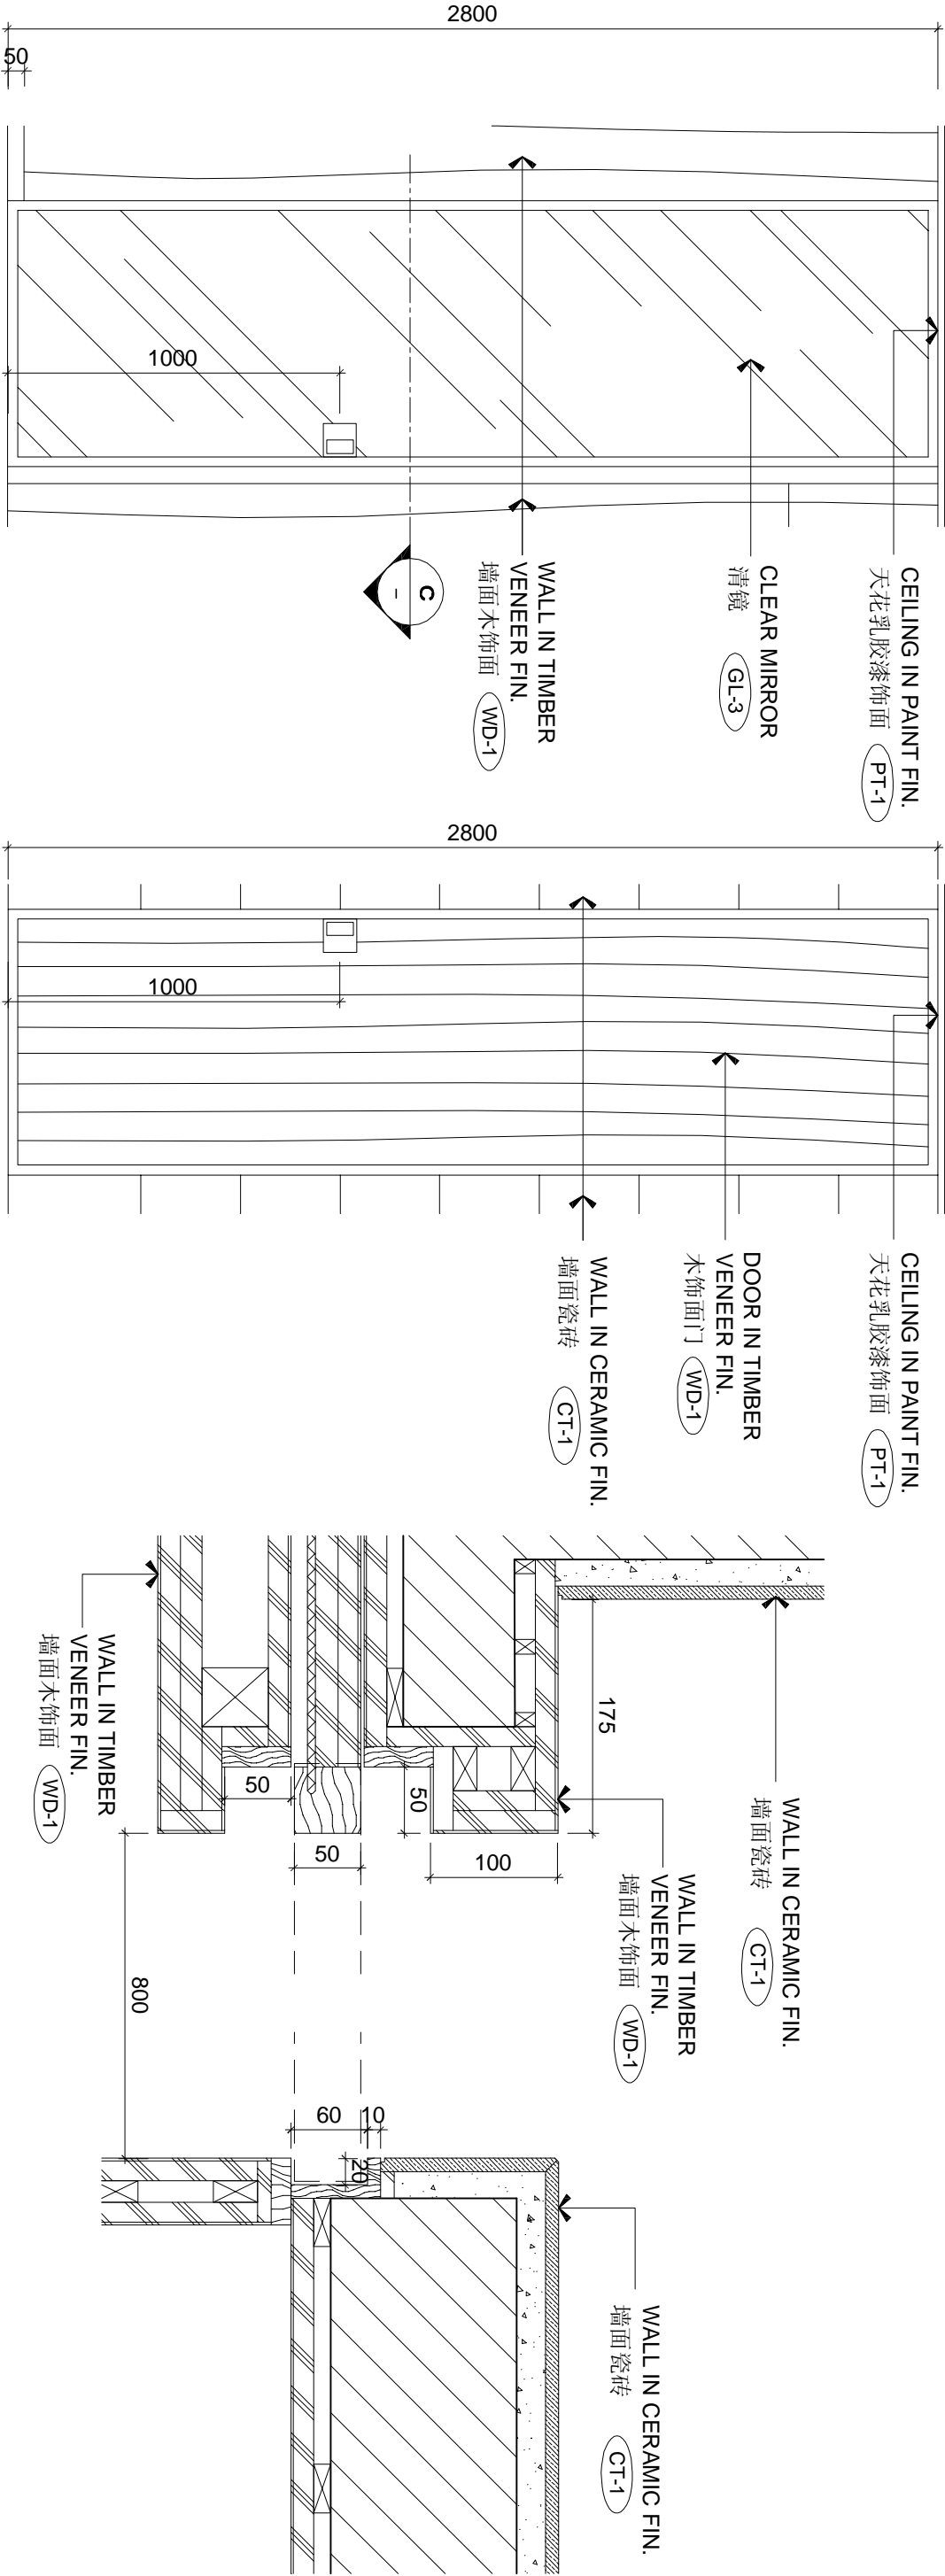


ELEVATION 2
SCALE 1 : 20

ELEVATION 3
SCALE 1 : 20

DETAIL A
SCALE 1 : 5

DETAIL B
SCALE 1 : 5




PLAN
SCALE 1 : 20

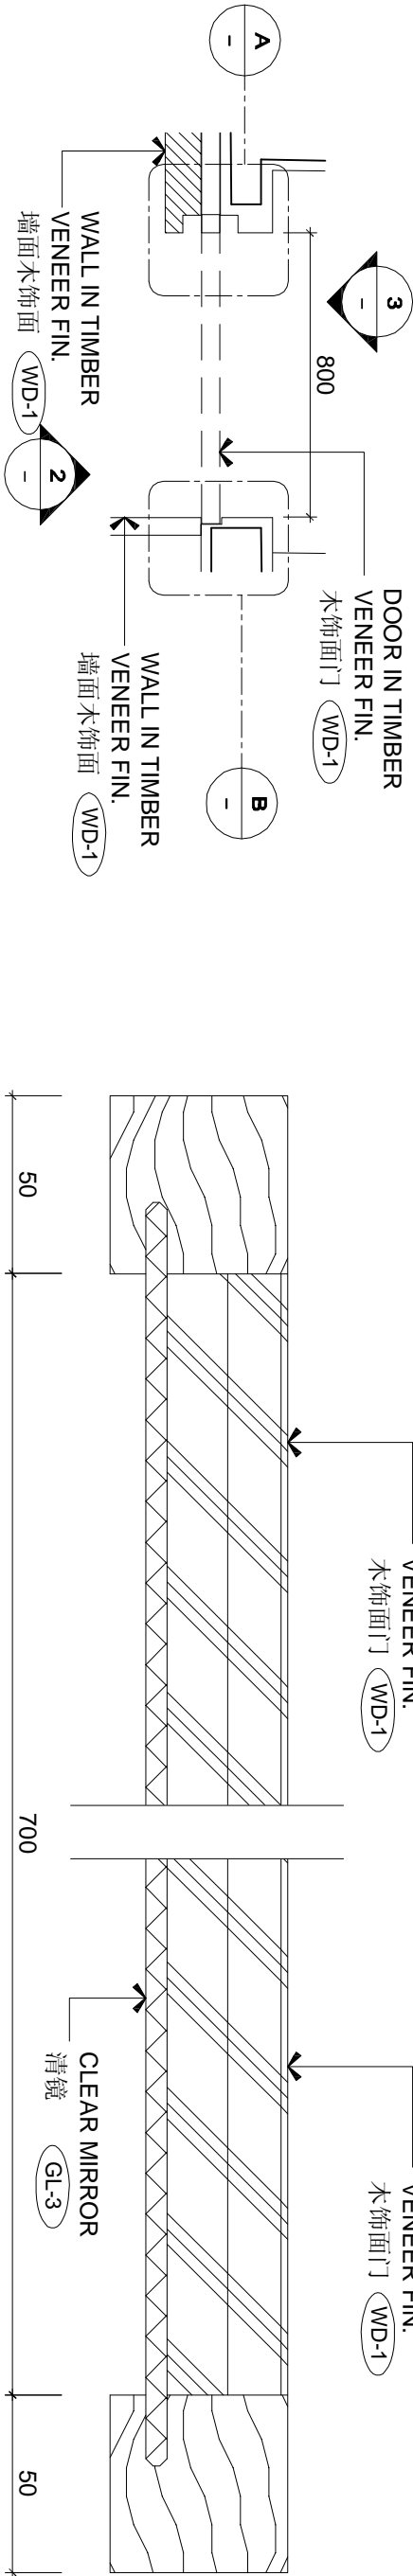


DETAIL C
SCALE 1 : 2

REVISIONS AND ISSUES		LOCATION OF REVISIONS ARE INDICATED ON DWG. AS	
NO.	DATE	ISSUED FOR	REVISION
1	2004/08	AS SHOWN	AS SHOWN
2			
3			
4			
100			


CHHADA SIEMBIEDA LEUNG		THE INTERCONTINENTAL SUZHOU	
Limited, Design Consultants Hong Kong		JIANGSU, CHINA	
ALL DRAWINGS, PLANS & SPECIFICATIONS ARE THE PROPERTY OF CHHADA SIEMBIEDA LEUNG. ANY REUSE, REPRODUCTION, OR DISTRIBUTION OF ANY PART OF THIS DRAWING WITHOUT THE WRITTEN PERMISSION OF CHHADA SIEMBIEDA LEUNG IS STRICTLY PROHIBITED. ANY DISCREPANCIES SHALL BE REPORTED IMMEDIATELY TO CHHADA SIEMBIEDA & LEUNG LTD. IMMEDIATELY BY THE CONTRACTOR AND/OR PROJECT MANAGER.		3 BAYS SUITE ROOM - DETAILS	
DATE		SCALE	
DRAWN BY		AS SHOWN (A3)	
STEPHEN		PROJECT NO.	
APPROVED BY		07-01	
FILE NAME		FD-3BS-03	
FD-3BS-03		REVISION	
FD-3BS-03		A	

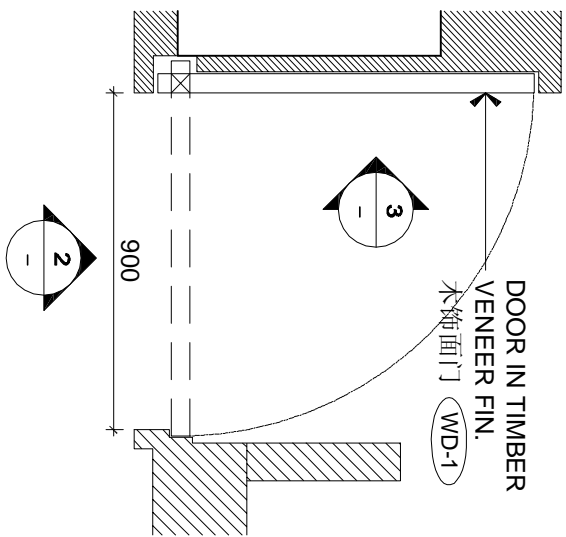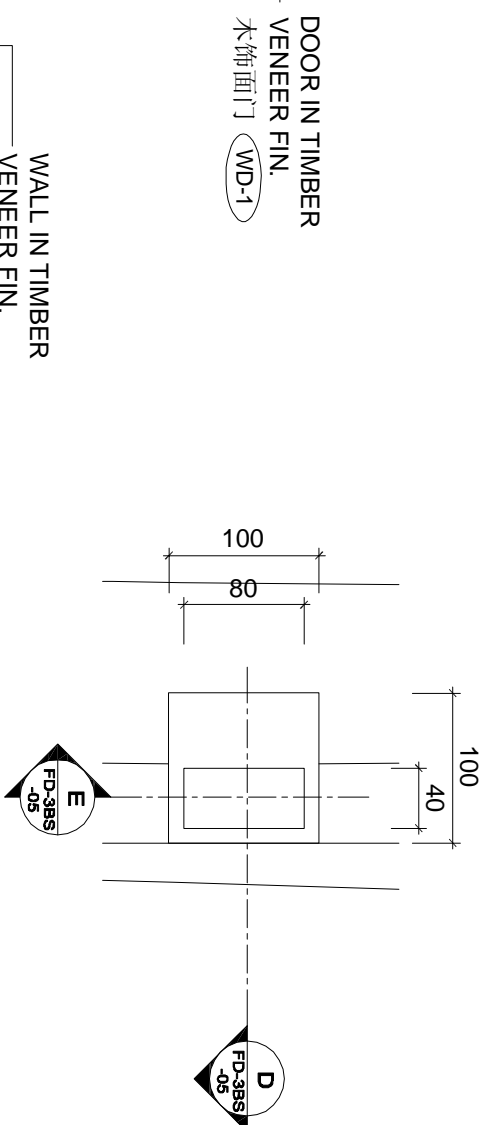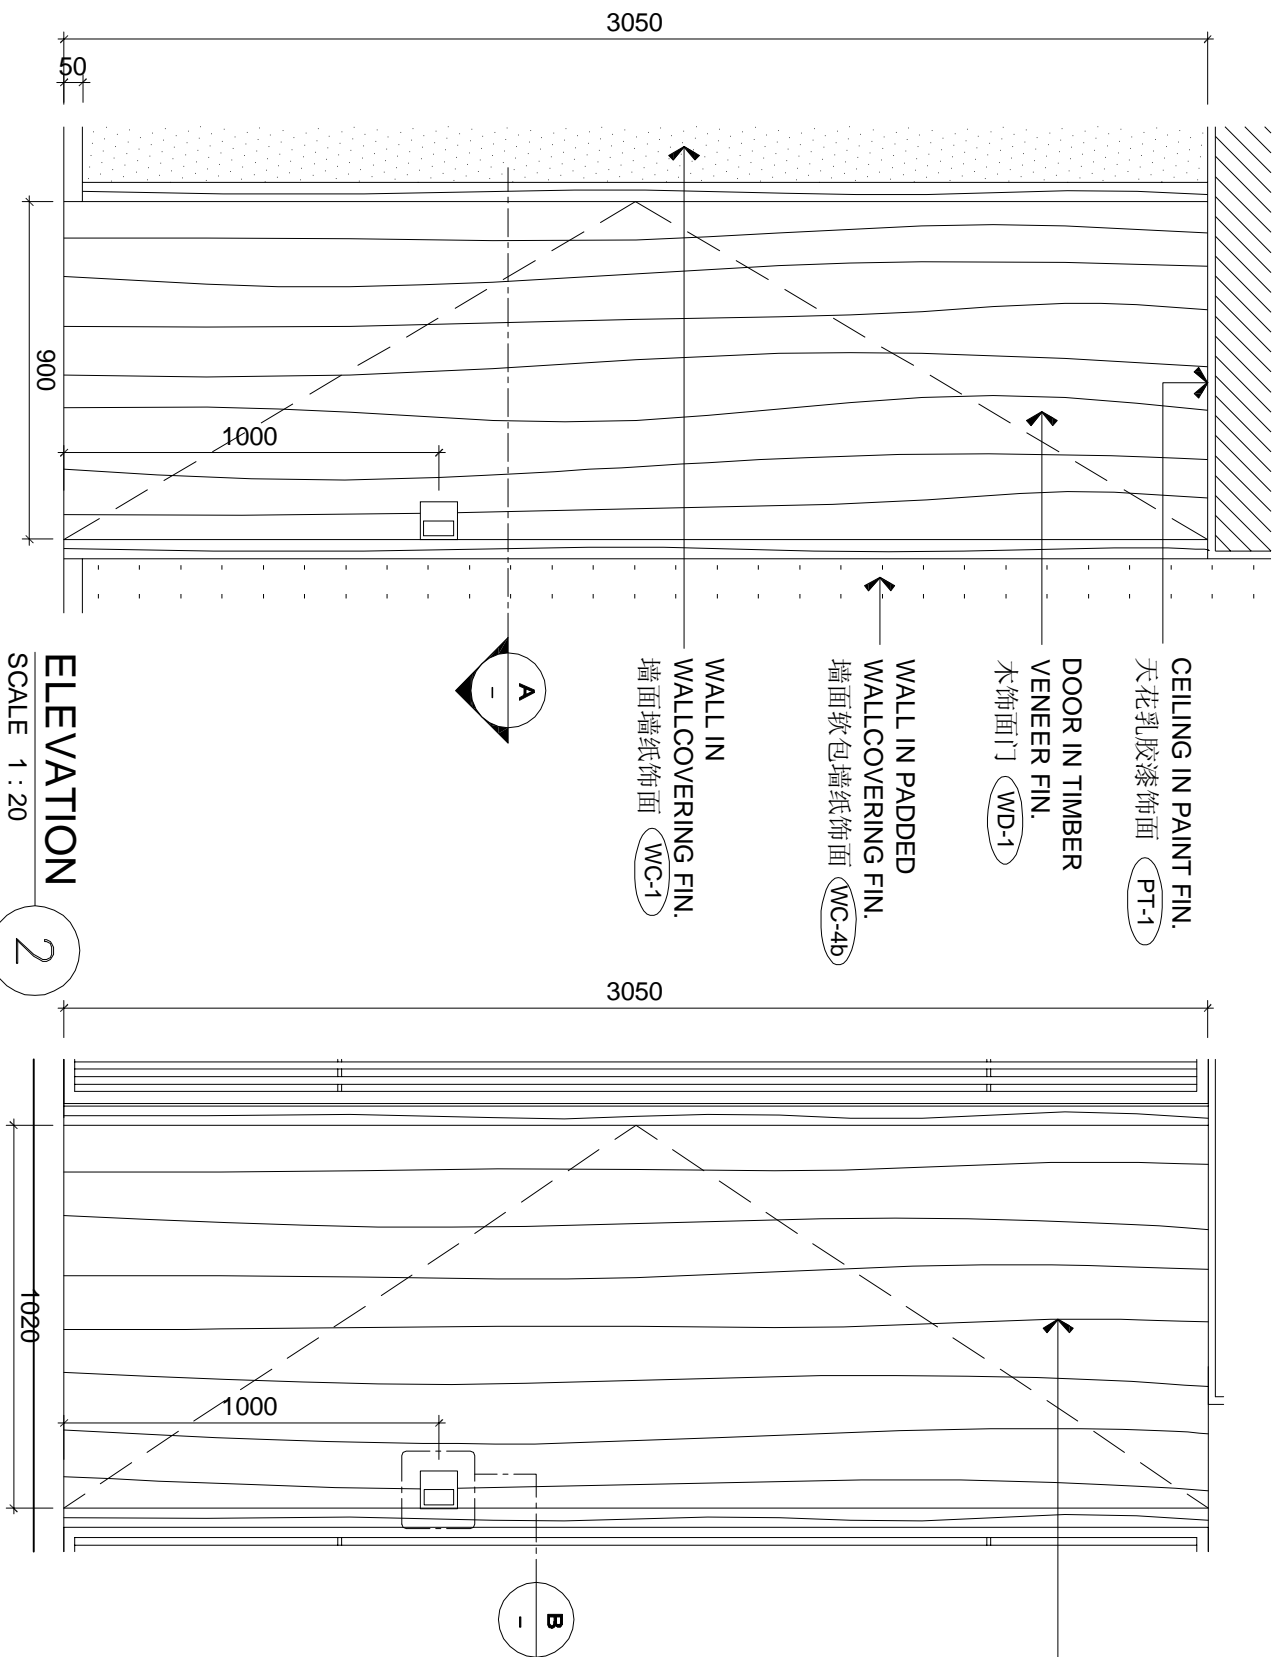





PLAN
SCALE 1 : 20

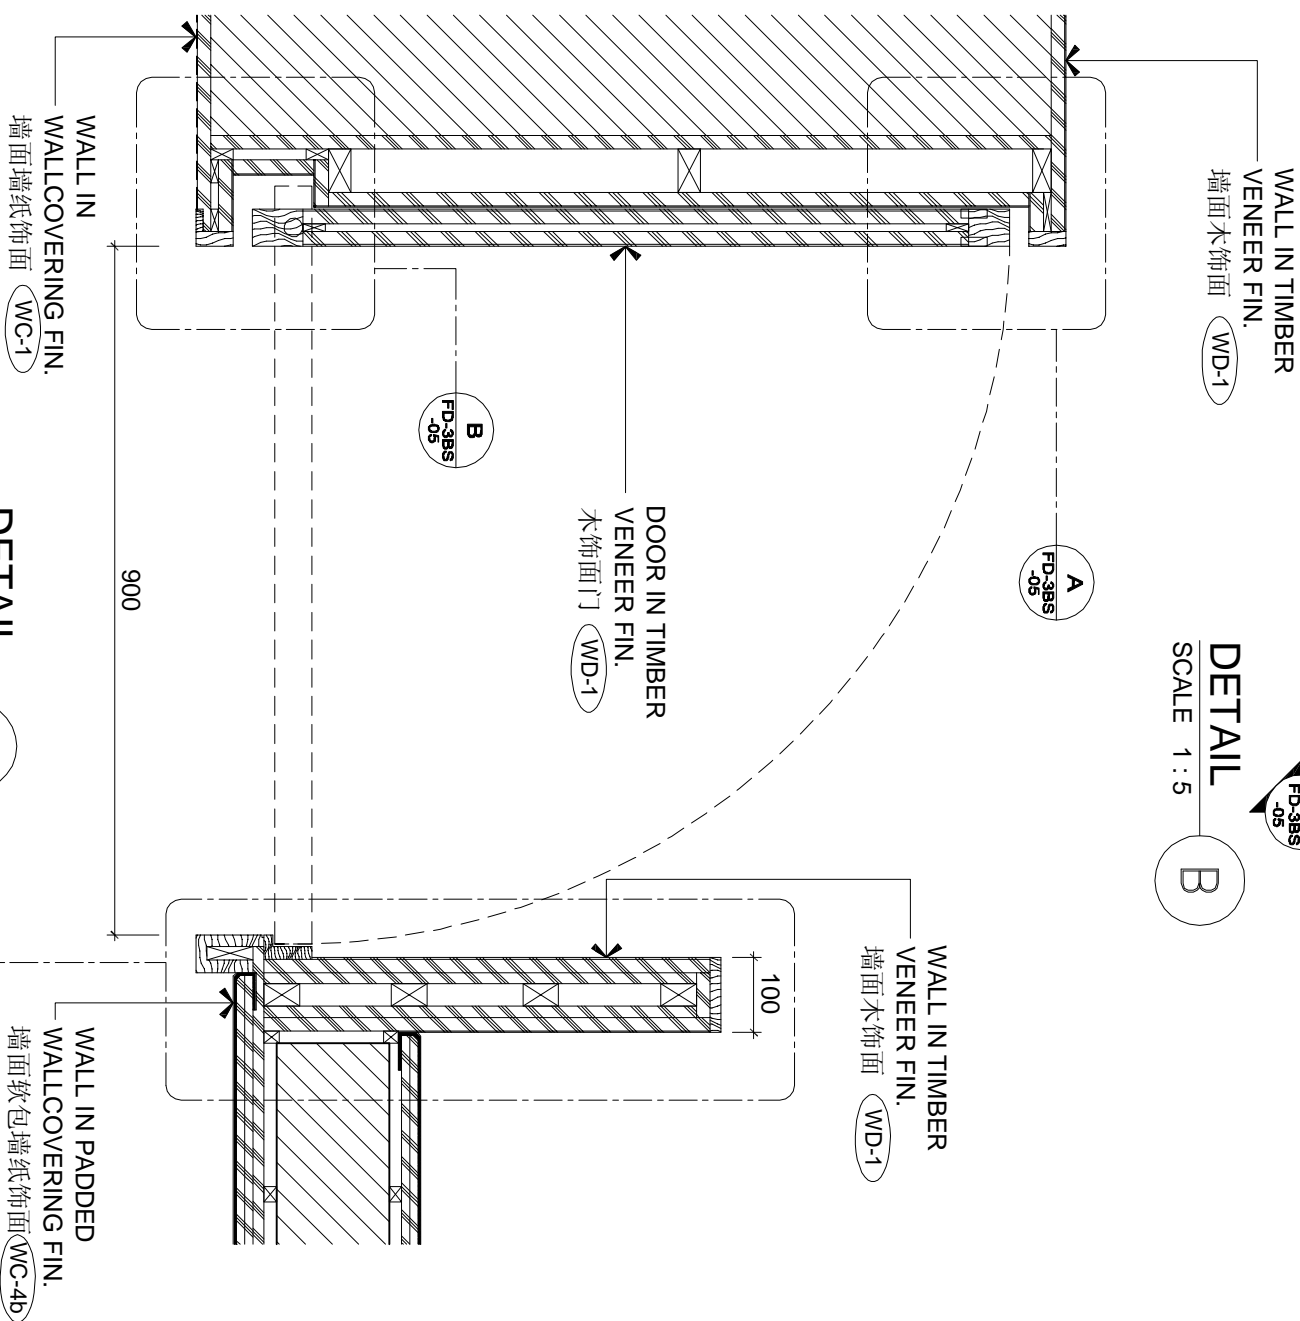

DETAIL
SCALE 1 : 10

A circular detail callout containing the letter 'A' in a bold, sans-serif font. The circle is thin and black.



REVISIONS AND ISSUES				DATE		△		△		△		DWG. NO.	
LOCATION OF REVISIONS AND INDICATED ON DWG. AS				△									
1 ISSUED FOR TENDER DRAWING				20-04-09		△		△					
△				△				△					
△								△					
△								△					
CHIHADA SIEMBIEDA LEUNG Limited Design Consultants Hong Kong													
THE INTERCONTINENTAL SUZHOU JIANGSU, CHINA													
3 BAYS SUITE ROOM - DETAILS												FD-3BS-04	
DATE		4/25/09		SCALE		AS SHOWN (AS)		PROJECT NO.				REVISION	
DRAWN BY		STEPHEN		APPROVED BY		07-01						△	
FILE NAME												F:\1\CD PROJECT\1\20-04-09\11-02-01\01\11-04-09-00-01-0	

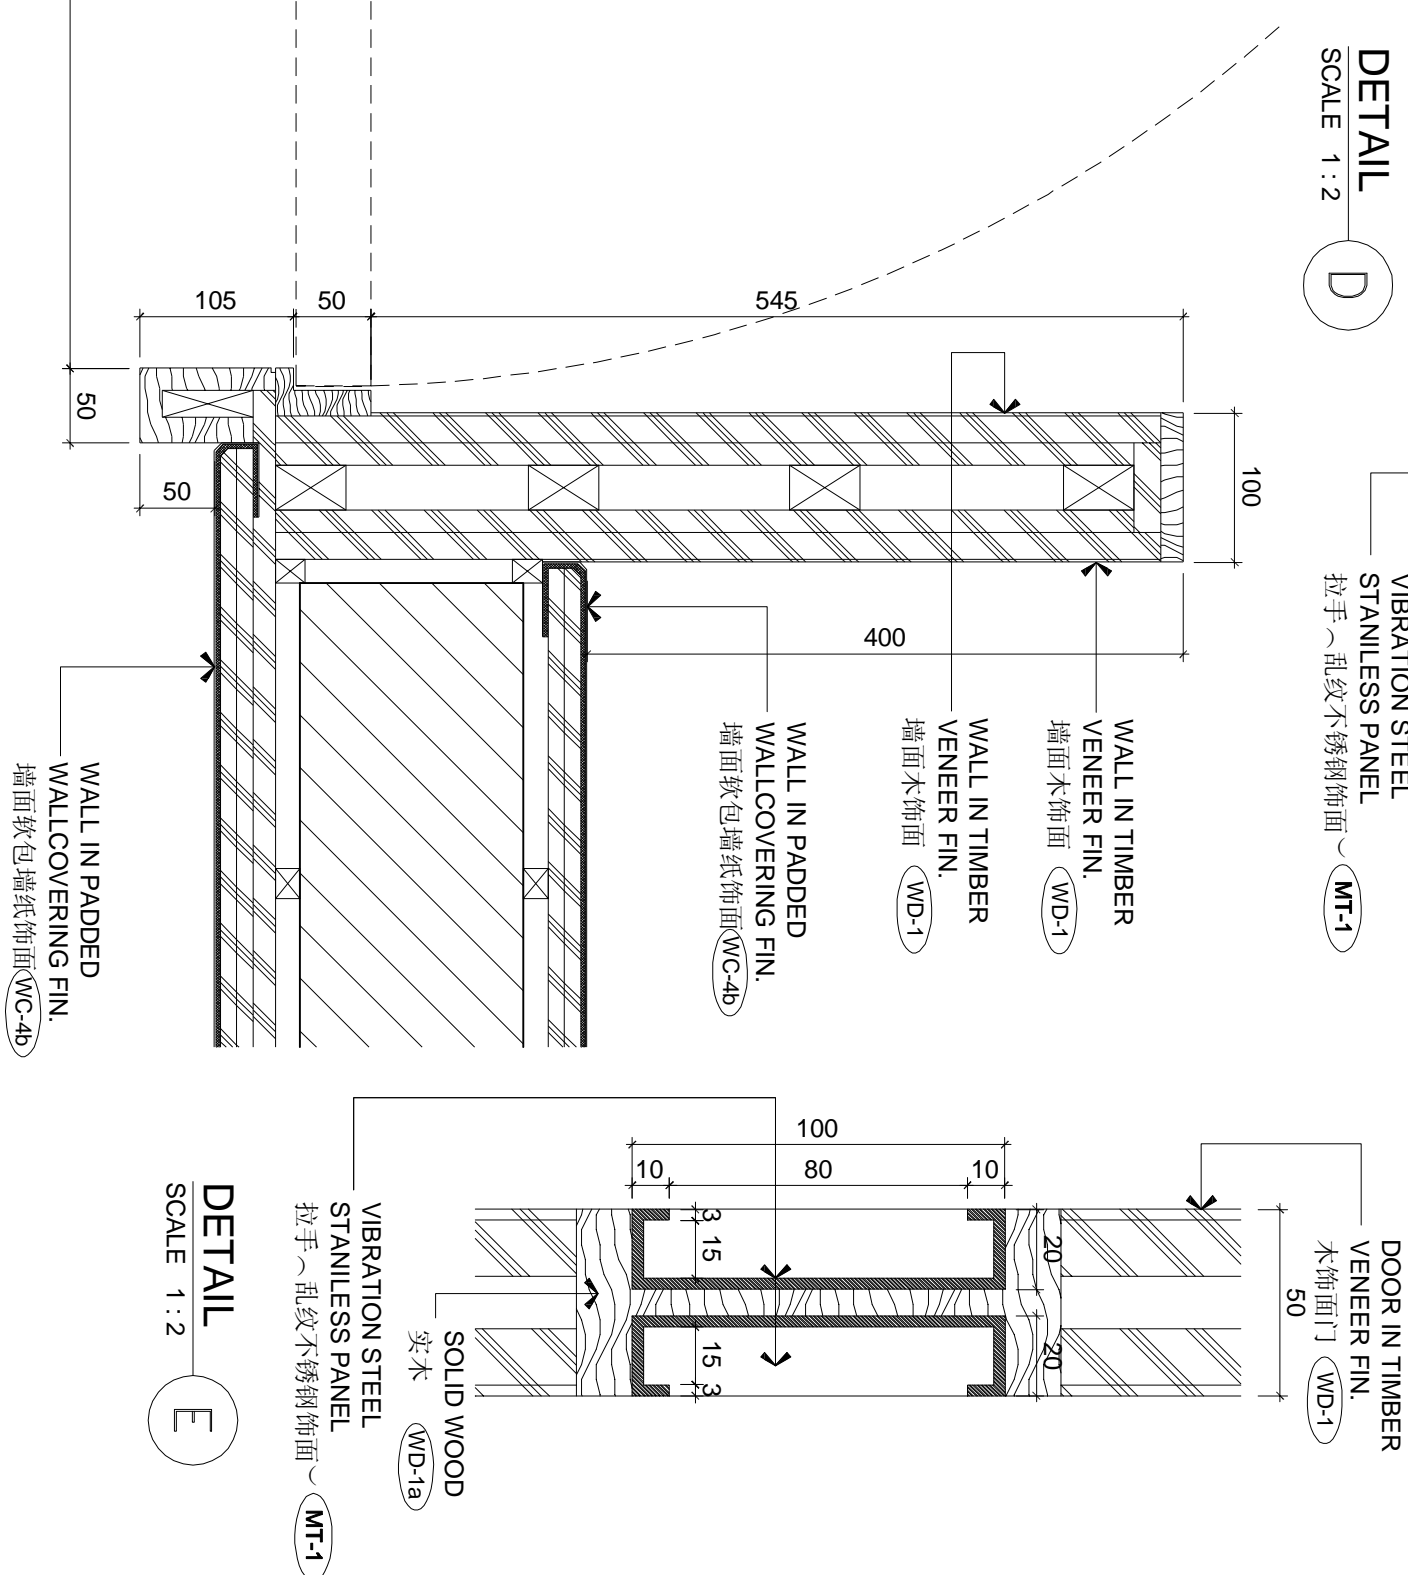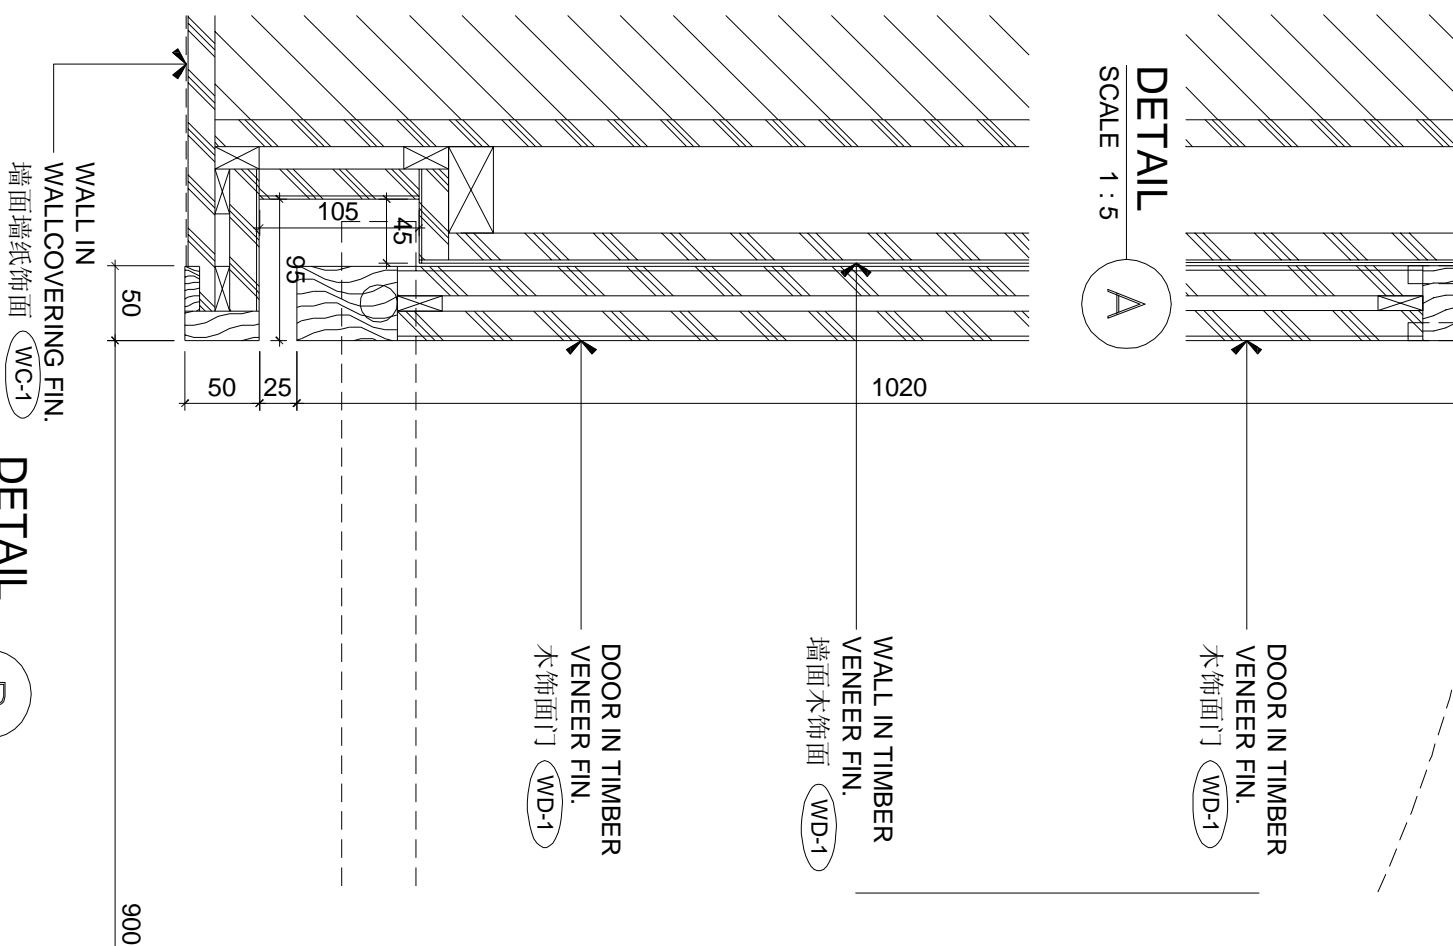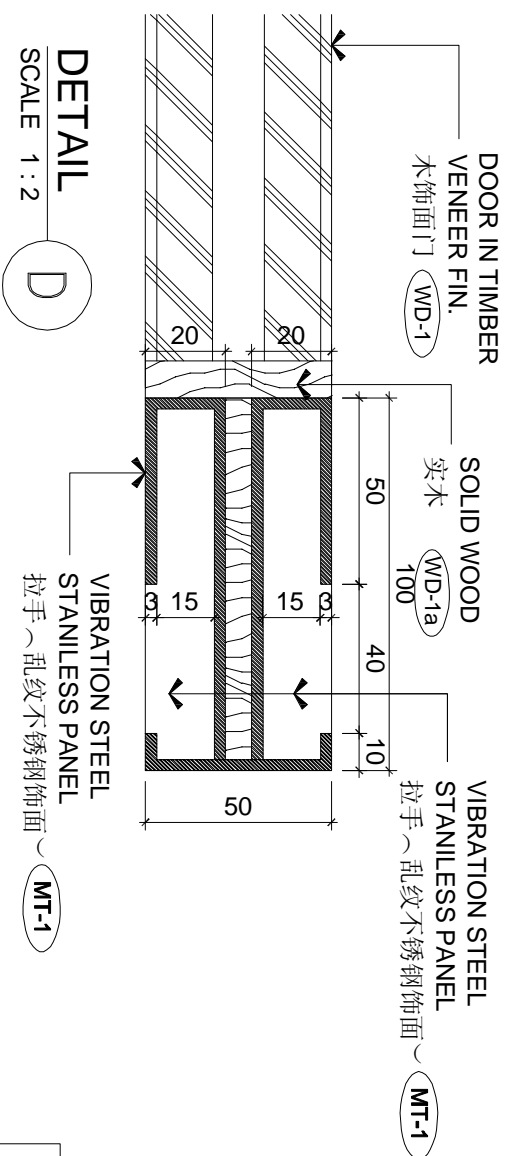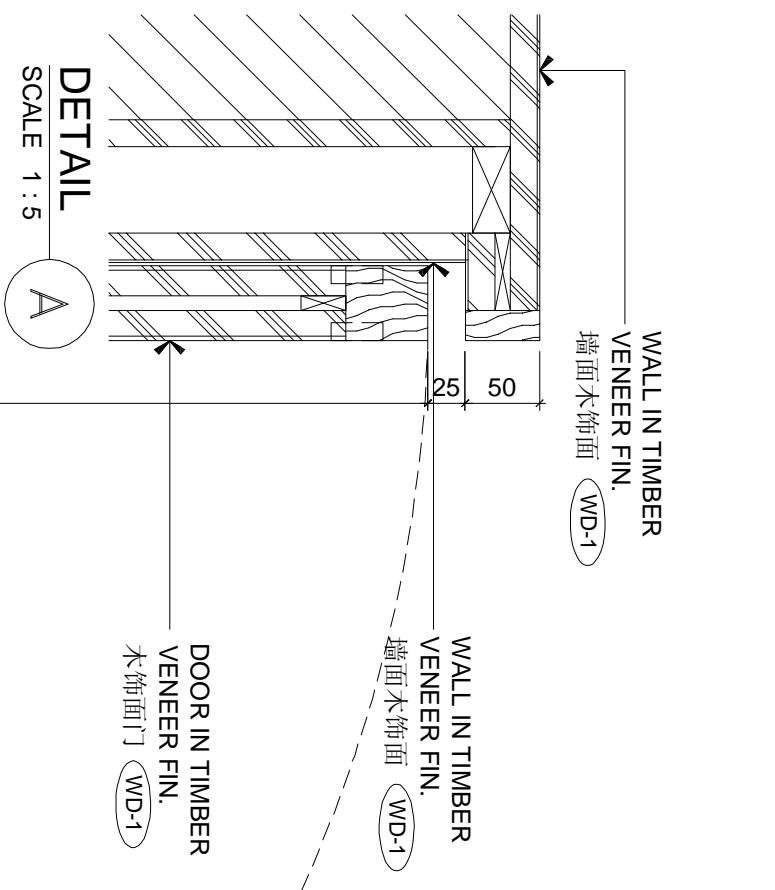[illegible]

ELEVATION

2


SCALE 1 : 20

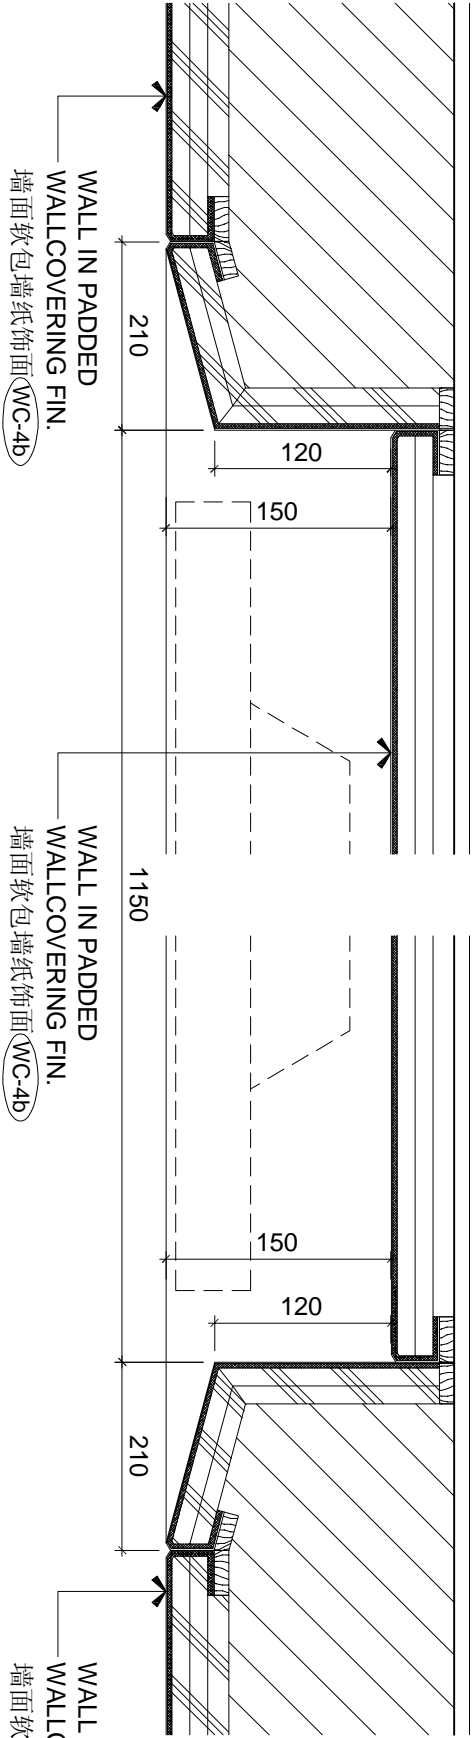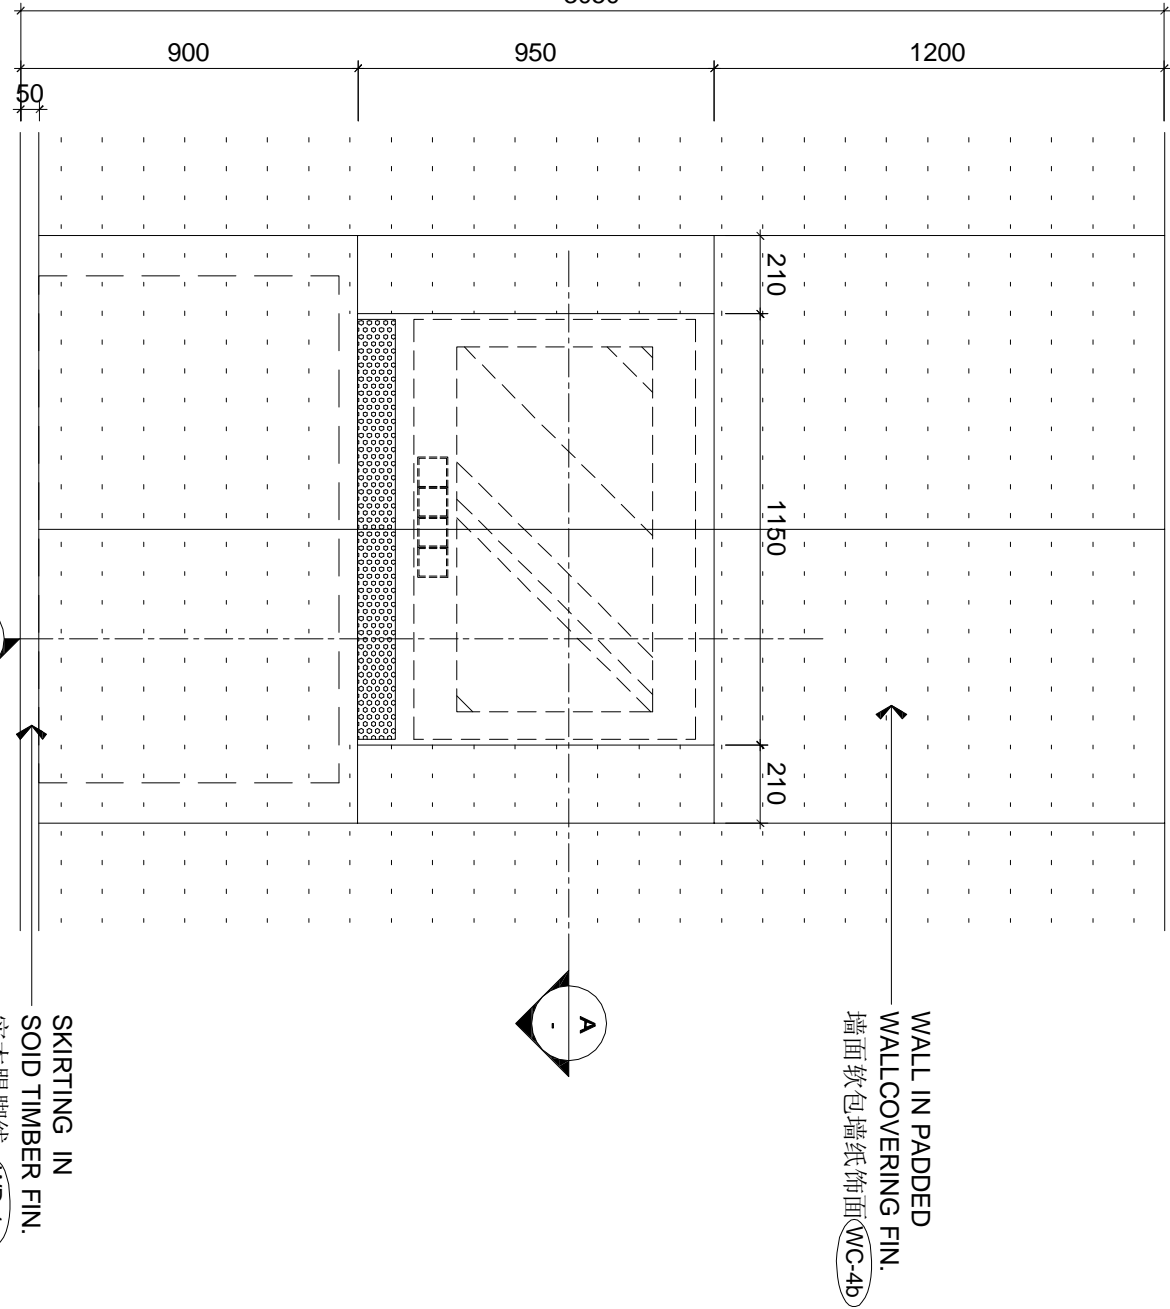

DETAIL

A

SCALE 1 : 5

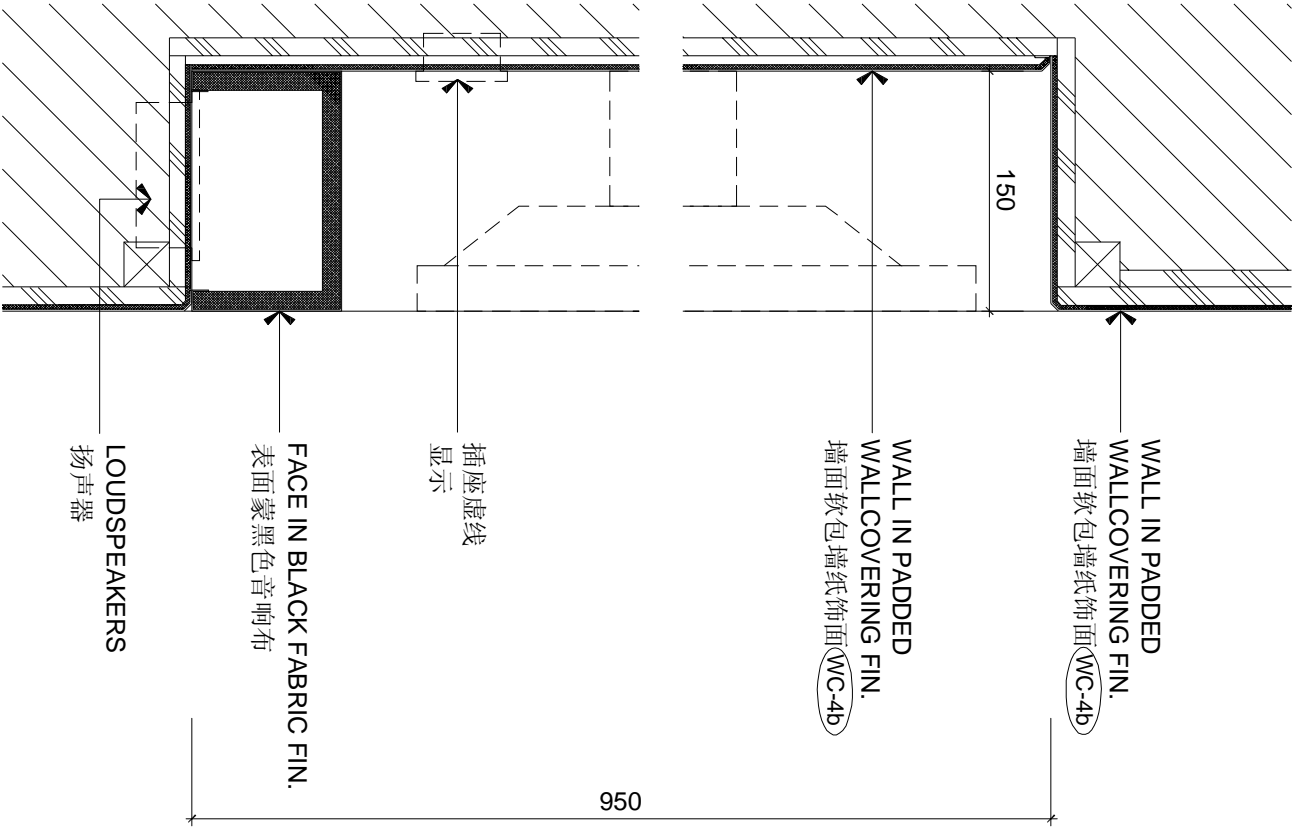







DETAIL


B

SCALE 1 : 5

REVISIONS AND ISSUES				CHHADA SIEMBIEDA LEUNG				THE INTERCONTINENTAL SUZHOU				3 BAYS SUITE ROOM - DETAILS				DWG. NO. FD-3BS-06	
LOCATION OF REVISIONS ARE INDICATED ON DWG. AS ISSUED FOR TENDER DRAWING				Limited, Design Consultants Hong Kong				JIANGSU, CHINA				DATE 4/28/09 DRAWN BY STEPHEN FILE NAME FD-01-08.dwg					
												SCALE AS SHOWN (A3)					
												PROJECT NO. 07-01					
												APPROVED BY					


REVISIONS AND ISSUES										DATE	A																																																																																																																																																																																																																																																																																																																																																																																																																																																																																																																																																																																																																																																																																																																																
----------------------	--	--	--	--	--	--	--	--	--	------	---	--	--	
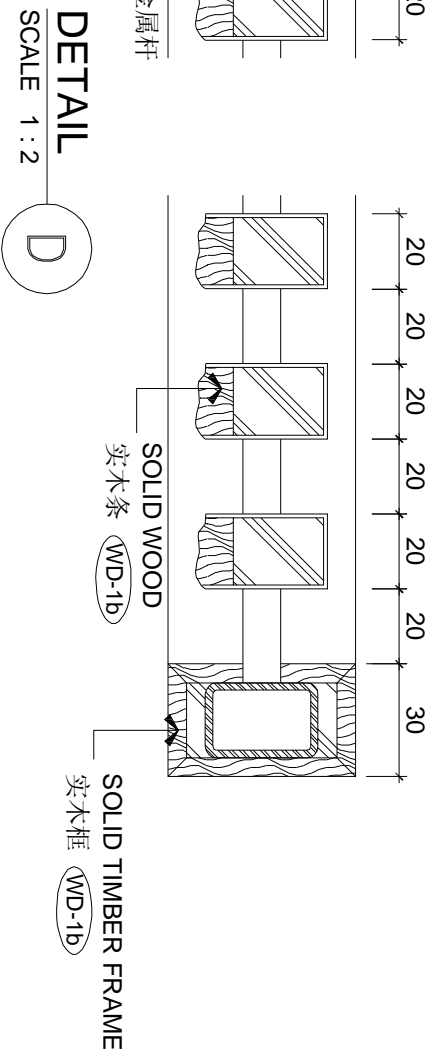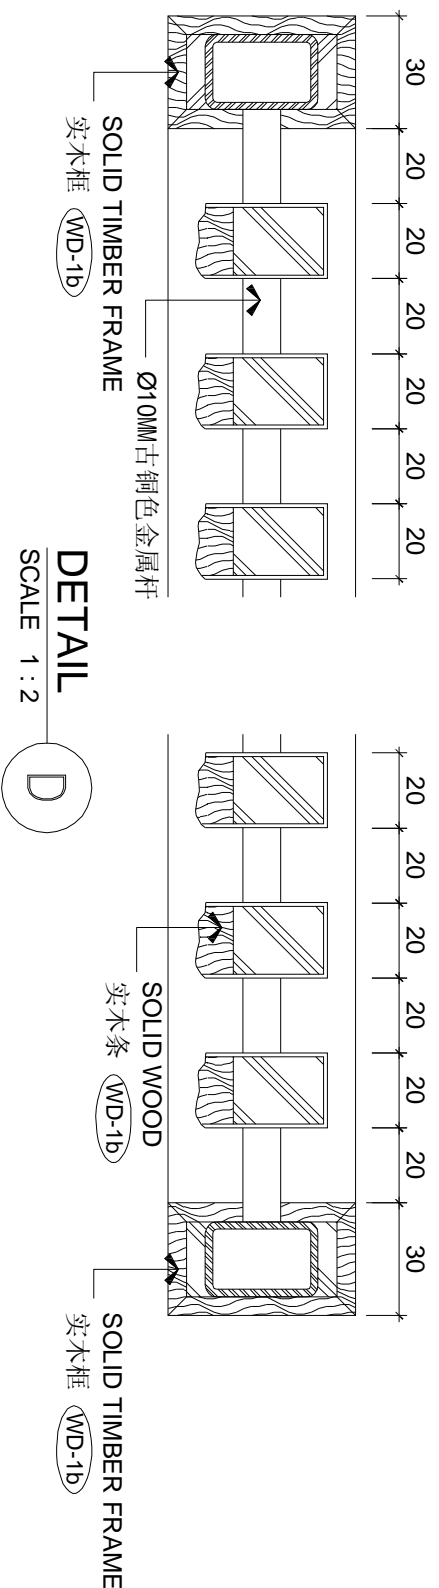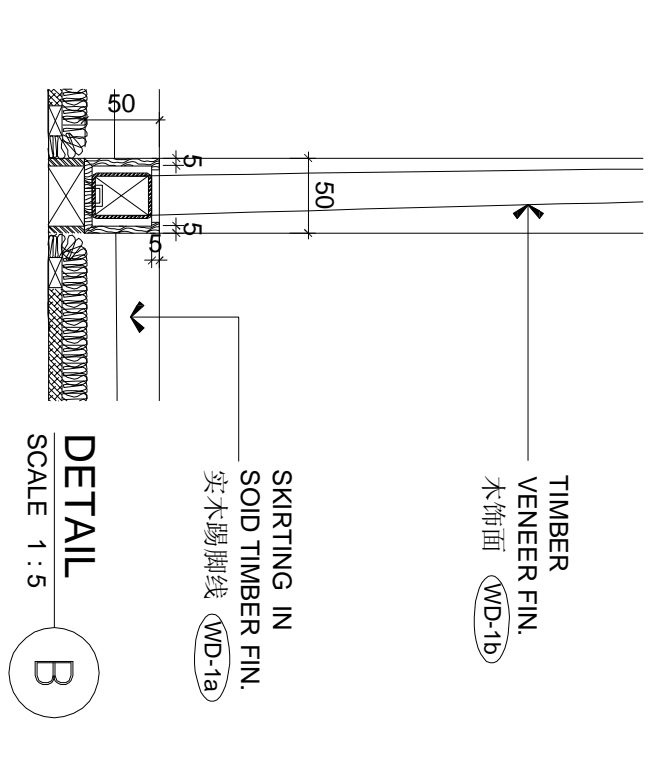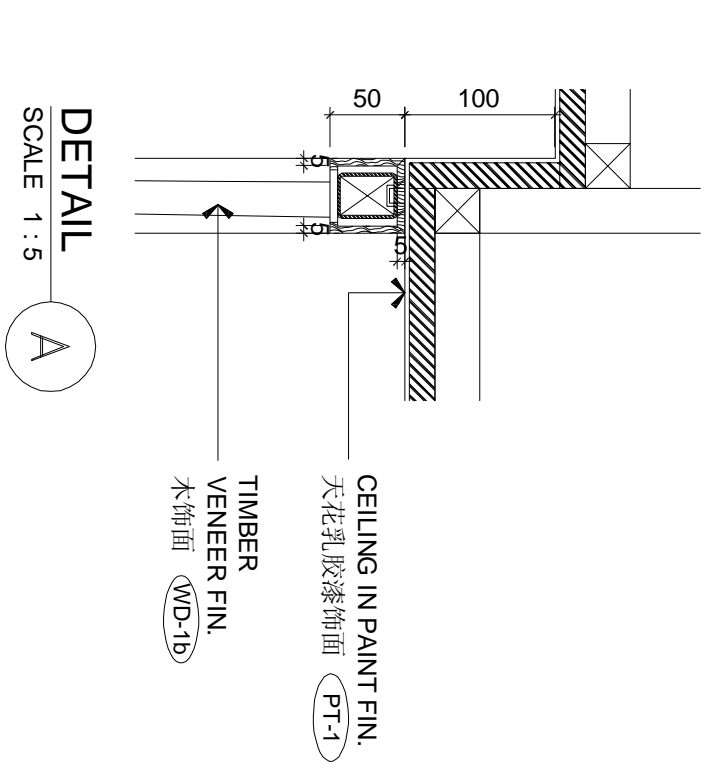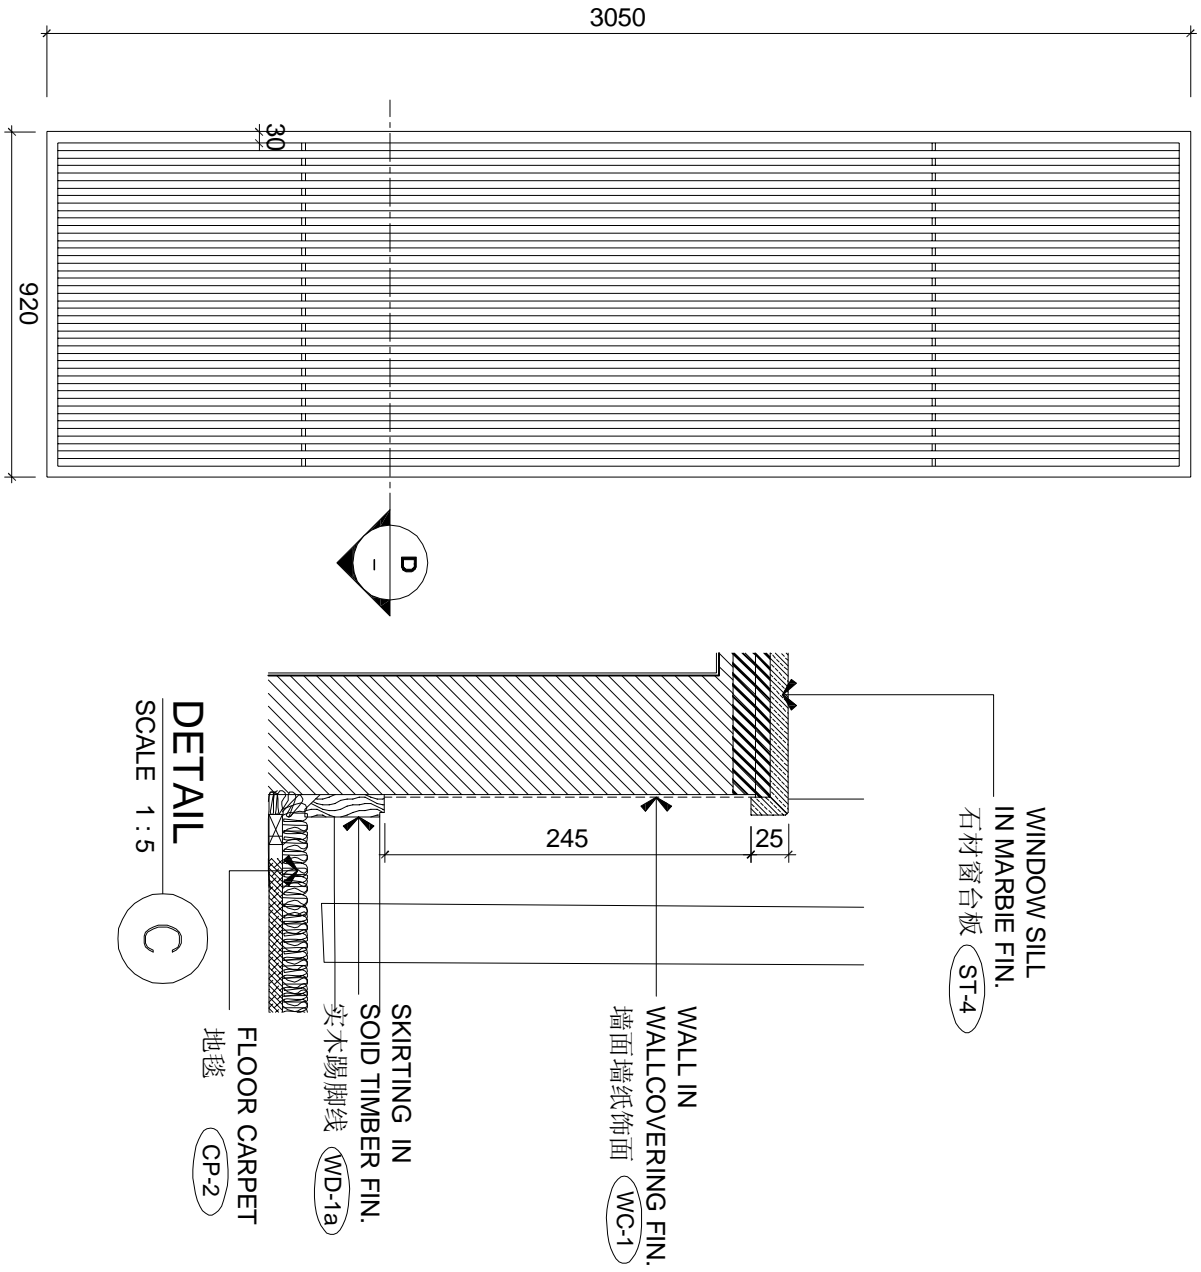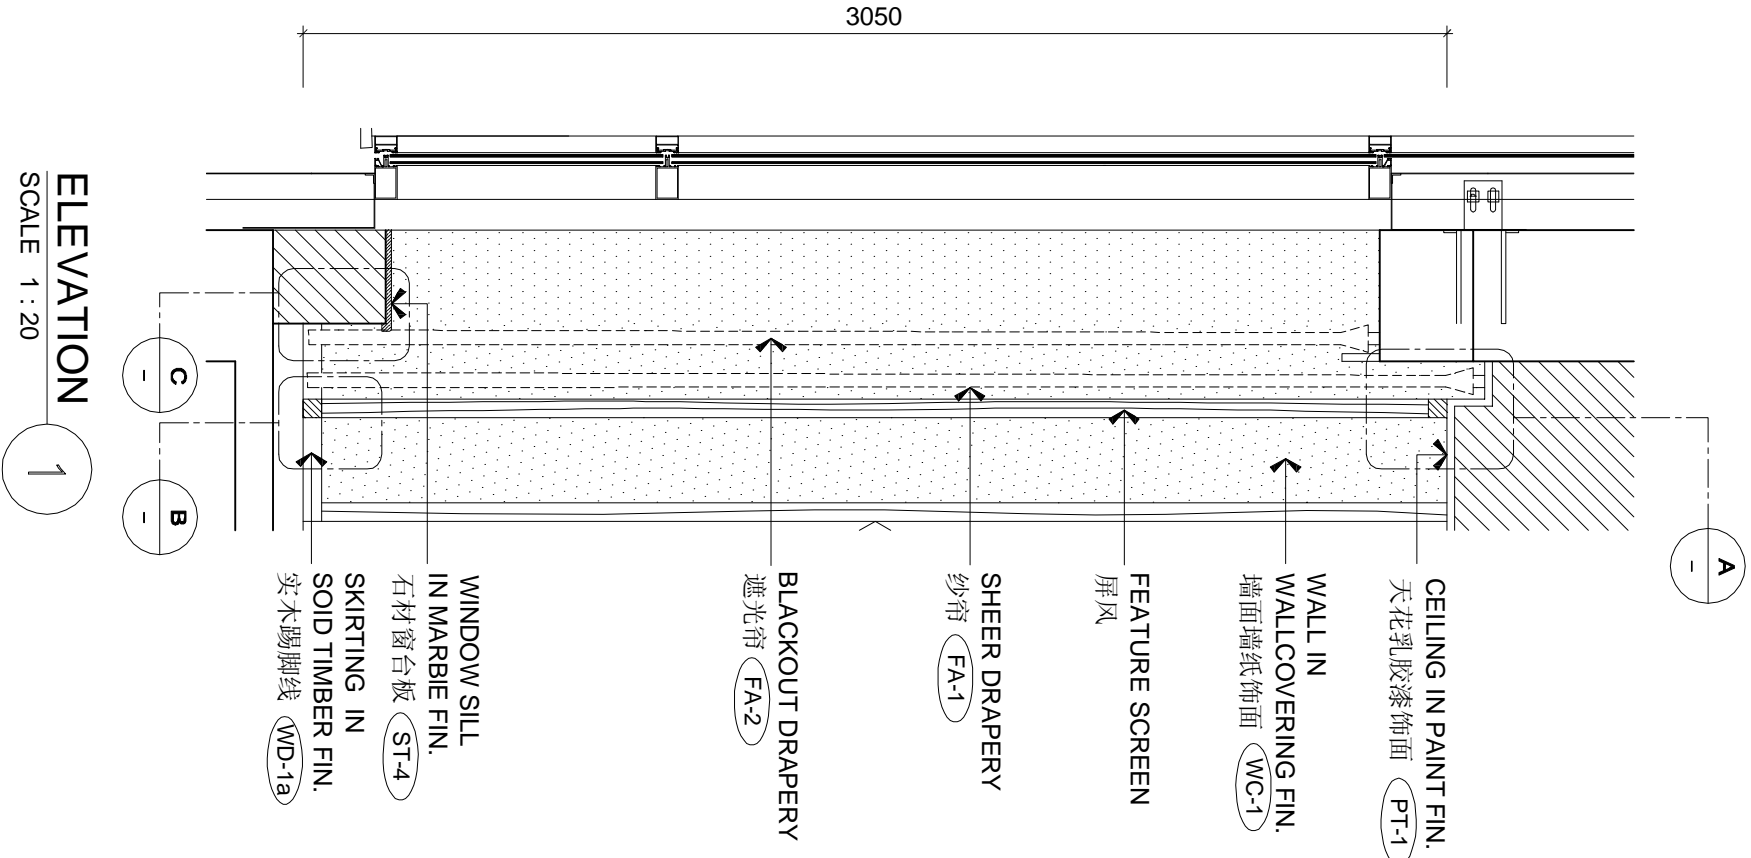

 


PDF 文件使用 "pdfFactory Pro" 试用版本创建 www.fineprint.com.cn


REVISIONS AND ISSUES				CHHADA SIEMBIEDA LEUNG				THE INTERCONTINENTAL SUZHOU				3 BAYS SUITE ROOM - DETAILS				DWG. NO.	
LOCATION OF REVISIONS ARE INDICATED ON DWG. AS				Limited, Design Consultants Hong Kong												FD-3BS-10	
ISSUED FOR TENDER DRAWING																	
DATE				200408													
1				2				3				4				5	
2				3				4				5				6	
3				4				5				6				7	
214				215				216				217				218	
215				216				217</									

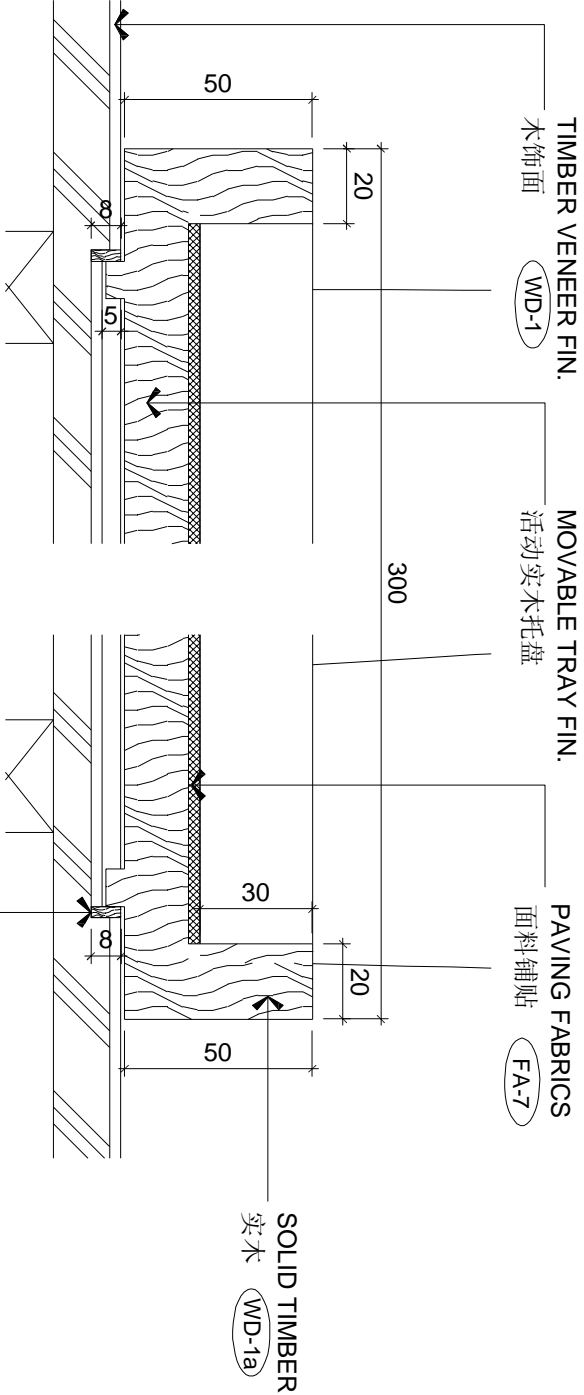


DETAIL A
SCALE 1 : 2

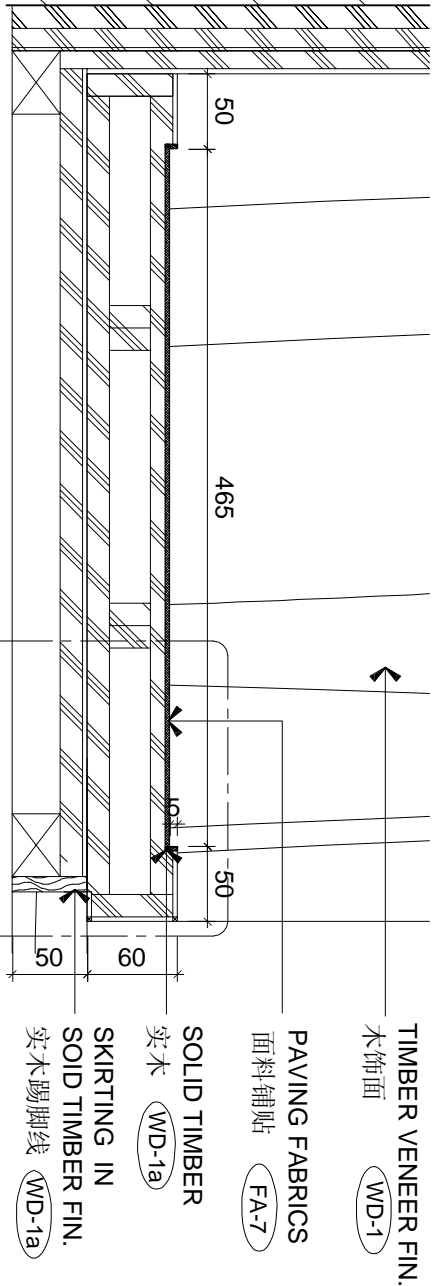

DETAIL B
SCALE 1 : 5




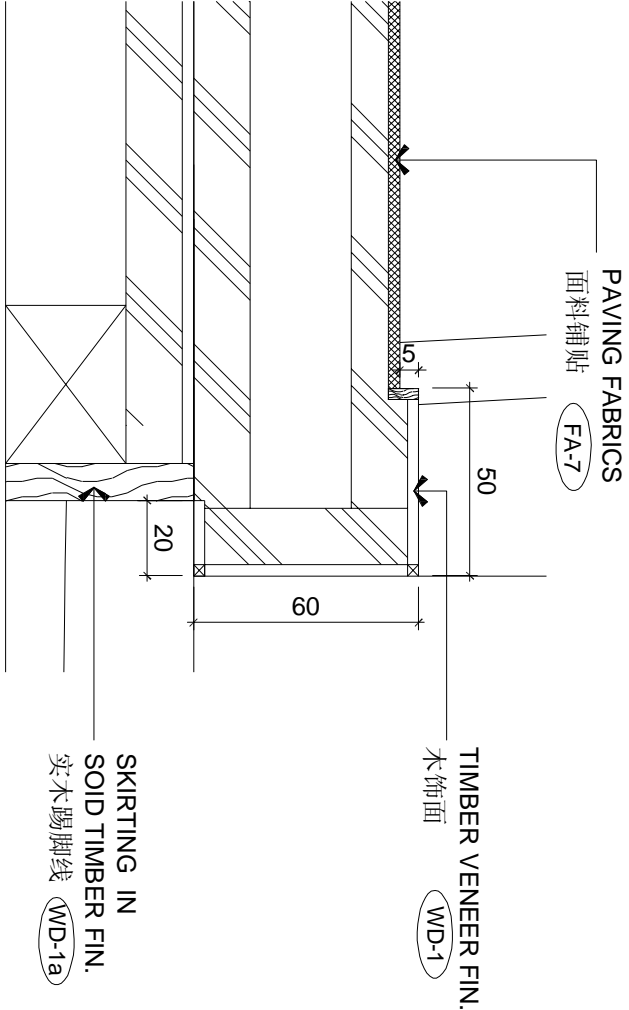





DETAIL D
SCALE 1 : 2

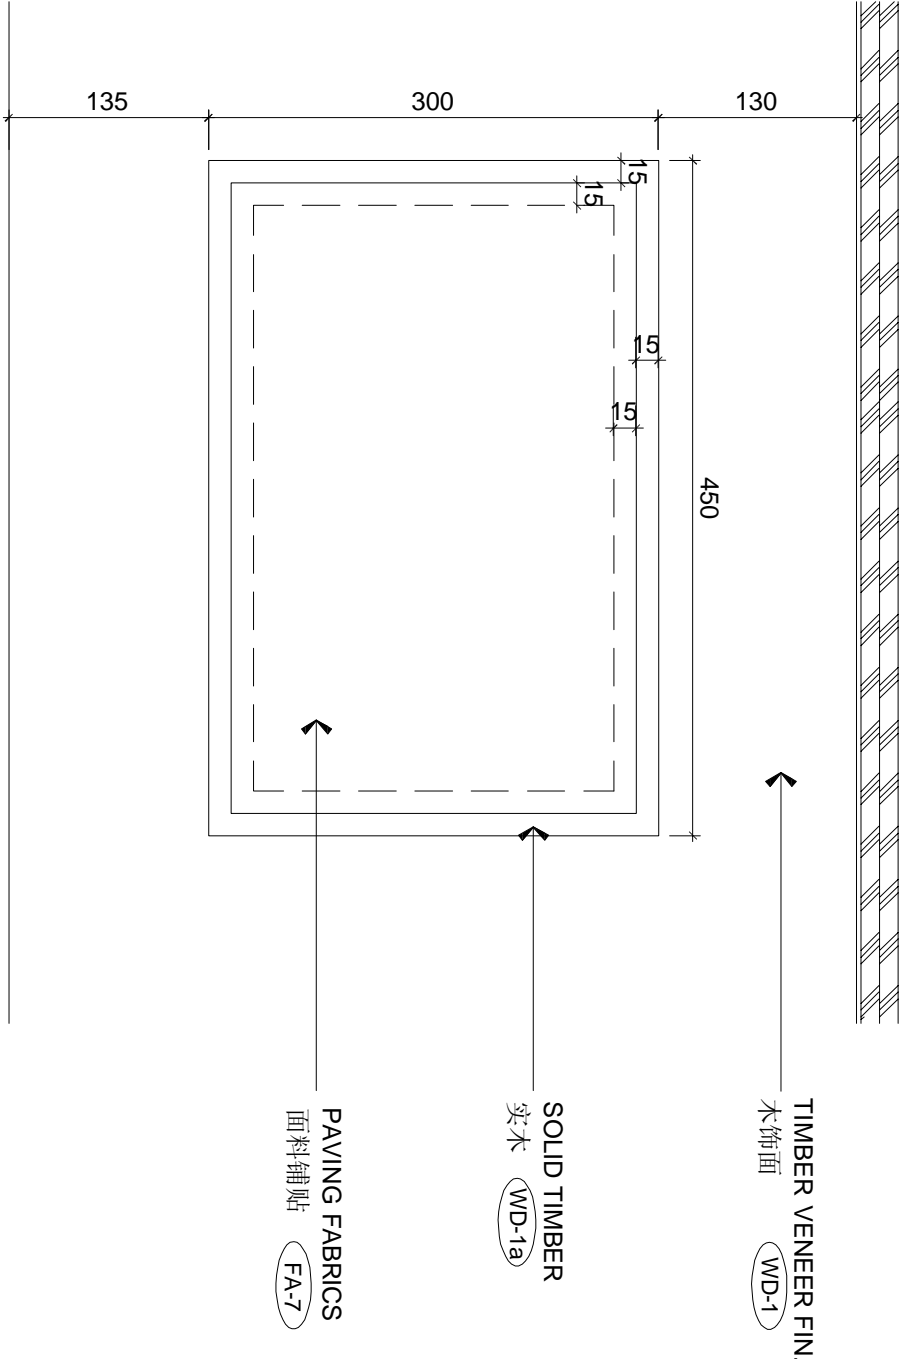

DETAIL C
SCALE 1 : 5




REVISIONS AND ISSUES				CHHADA SIEMBIEDA LEUNG				THE INTERCONTINENTAL SUZHOU				3 BAYS SUITE ROOM - DETAILS				DWG. NO. FD-3BS-11	
LOCATION OF REVISIONS ARE INDICATED ON DWG. AS				Limited, Design Consultants Hong Kong				JIANGSU, CHINA				DATE					
ISSUED FOR TENDER DRAWING												DRAWN BY					
												STEPHEN					
												APPROVED BY					
1				200408													
2																	
3																	
4																	
100																	

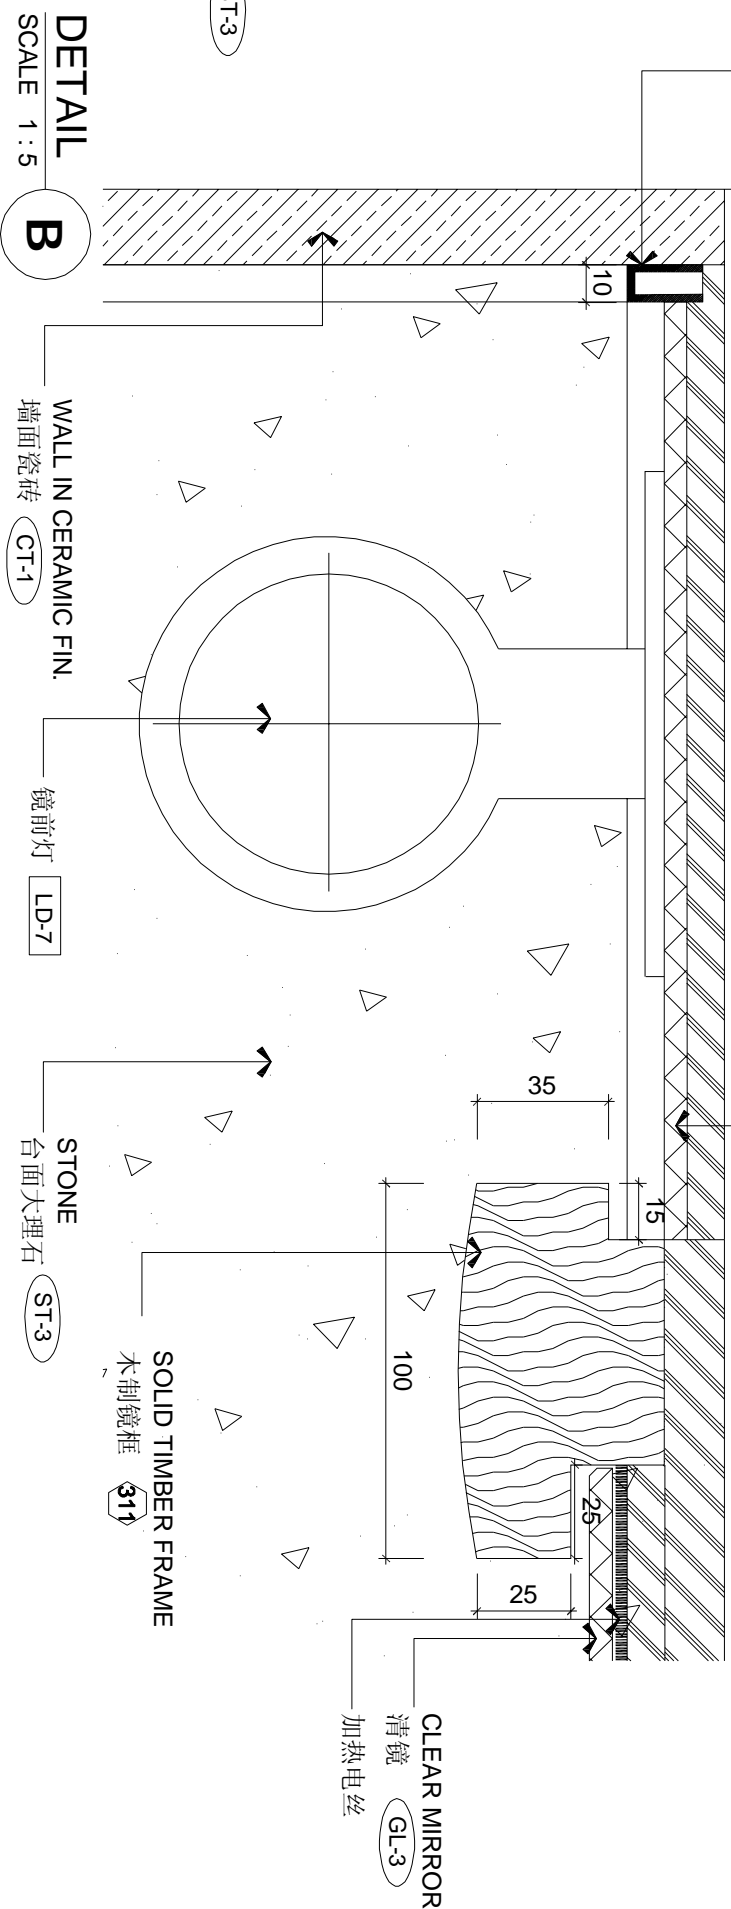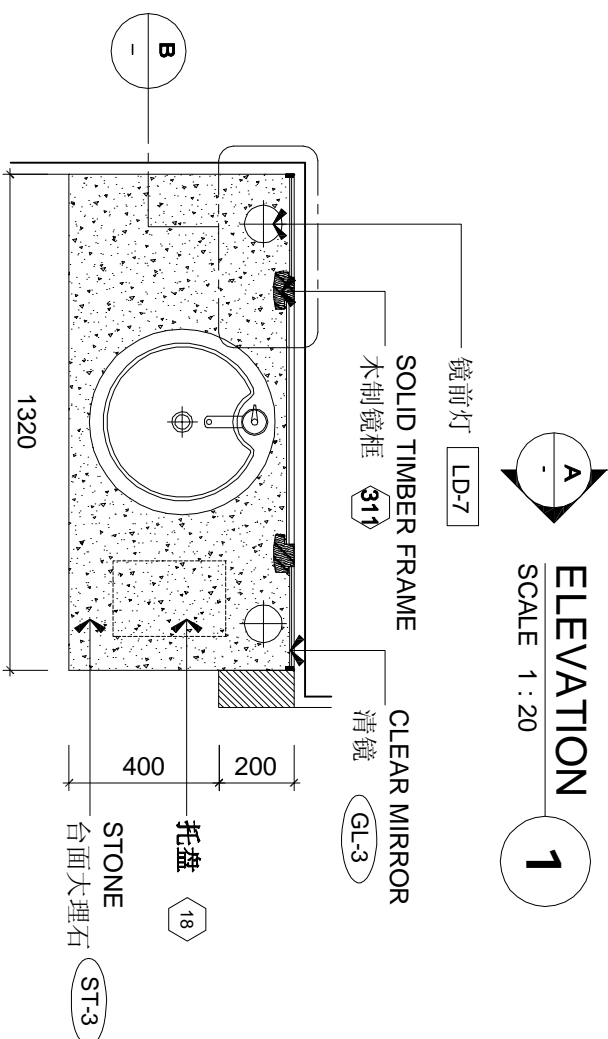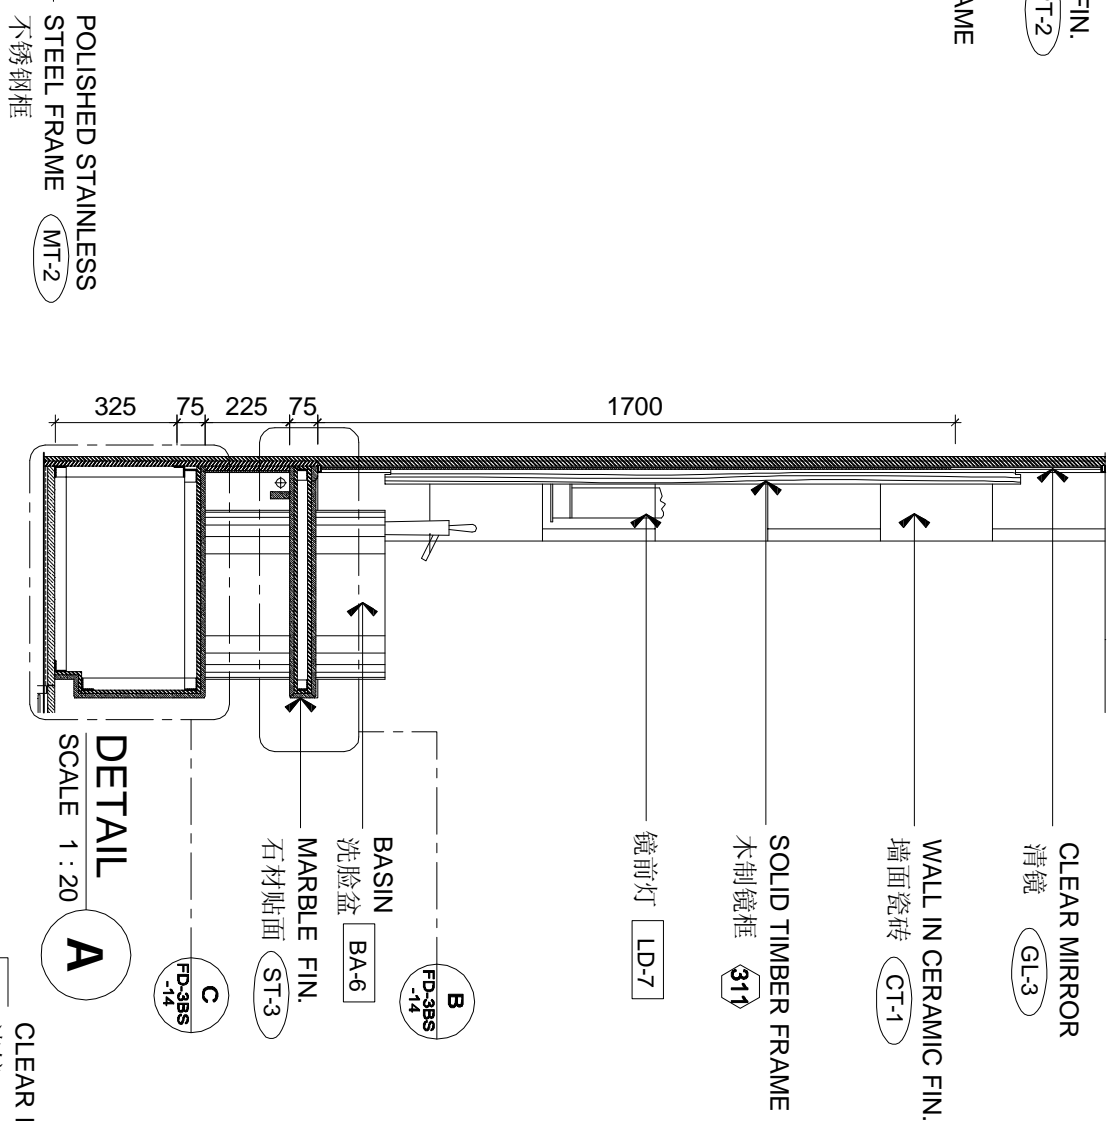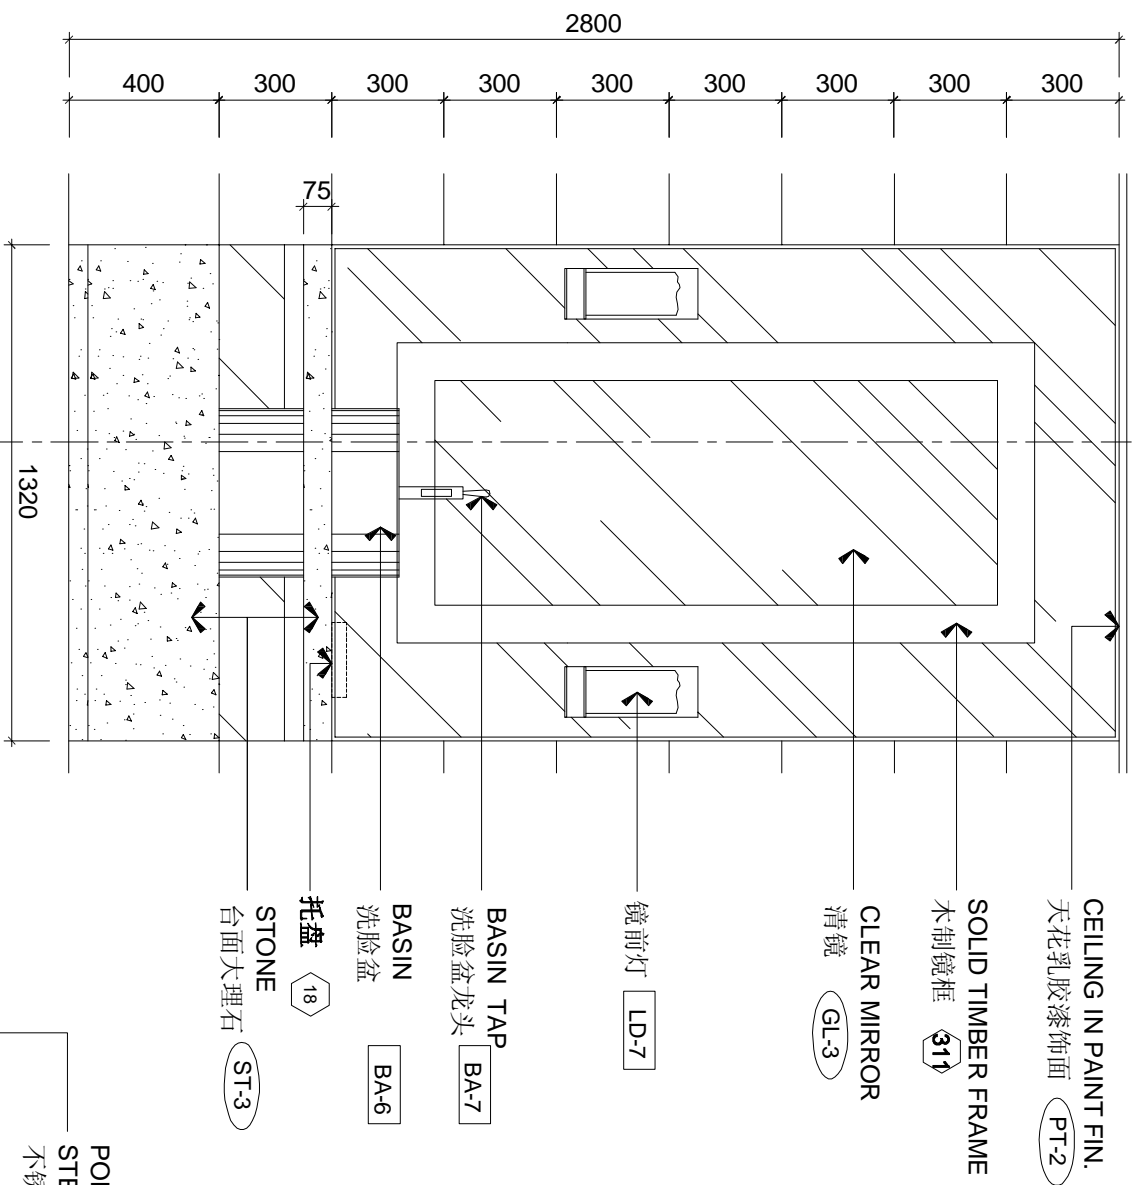
[illegible]

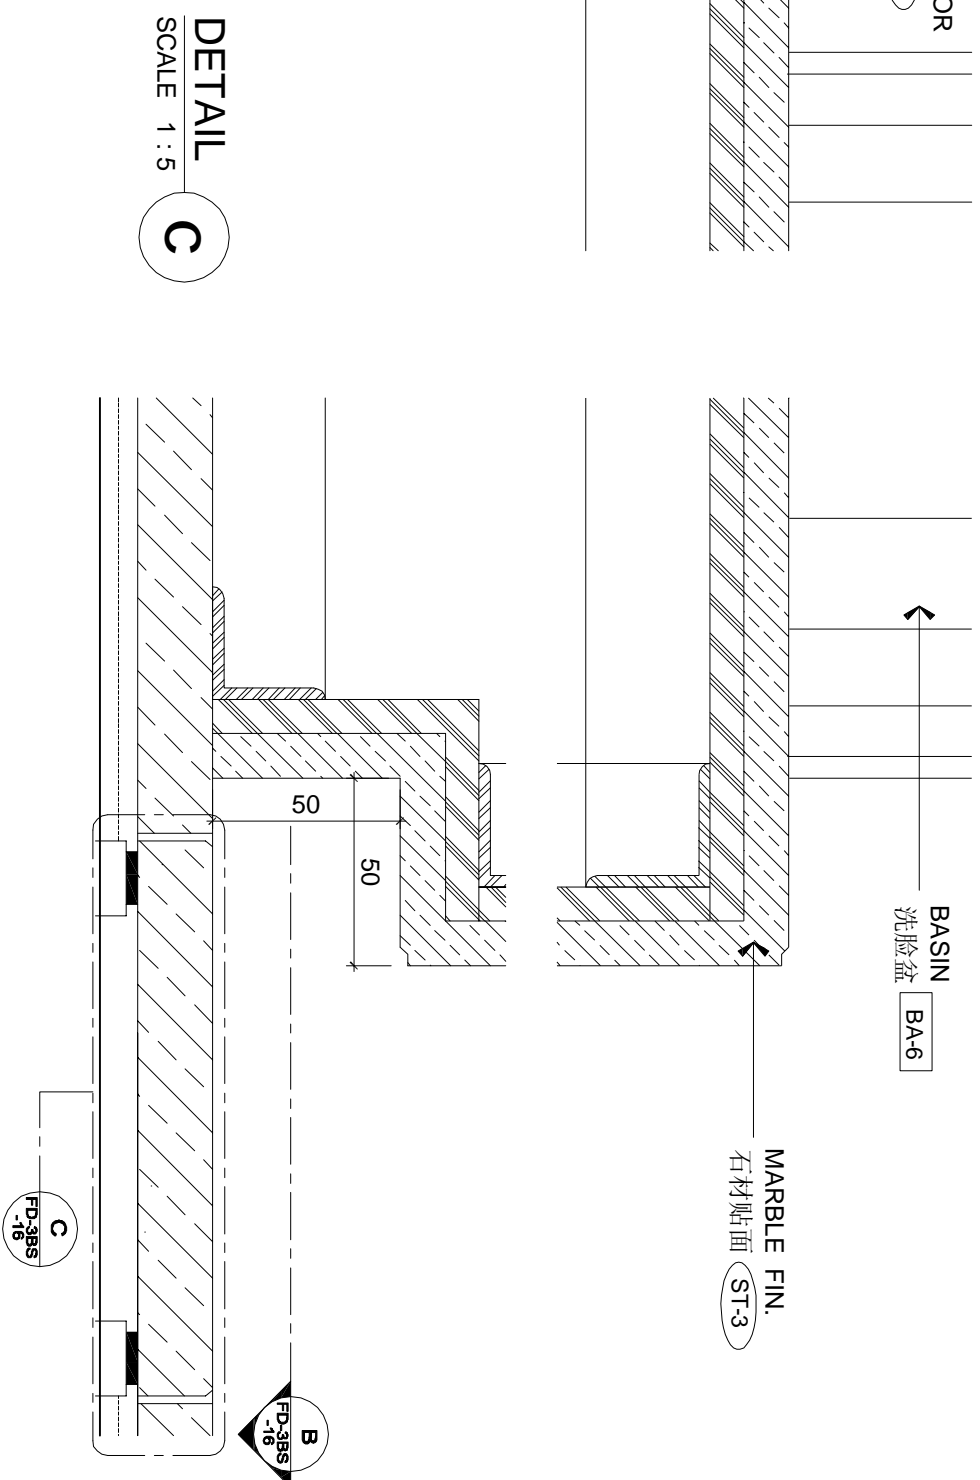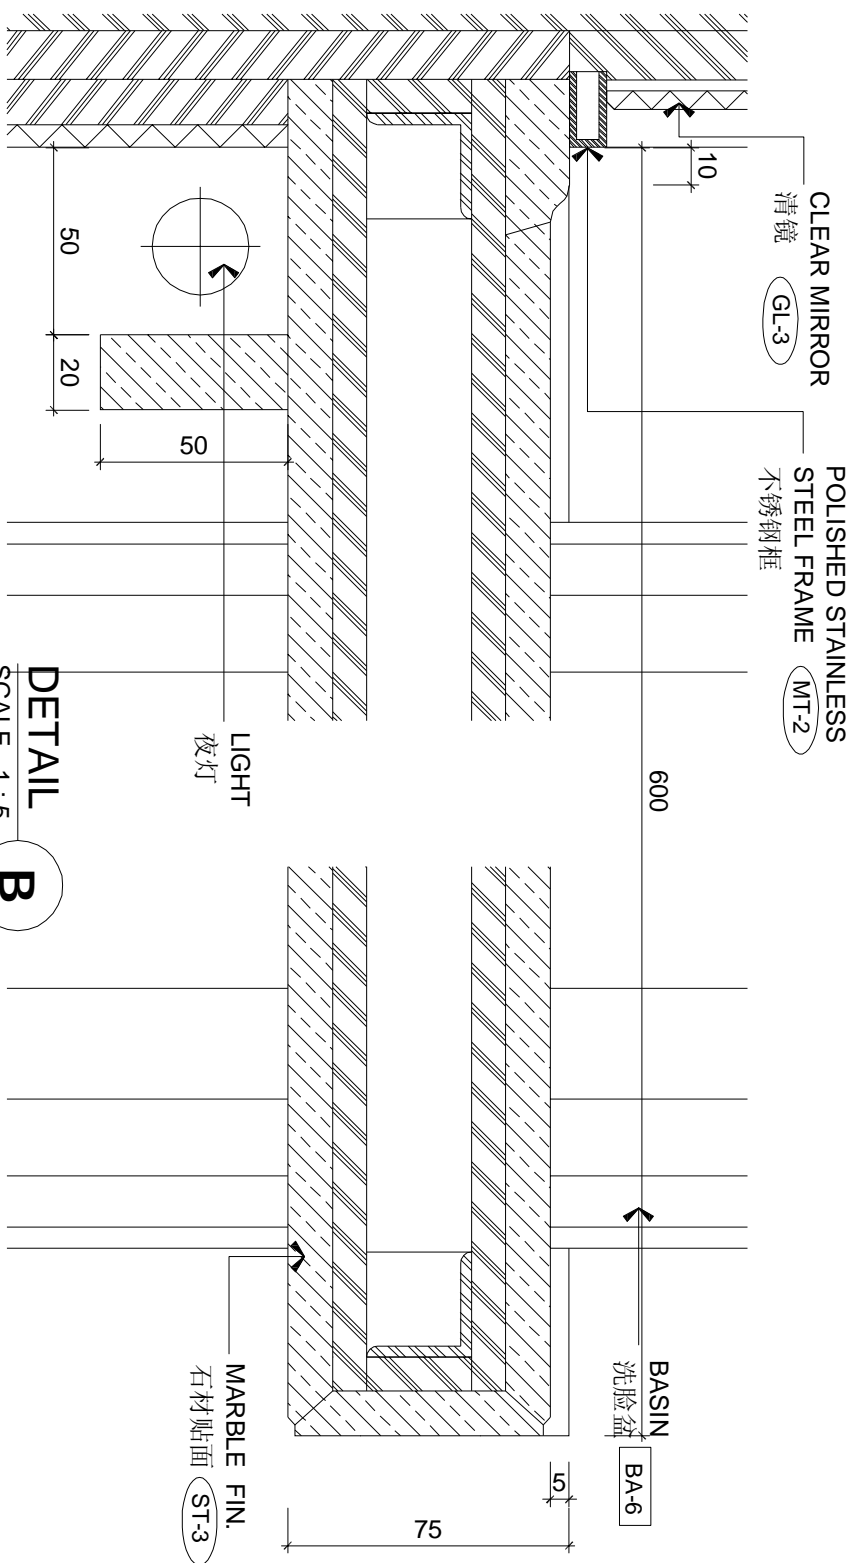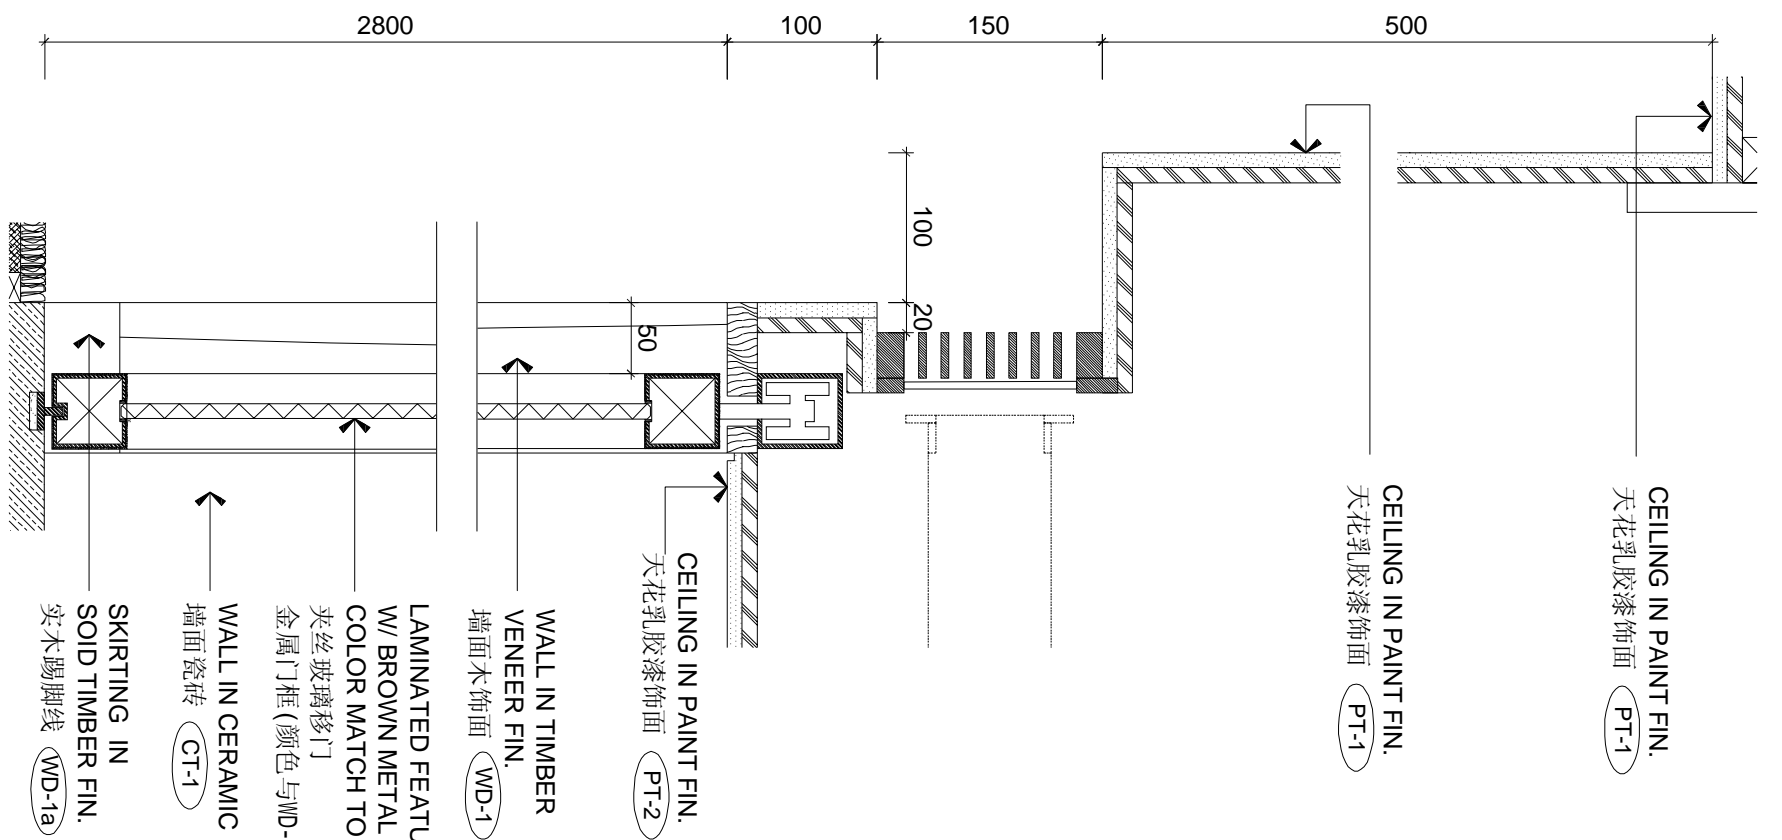

REVISIONS AND ISSUES		DATE						DWG. NO.	
LOCATION OF REVISIONS ARE INDICATED ON DWG. AS		24/06/08						FD-3BS-14	
1	ISSUED FOR TENDER DRAWING	1		2					
2		3		4					
3		5		6					
4		7		8					
231		461		462					


REVISIONS AND ISSUES				CHHADA SIEMBIEDA LEUNG				THE INTERCONTINENTAL SUZHOU				3 BAYS SUITE ROOM - DETAILS				DWG. NO.	
LOCATION OF REVISIONS ARE INDICATED ON DWG. AS				Limited, Design Consultants Hong Kong				JIANGSU, CHINA				DATE				4/28/09	
ISSUED FOR TENDER DRAWING												DRAWN BY				STEPHEN	
												SCALE				AS SHOWN (A3)	
												PROJECT NO.				07-01	
												FILE NAME				FD-3BS-15	
																REVISION	

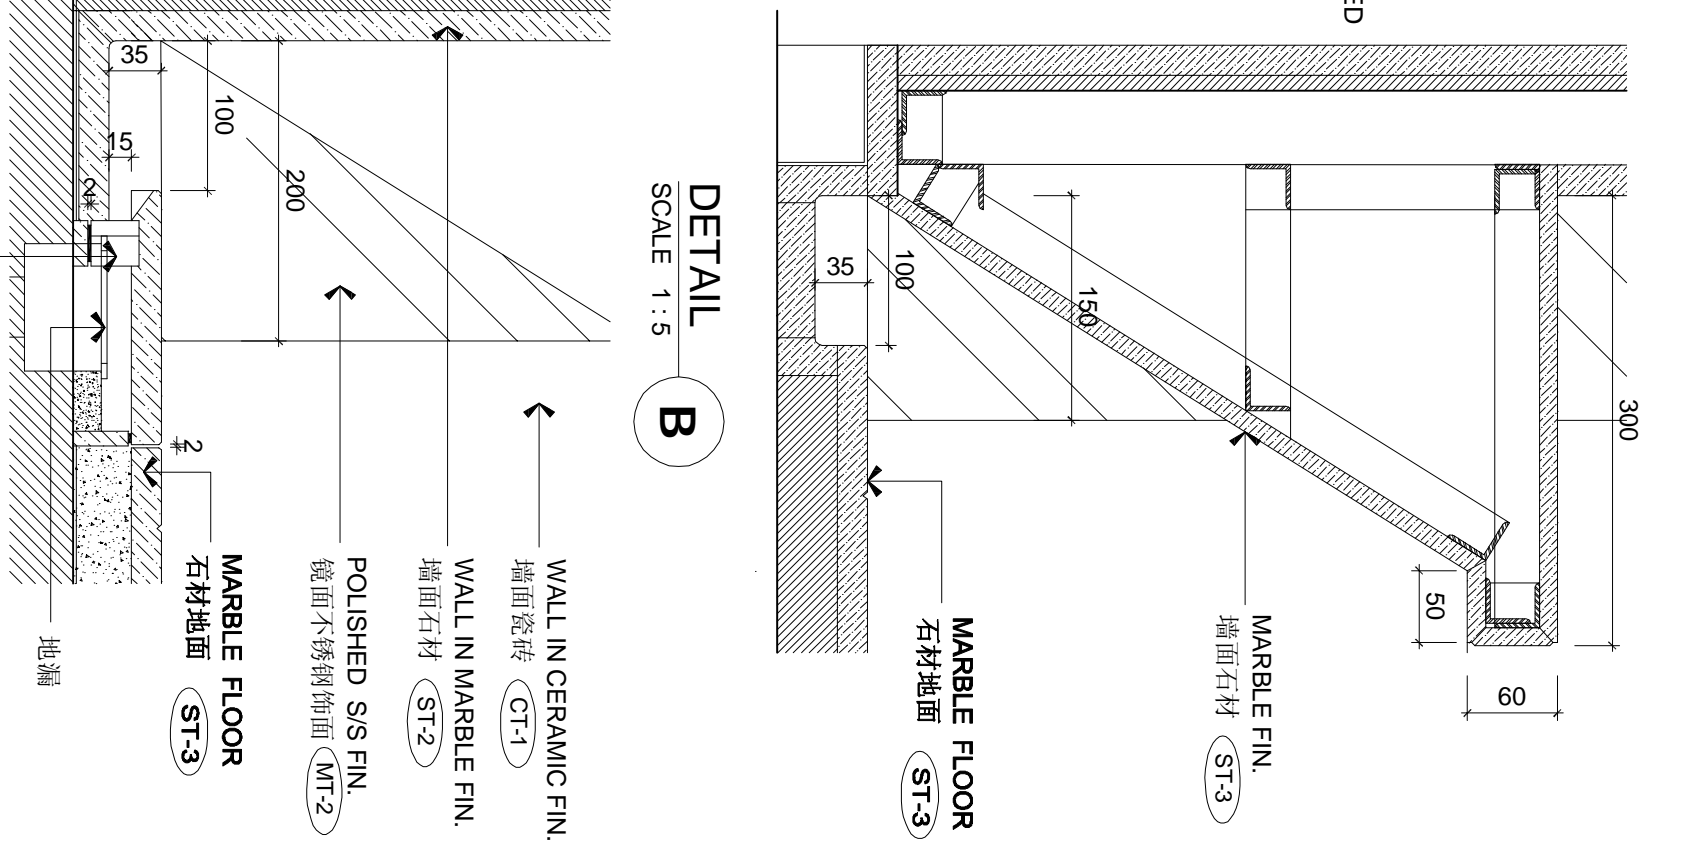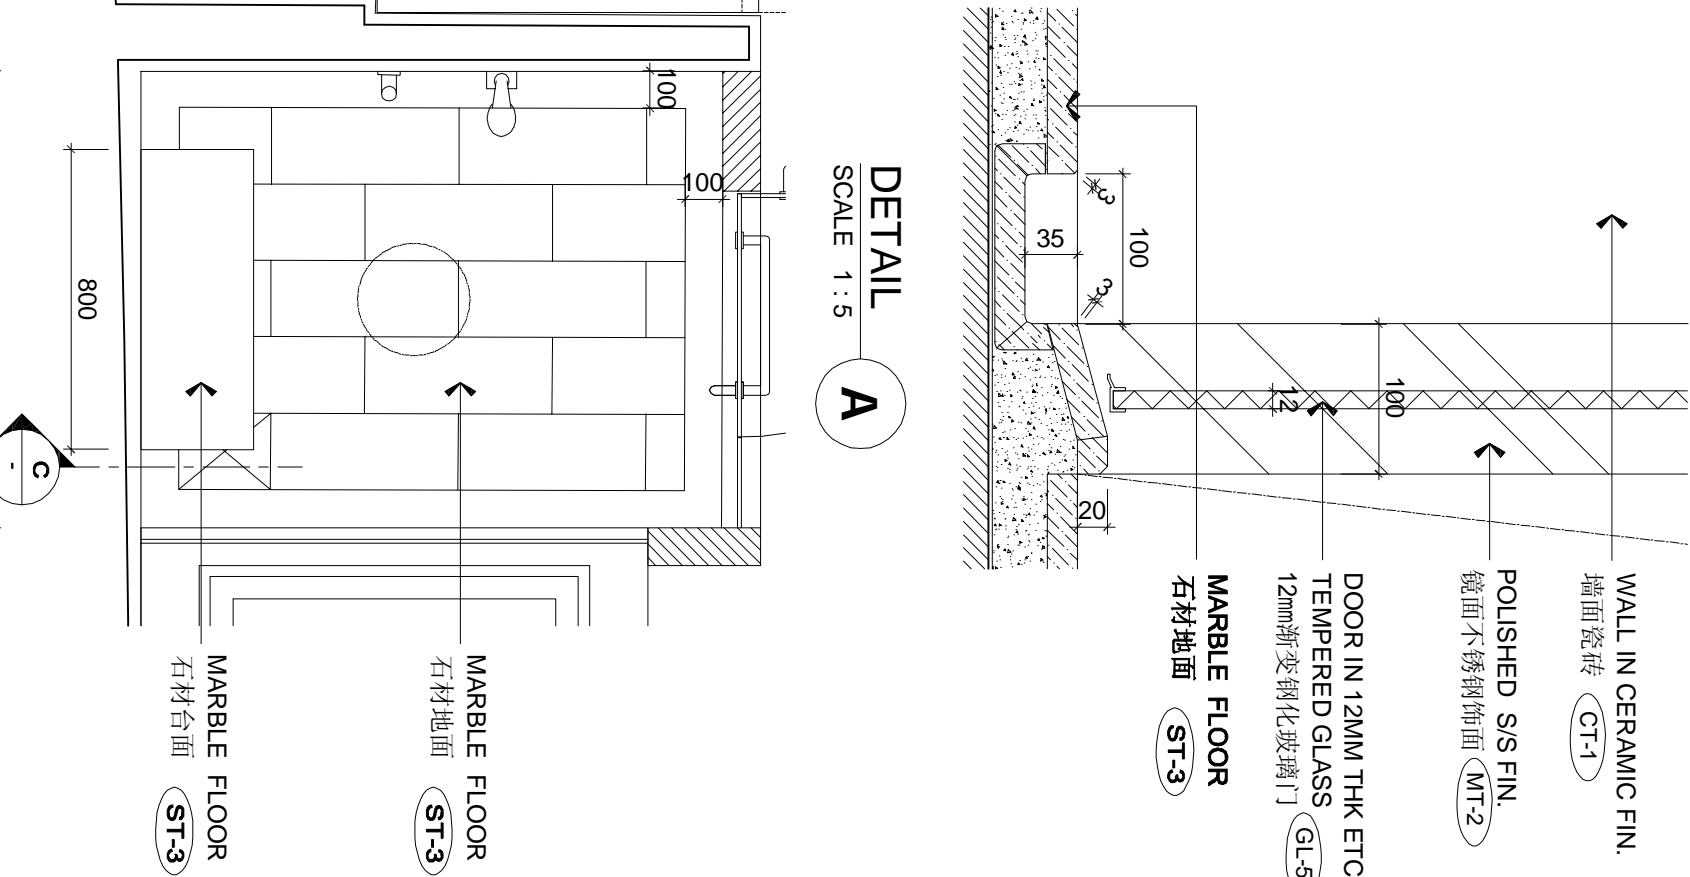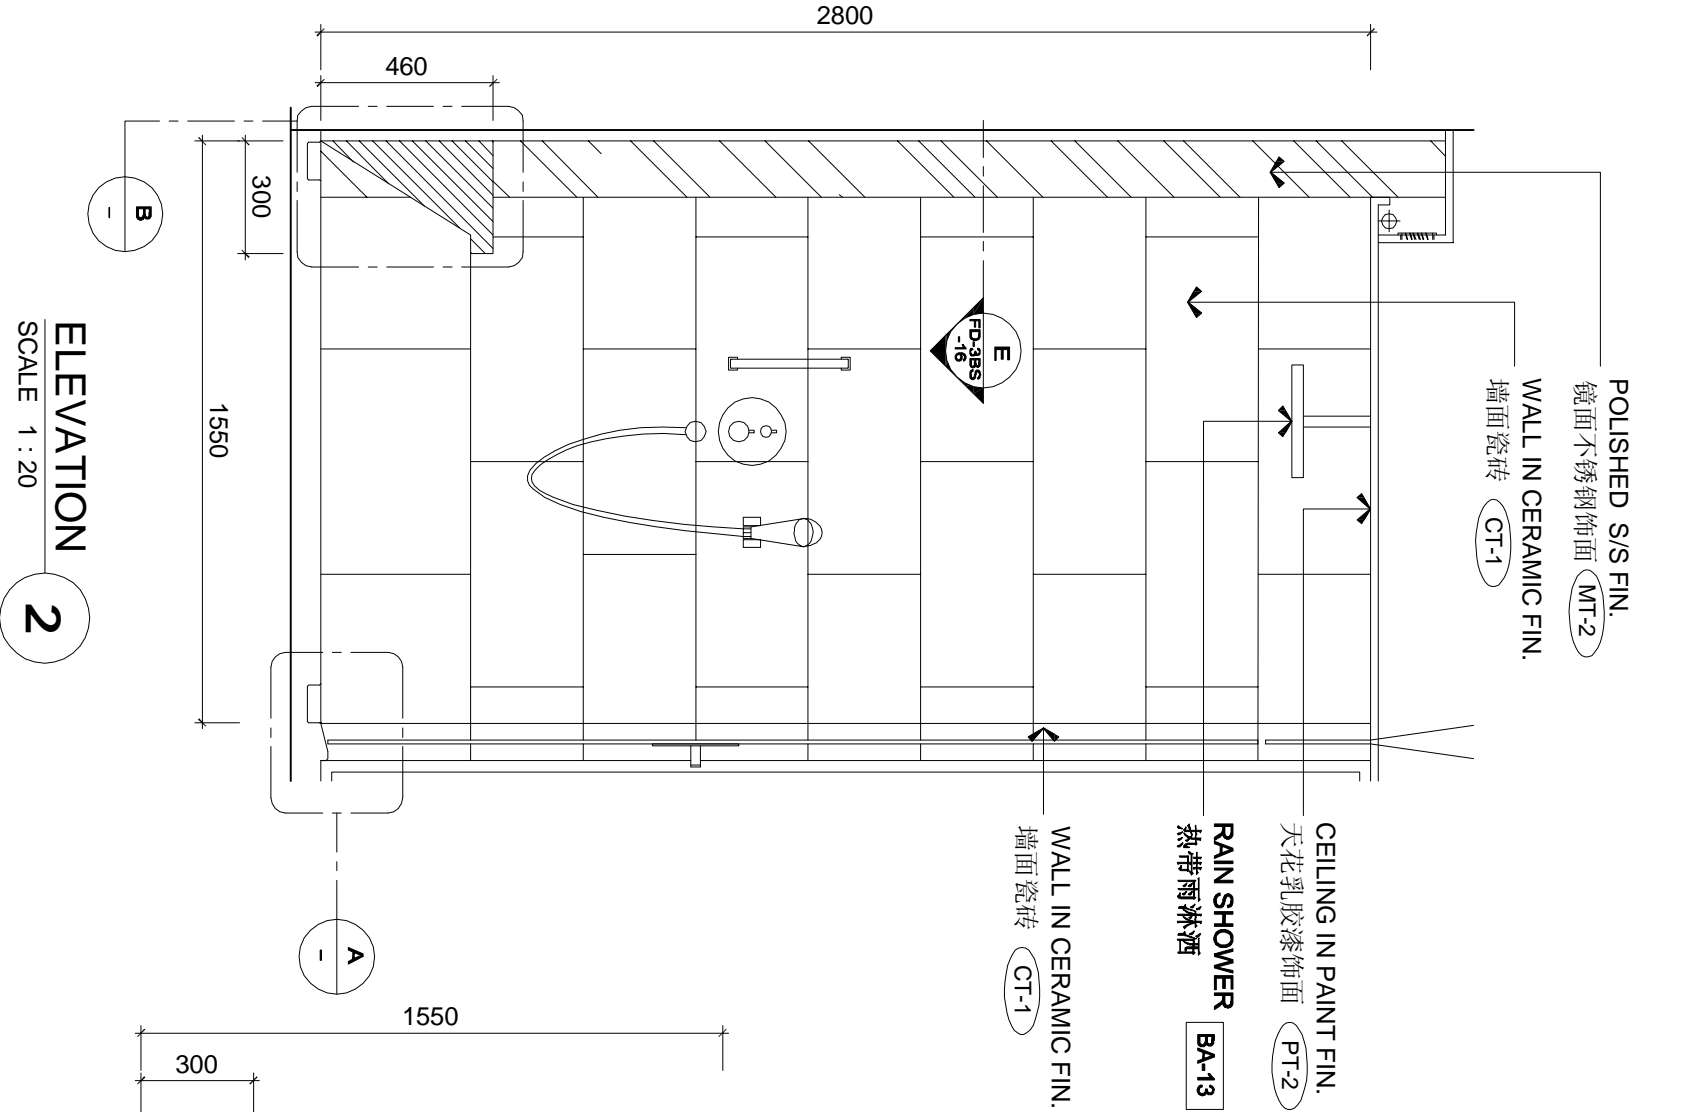

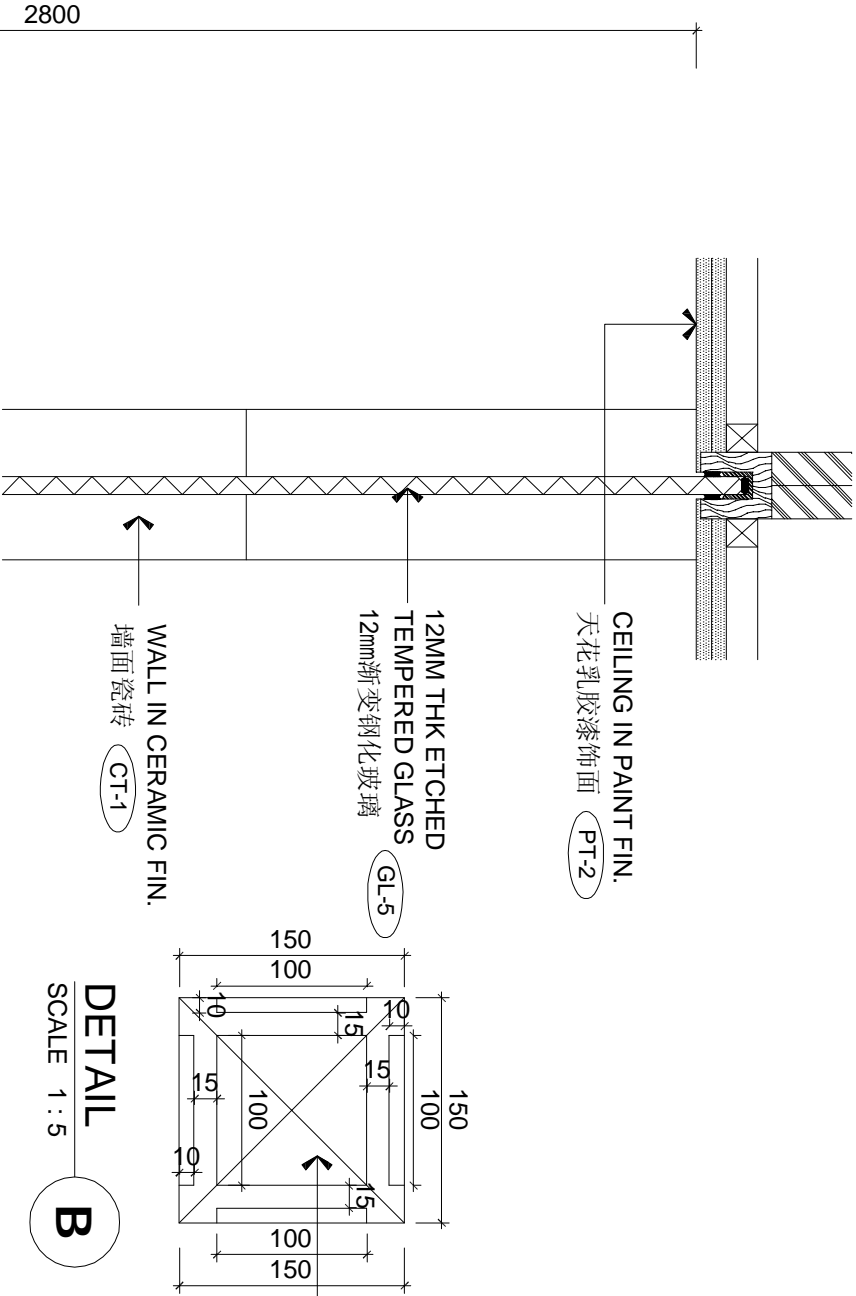


DETAIL
SCALE 1 : 5

B

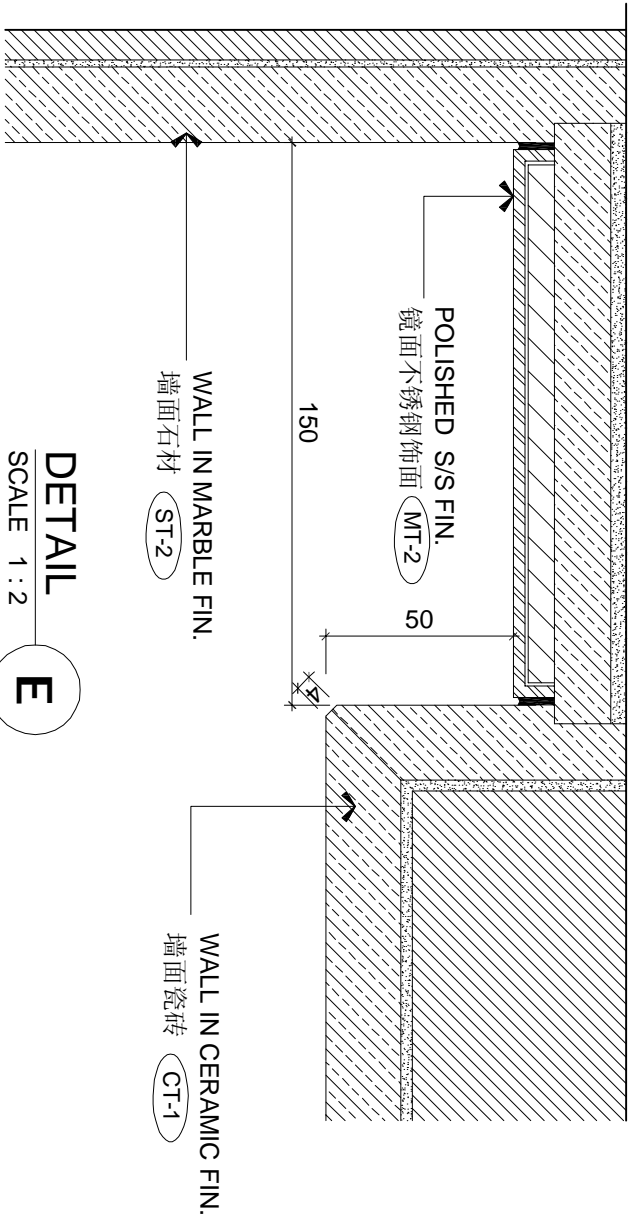


DETAIL
SCALE 1 : 2

E

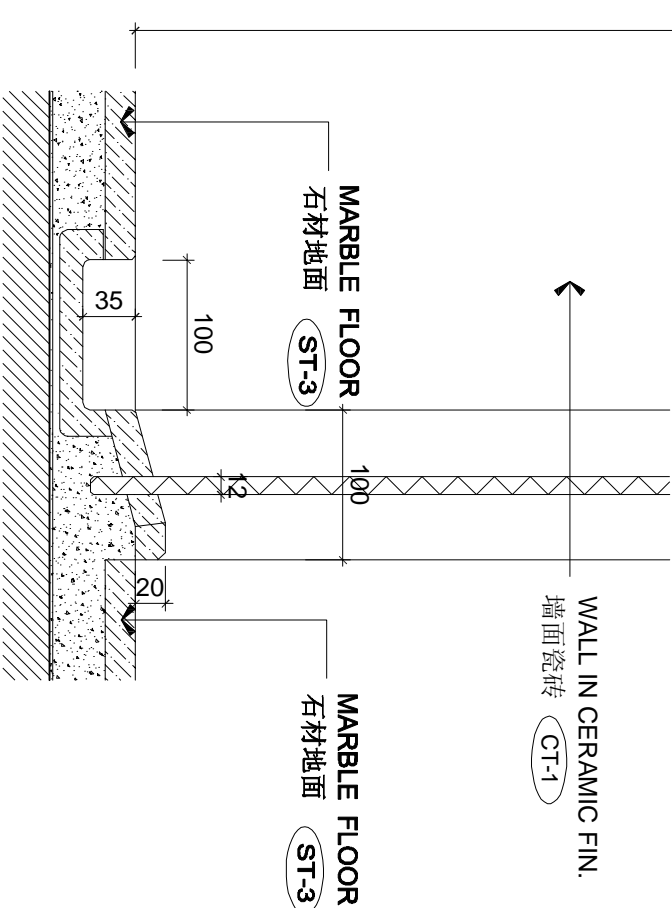


DETAIL
SCALE 1 : 5

A

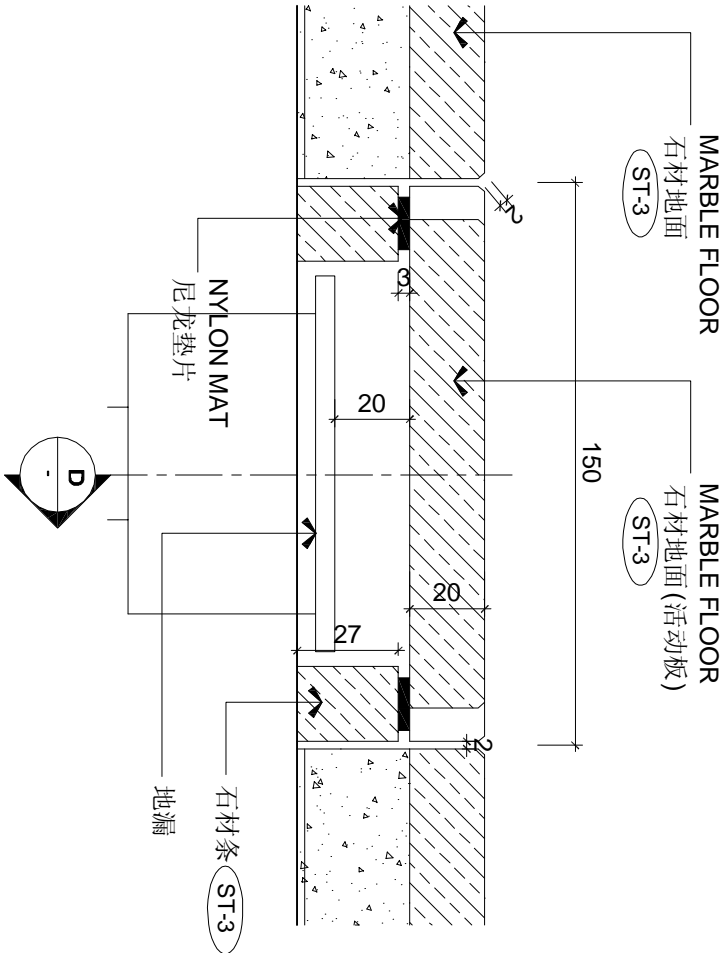

DETAIL
SCALE 1 : 2

C


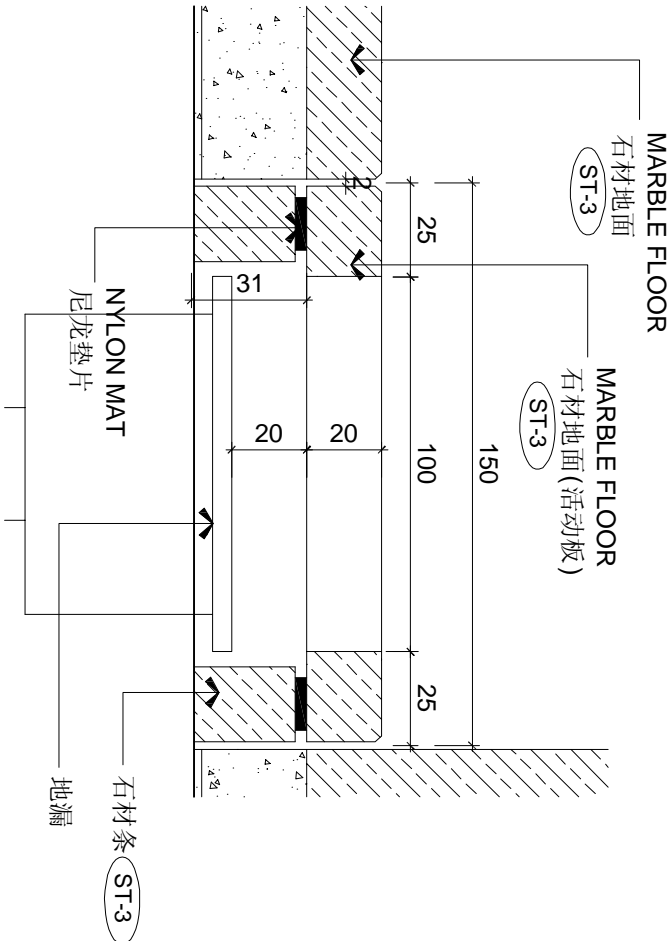


DETAIL
SCALE 1 : 2

D



REVISIONS AND ISSUES										CHHADA SIEMBIEDA LEUNG										THE INTERCONTINENTAL SUZHOU										3 BAYS SUITE ROOM - DETAILS										DWG. NO.									
LOCATION OF REVISIONS ARE INDICATED ON DWG. AS										Limited, Design Consultants Hong Kong																														FD-3BS-16									
ISSUED FOR TENDER DRAWING																																								PROJECT NO.									
24/04/18																																								07-01									
																																								APPROVED BY									
																																								REVISION									

REVISIONS AND ISSUES				CHHADA SIEMBIEDA LEUNG				DWG. NO.	
LOCATION OF REVISIONS ARE INDICATED ON DWG. AS				Limited, Design Consultants Hong Kong				FD-3BS-17	
ISSUED FOR TENDER DRAWING				THE INTERCONTINENTAL SUZHOU				3 BAYS SUITE ROOM - DETAILS	
				JIANGSU, CHINA					

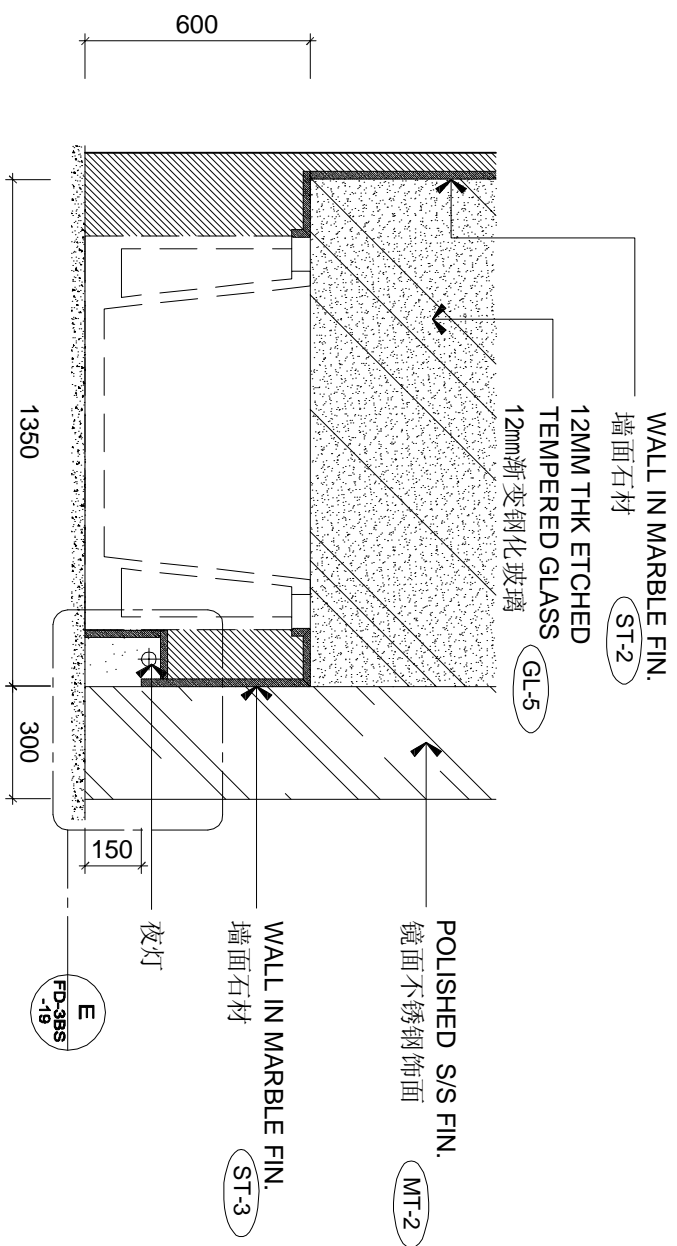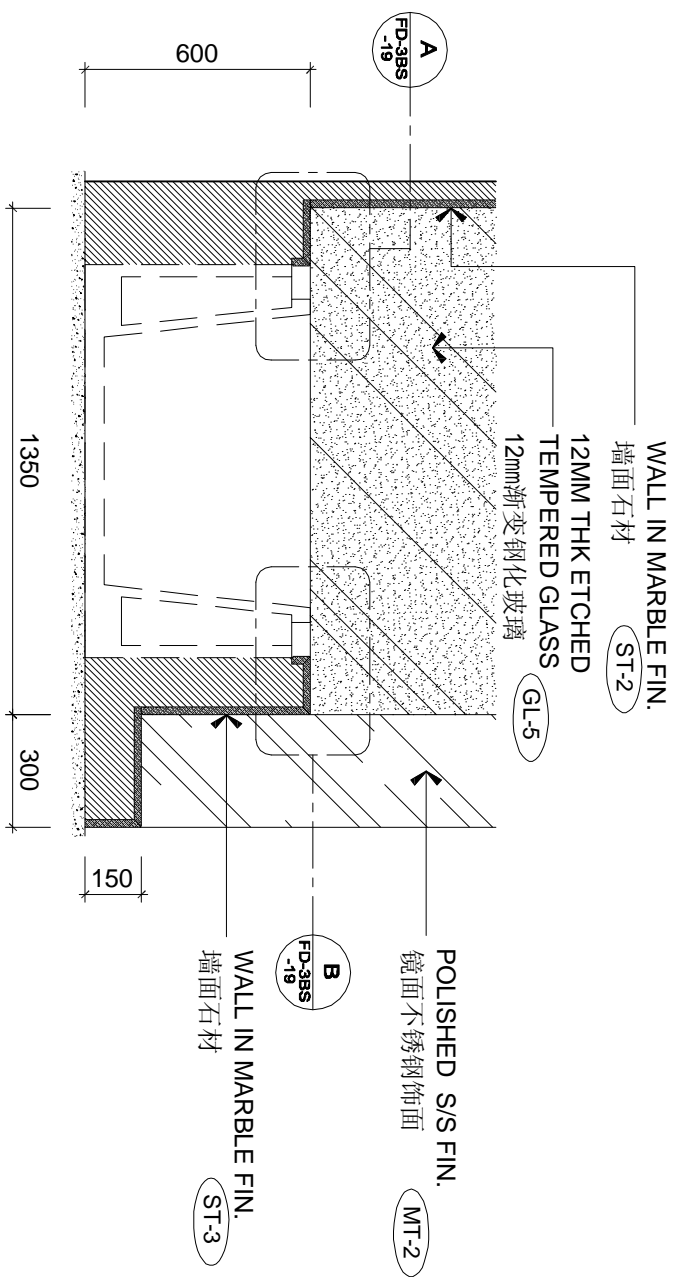

DETAIL
SCALE 1 : 20


A

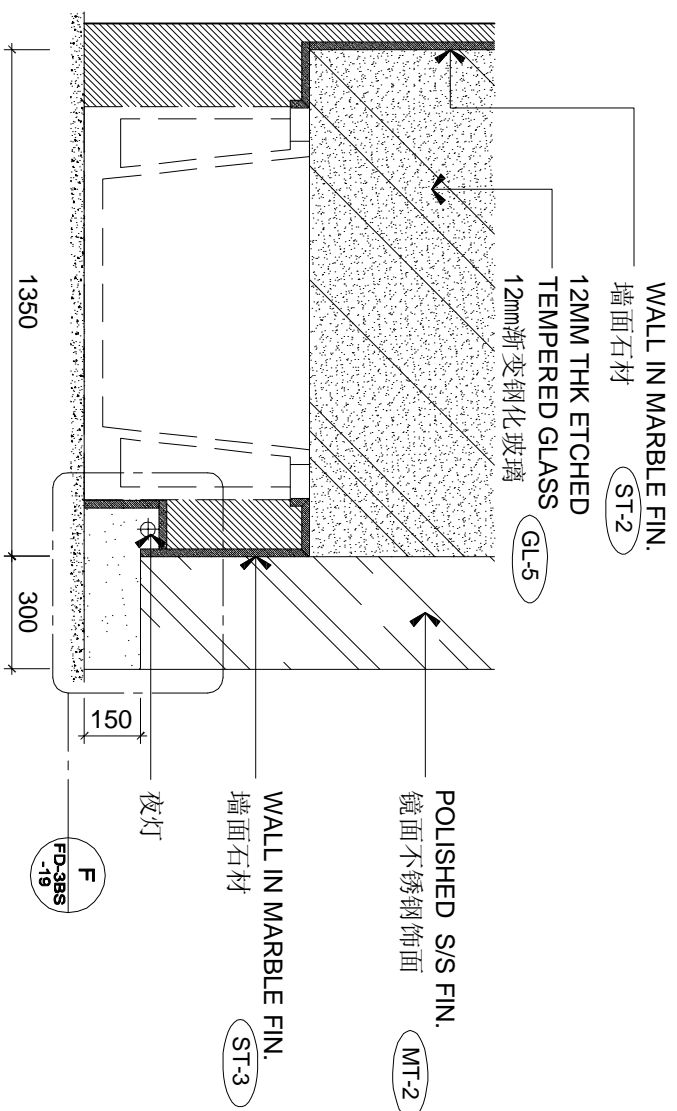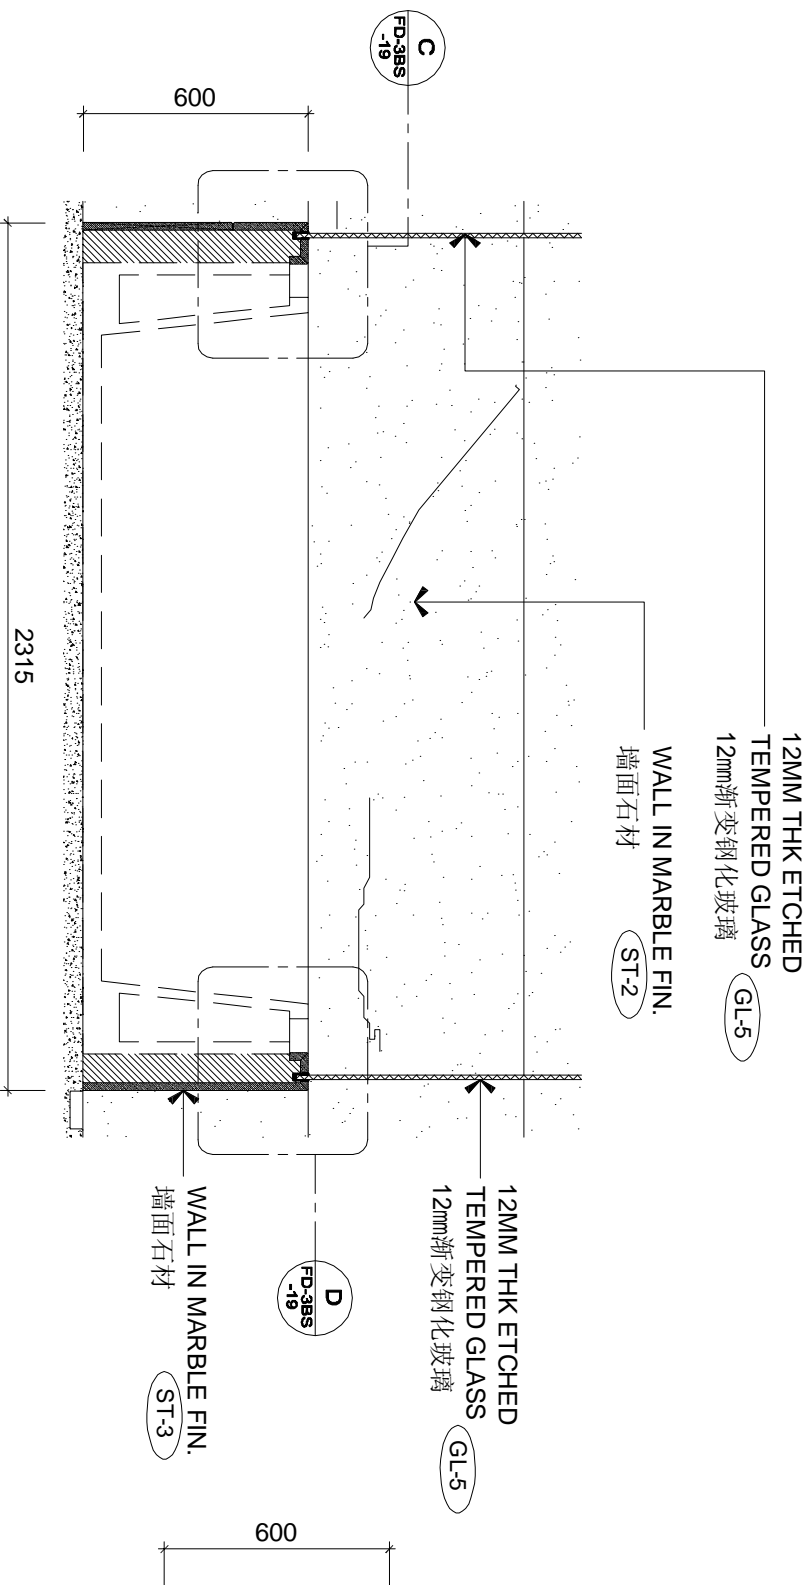

DETAIL
SCALE 1 : 20

C

[illegible]

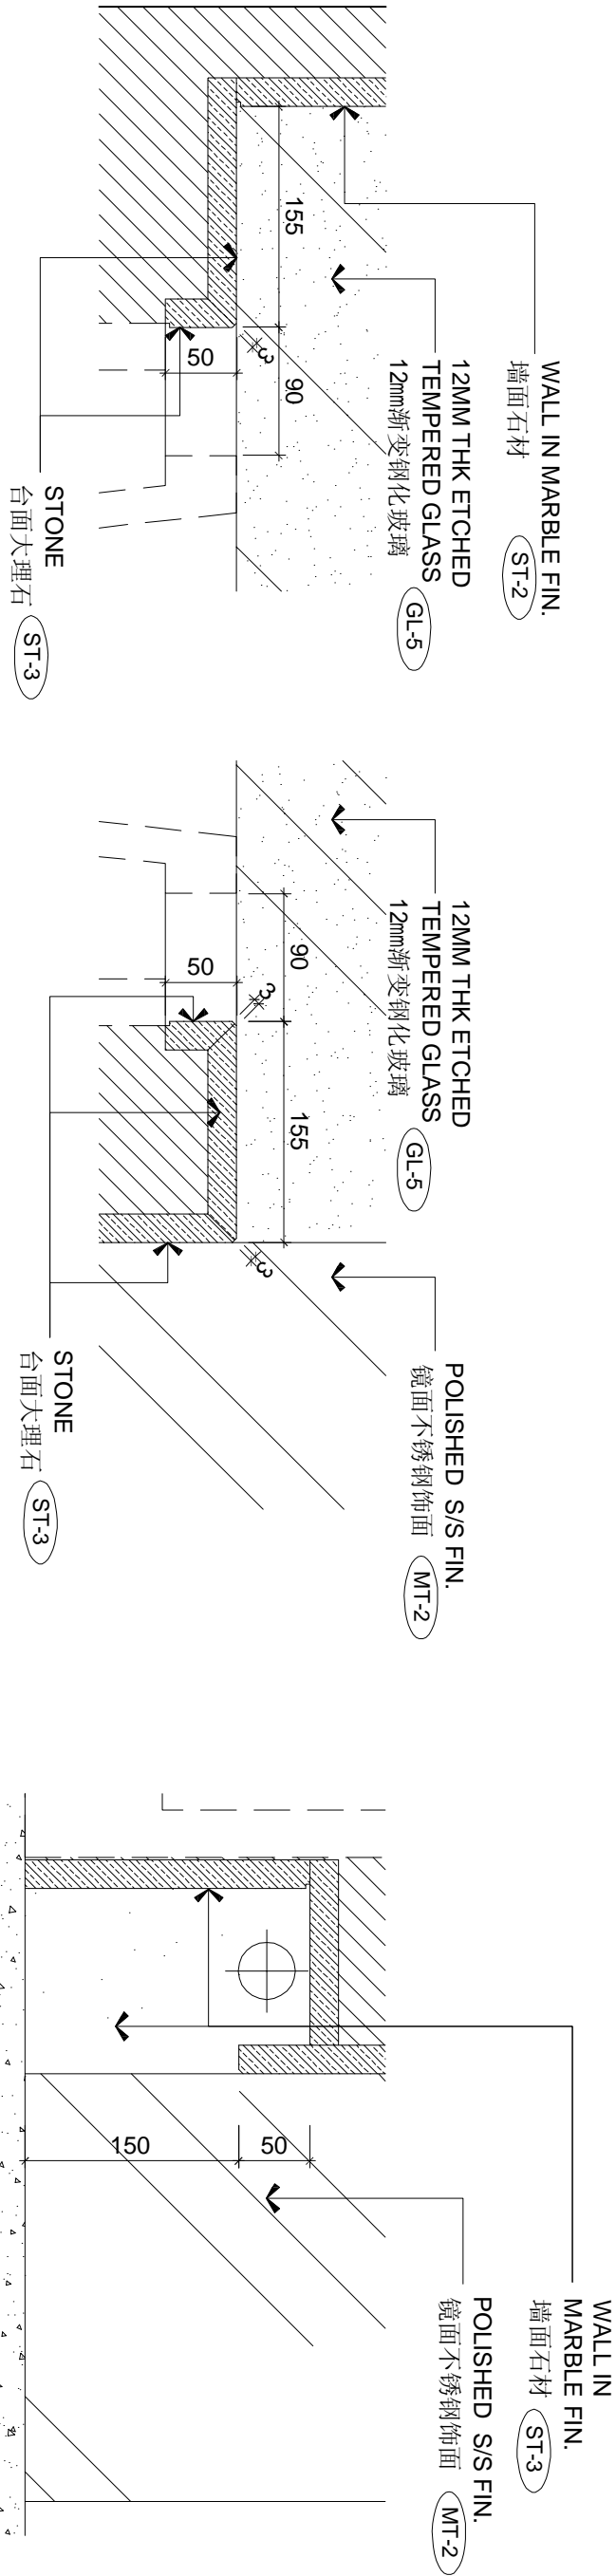

DETAIL
SCALE 1 : 5
A

DETAIL
SCALE 1 : 5
B

WALL IN MARBLE FIN.
墙面石材 (ST-2)

12MM THK ETCHED
TEMPERED GLASS (GL-5)
12mm渐变钢化玻璃

12MM THK ETCHED
TEMPERED GLASS (GL-5)
12mm渐变钢化玻璃

STONE
台面大理石 (ST-3)



WALL IN
MARBLE FIN.
墙面石材 (ST-3)









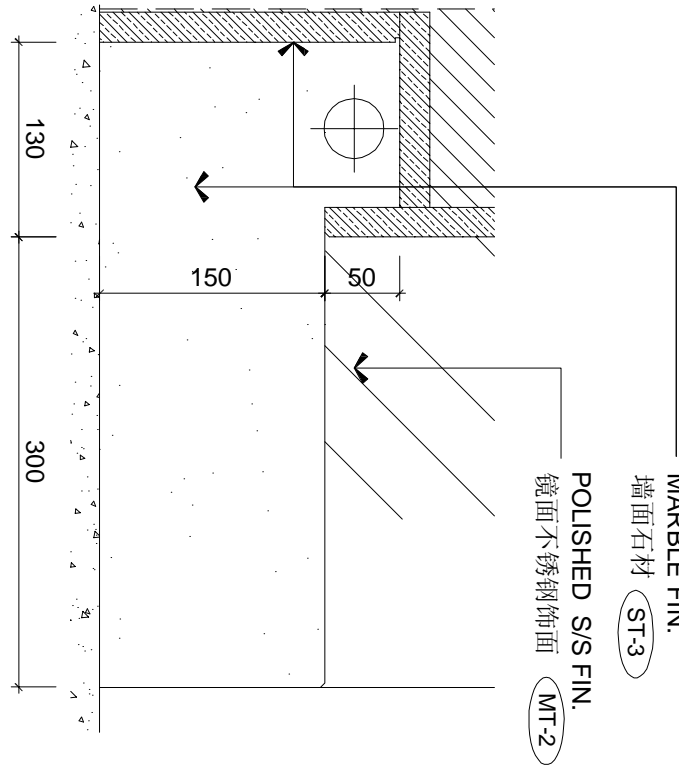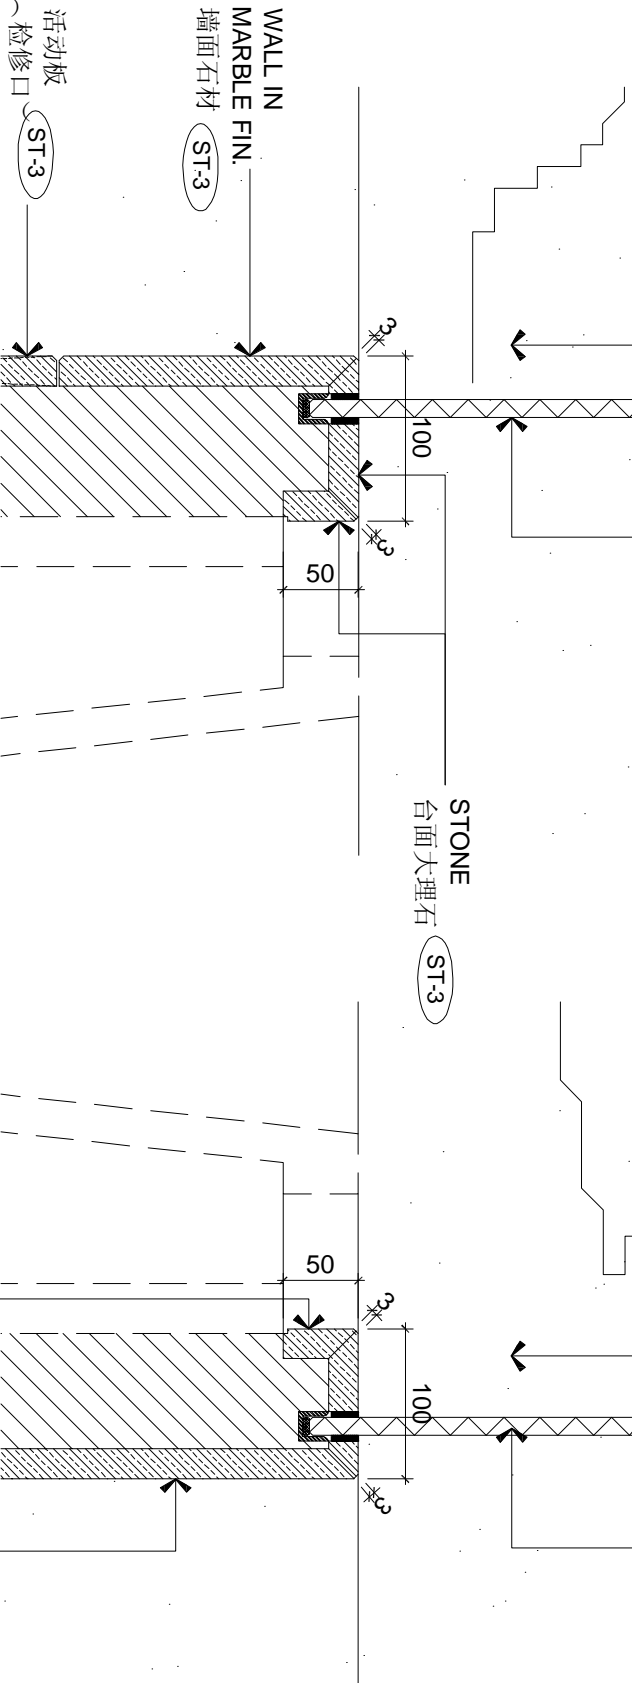
















WALL IN
MARBLE FIN.
墙面石材 (ST-3)
POLISHED S/S FIN.
镜面不锈钢饰面 (MT-2)


DETAIL
SCALE 1 : 5
C

DETAIL
SCALE 1 : 5
D

DETAIL
SCALE 1 : 5
F




REVISIONS AND ISSUES										CHHADA SIEMBIEDA LEUNG										THE INTERCONTINENTAL SUZHOU										3 BAYS SUITE ROOM - DETAILS										FD-3BS-19									
LOCATION OF REVISIONS ARE INDICATED ON DWG. AS 										Limited, Design Consultants Hong Kong										JIANGSU, CHINA										DATE										DWG. NO.									
ISSUED FOR TENDER DRAWING																														200609																			
																																																	
																																																	
																																																	
																																																	
																																																	

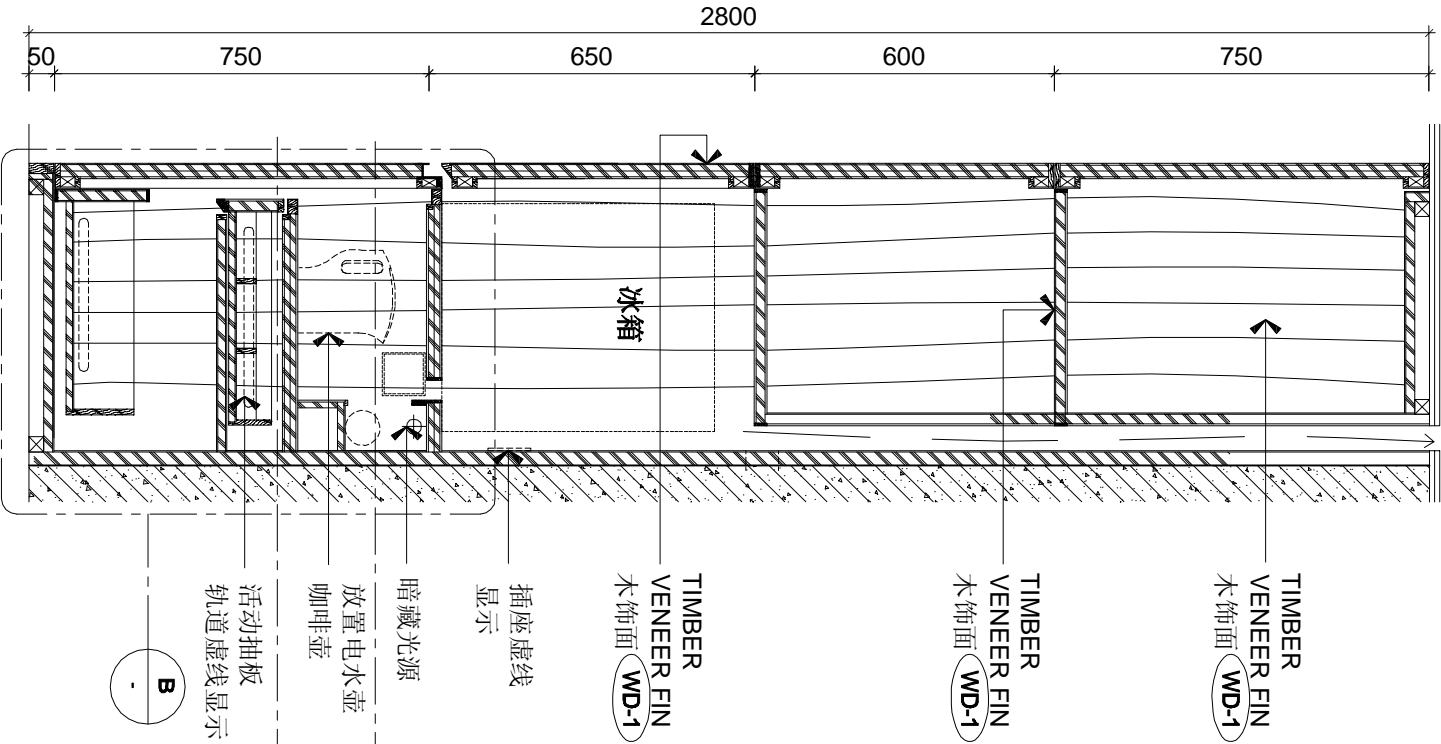


DETAIL
SCALE 1 : 15

A

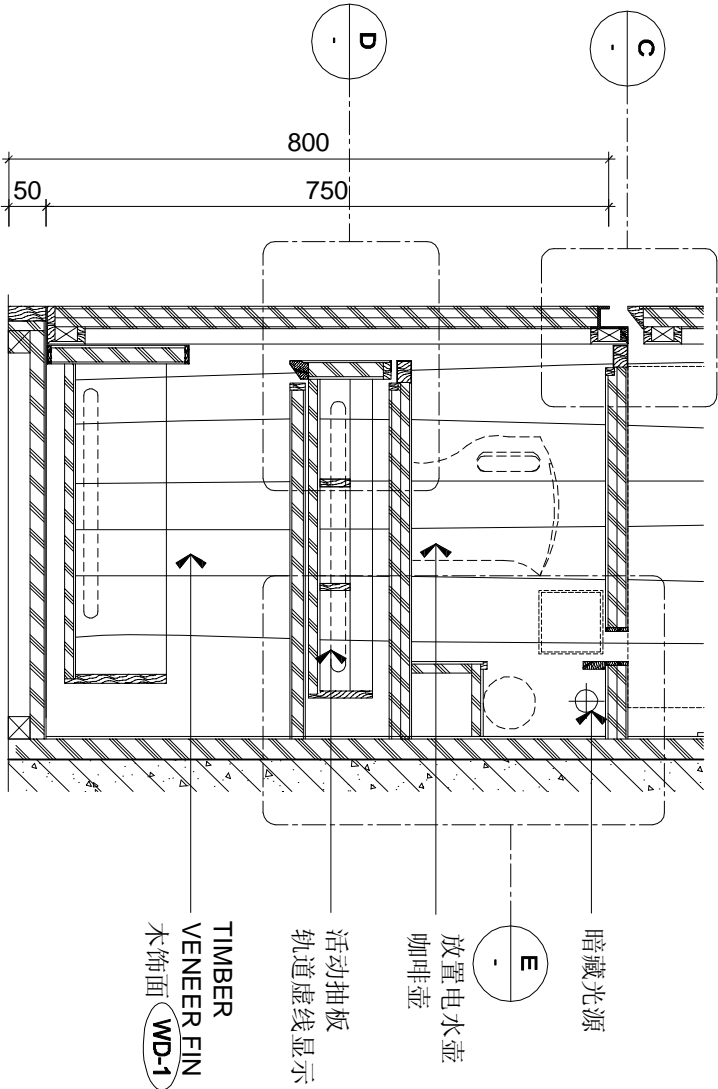


DETAIL
SCALE 1 : 5

B

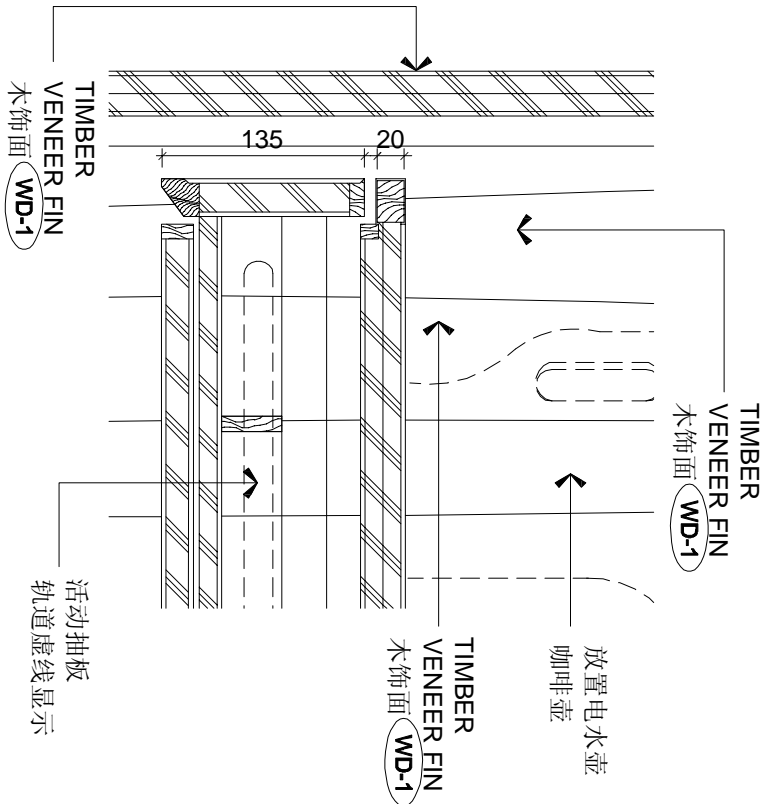


DETAIL
SCALE 1 : 5

D

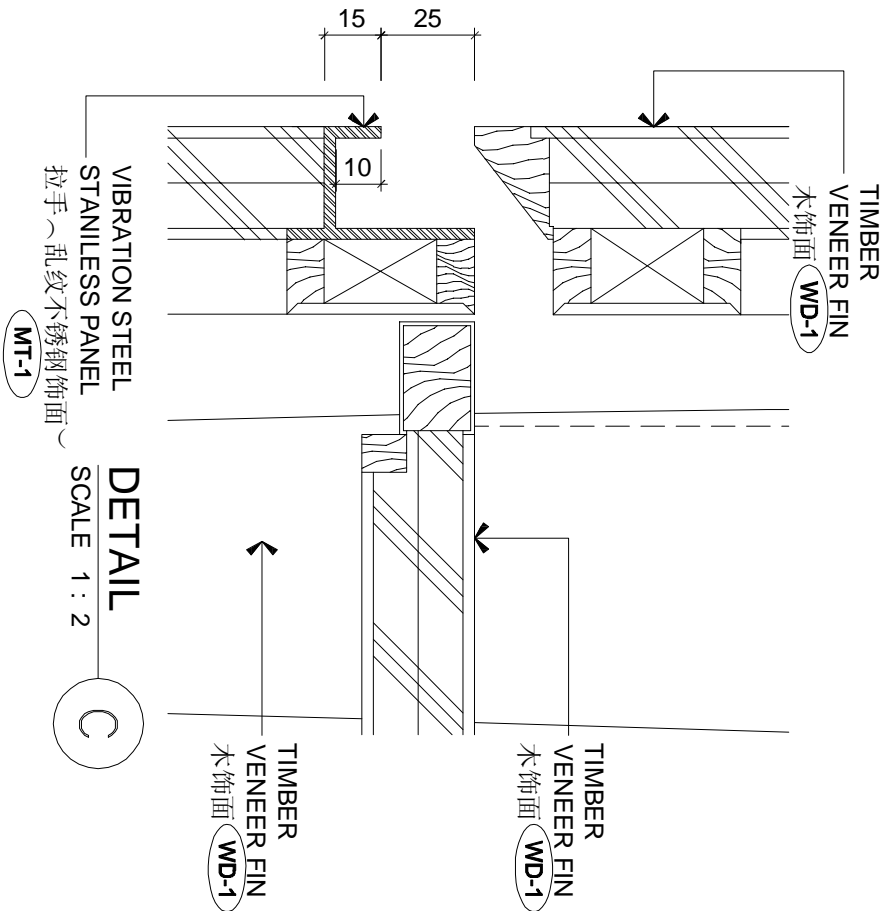

DETAIL
SCALE 1 : 2


C

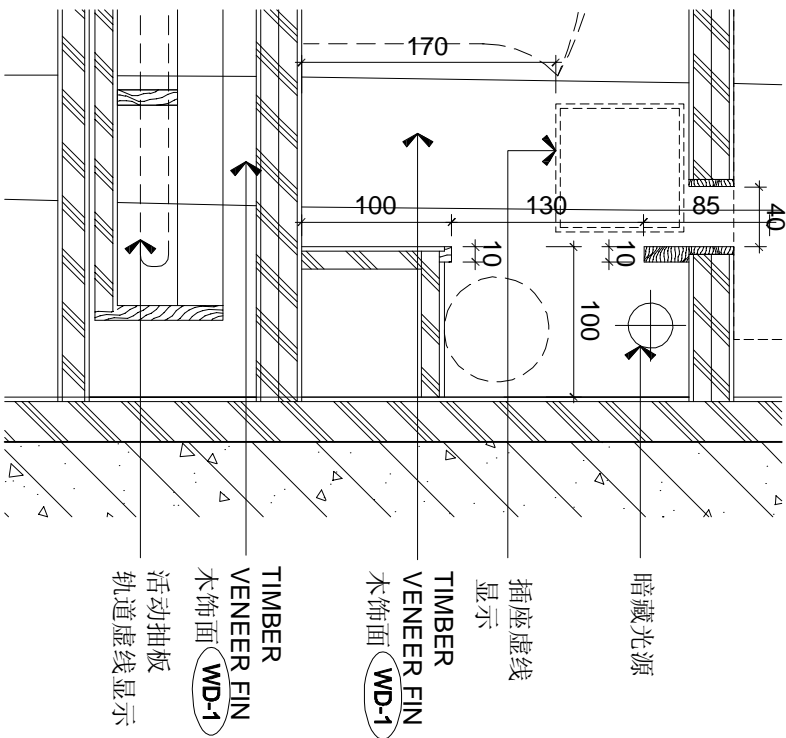

DETAIL
SCALE 1 : 5


E

REVISIONS AND ISSUES				CHHADA SIEMBIEDA LEUNG			
LOCATION OF REVISIONS ARE INDICATED ON DWG. AS				Limited, Design Consultants Hong Kong			
ISSUED FOR TENDER DRAWING				THE INTERCONTINENTAL SUZHOU			
				JIANGSU, CHINA			
				3 BAYS SUITE ROOM - DETAILS			
				DRAWN BY: STEPHEN			
				APPROVED BY: 07-01			
				PROJECT NO. FD-3BS-21			
				REVISION			
				DATE: 4/26/08			
				SCALE: AS SHOWN (AS)			
				DWG. NO. FD-31-23.dwg			

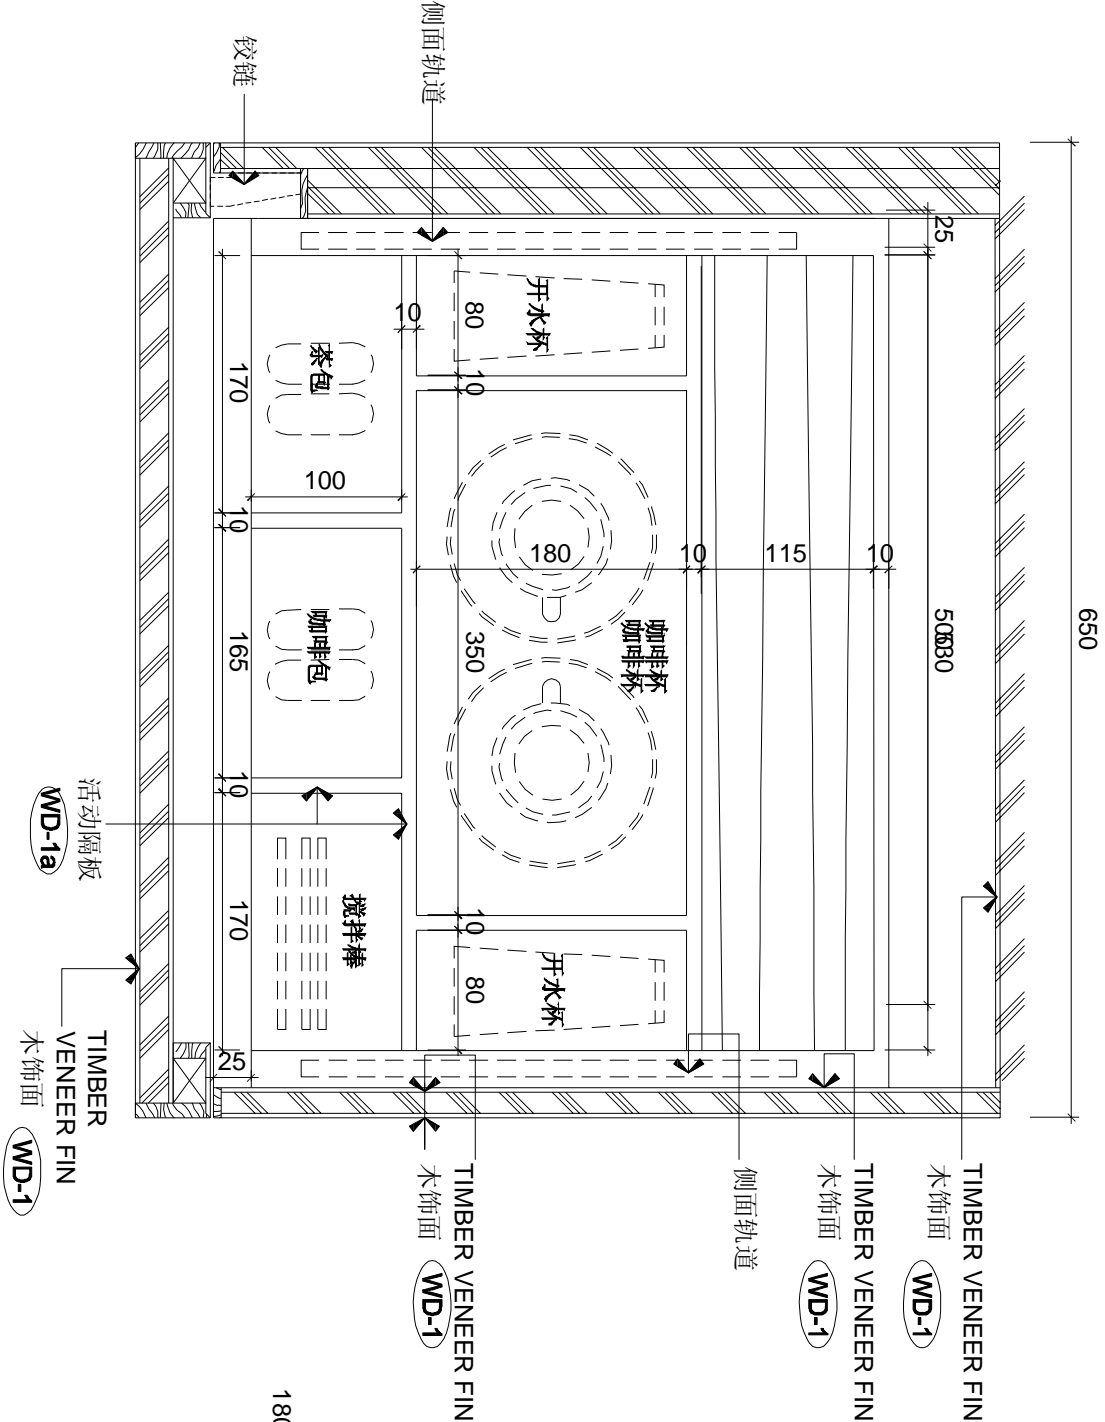

DETAIL
SCALE 1 : 5

A

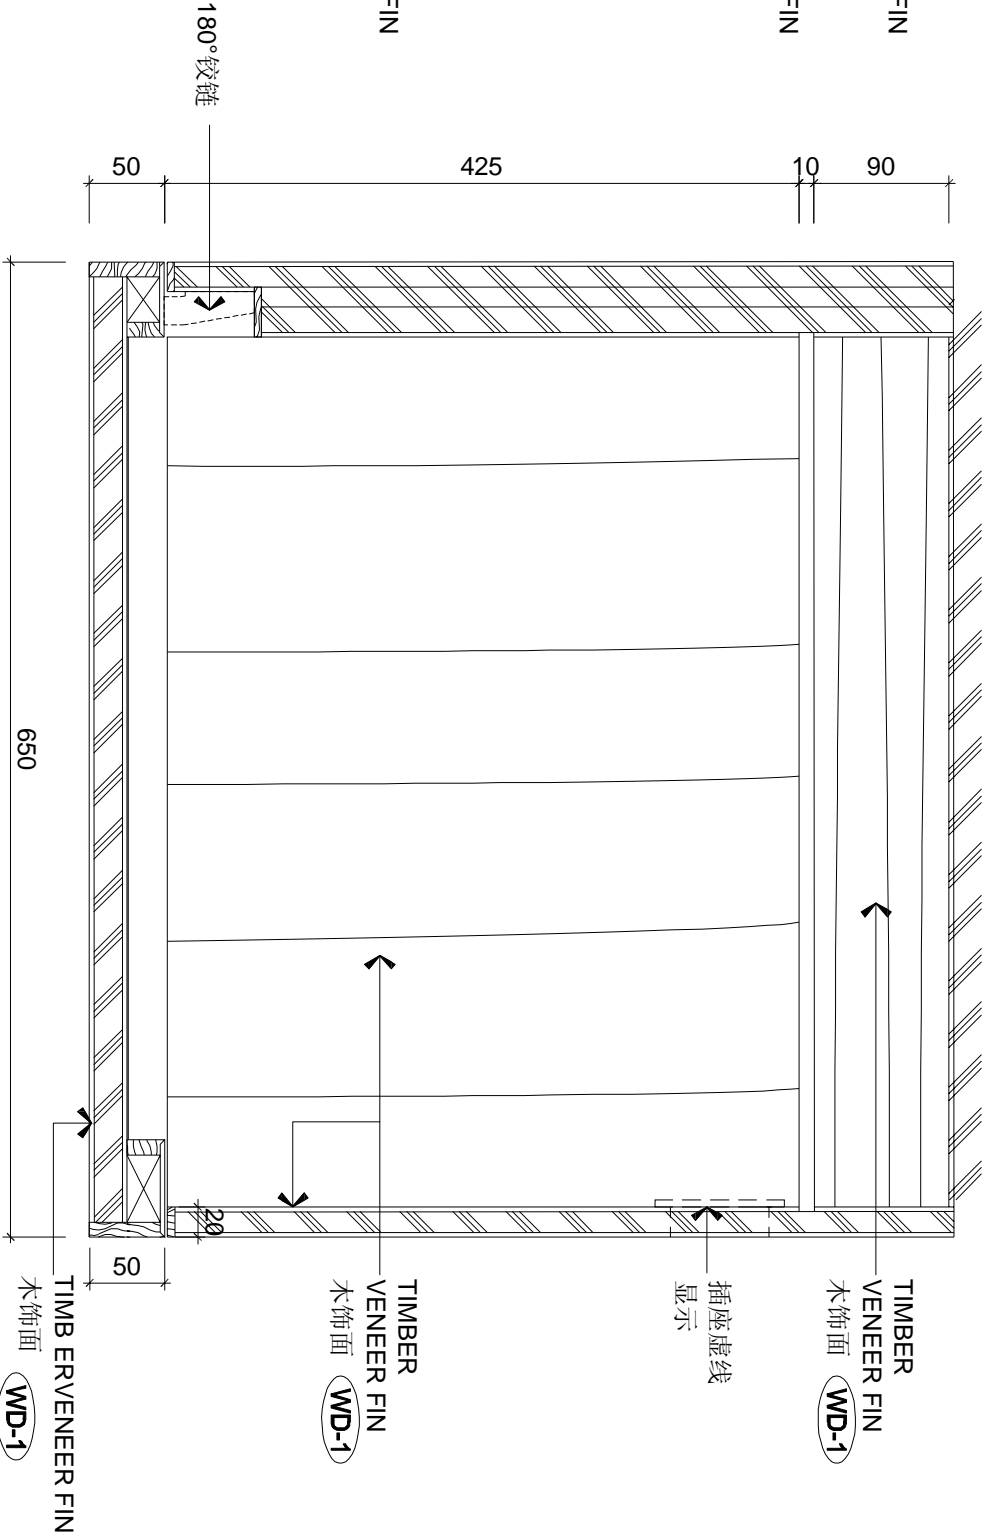

DETAIL
SCALE 1 : 5

B

REVISIONS AND ISSUES		DATE	
LOCATIONS OF REVISIONS ARE INDICATED ON DWG. AS		24/04/19	
ISSUED FOR TENDER DRAWING		A	
		B	
		C	
		D	
		E	
		F	
		G	
		H	
		I	
		J	
		K	
		L	
		M	
		N	
		O	
		P	
		Q	
		R	
		S	
		T	
		U	
		V	
		W	
		X	
		Y	
		Z	
		AA	
		AB	
		AC	
		AD	
		AE	
		AF	
		AG	
		AH	
		AI	
		AJ	
		AK	
		AL	
		AM	
		AN	
		AO	
		AP	
		AQ	
		AR	
		AS	
		AT	
		AU	
		AV	
		AW	
		AX	
		AY	
		AZ	
		BA	
		BB	
		BC	
		BD	
		BE	
		BF	
		BG	
		BH	
		BI	
		BJ	
		BK	
		BL	
		BM	
		BN	
		BO	
		BP	
		BQ	
		BR	
		BS	
		BT	
		BU	
		BV	
		BW	
		BX	
		BY	
		BZ	
		CA	
		CB	
		CC	
		CD	
		CE	
		CF	
		CG	
		CH	
		CI	
		CJ	
		CK	
		CL	
		CM	
		CN	
		CO	
		CP	
		CQ	
		CR	
		CS	
		CT	
		CU	
		CV	
		CW	
		CX	
		CY	
		CZ	
		DA	
		DB	
		DC	
		DD	
		DE	
		DF	
		DG	
		DH	
		DI	
		DJ	
		DK	
		DL	
		DM	
		DN	
		DO	
		DP	
		DQ	
		DR	
		DS	
		DT	
		DU	
		DV	
		DW	
		DX	
		DY	
		DZ	
		EA	
		EB	
		EC	
		ED	
		EE	
		EF	
		EG	
		EH	
		EI	
		EJ	
		EK	
		EL	
		EM	
		EN	
		EO	
		EP	
		EQ	
		ER	
		ES	
		ET	
		EU	
		EV	
		EW	
		EX	
		EY	
		EZ	
		FA	
		FB	
		FC	
		FD	
		FE	
		FF	
		FG	
		FH	
		FI	
		FJ	
		FK	
		FL	
		FM	
		FN	
		FO	
		FP	
		FQ	
		FR	
		FS	
		FT	
		FU	
		FV	
		FW	

CHHADA SIEMBIEDA LEUNG

Limited, Design Consultants Hong Kong

THE INTERCONTINENTAL SUZHOU

JIANGSU, CHINA

3 BAYS SUITE ROOM - DETAILS

FD-3BS-22

DATE

4/25/19

SCALE

AS SHOWN (AS)

PROJECT NO.

DRAWN BY

STEPHEN





APPROVED BY

07-01

FILE NAME

4-23-PROJECT-Chuang_HongKong_V22-01-15-Customer_Altitude-FromJiangsu010000-3BAYS-SUITE-ROOM-CHINA-PROJ-CHG-FD-3-21-22-04-19

DWG. NO.

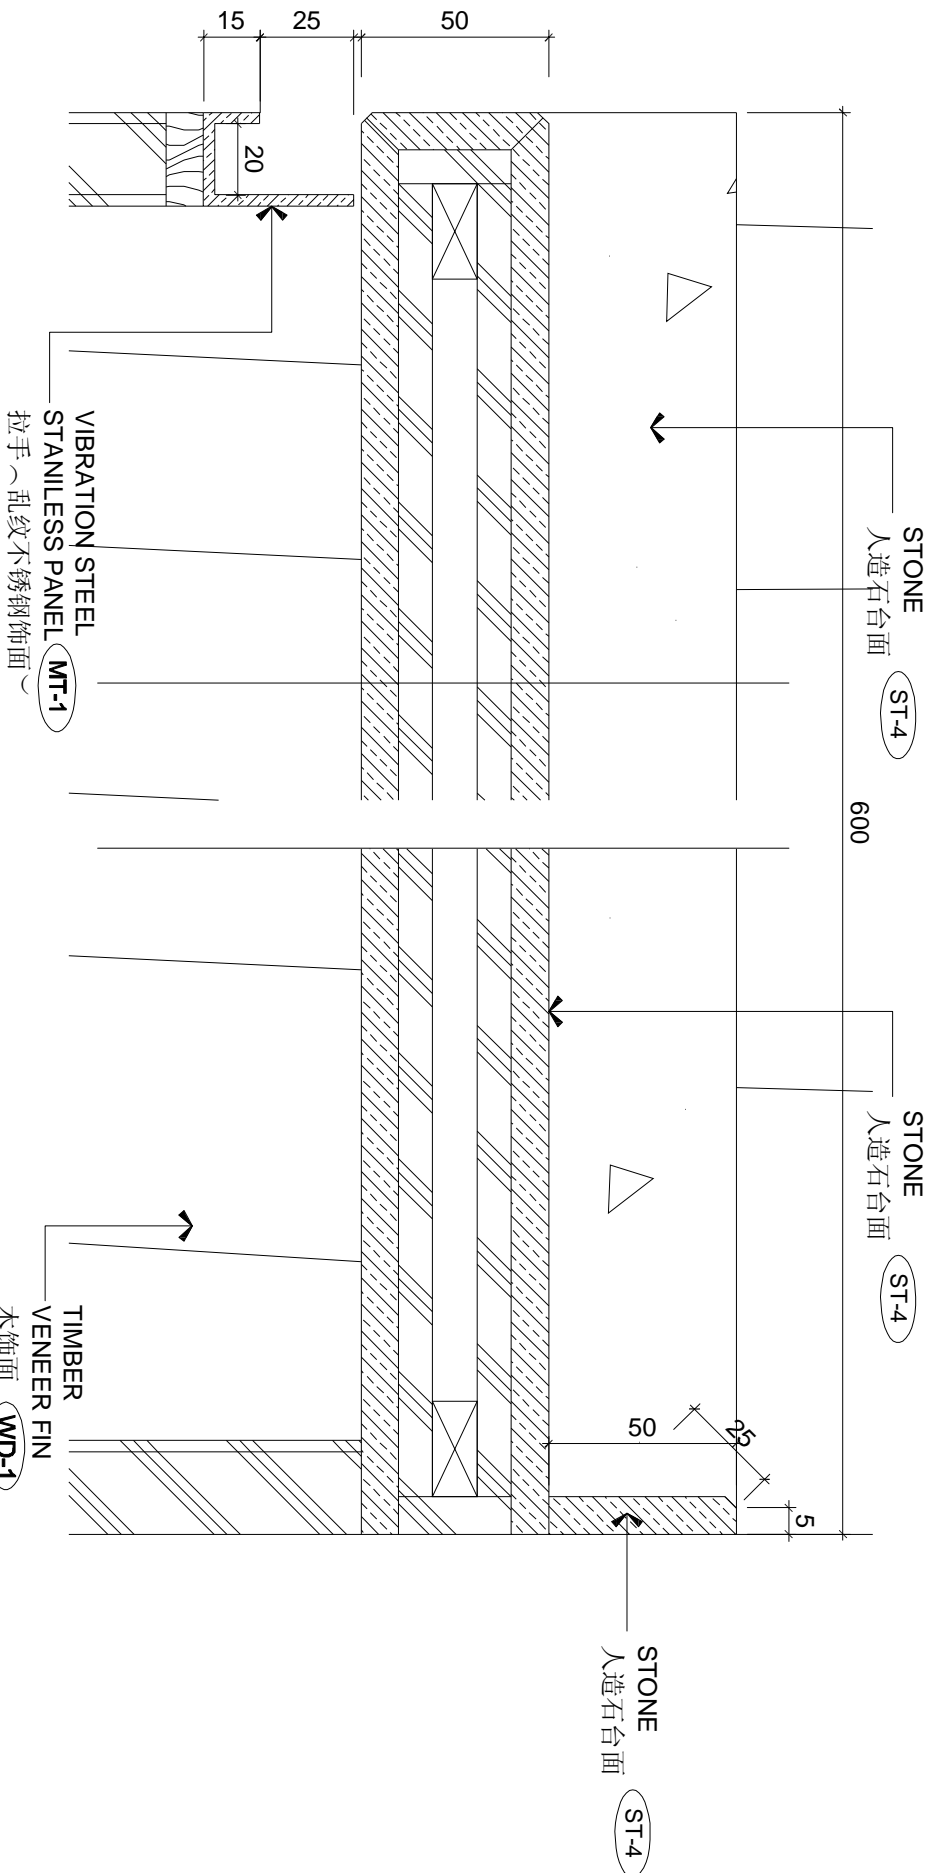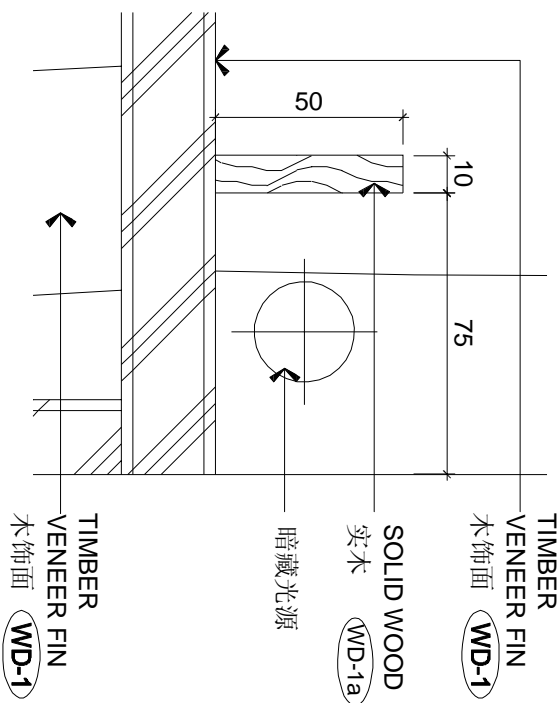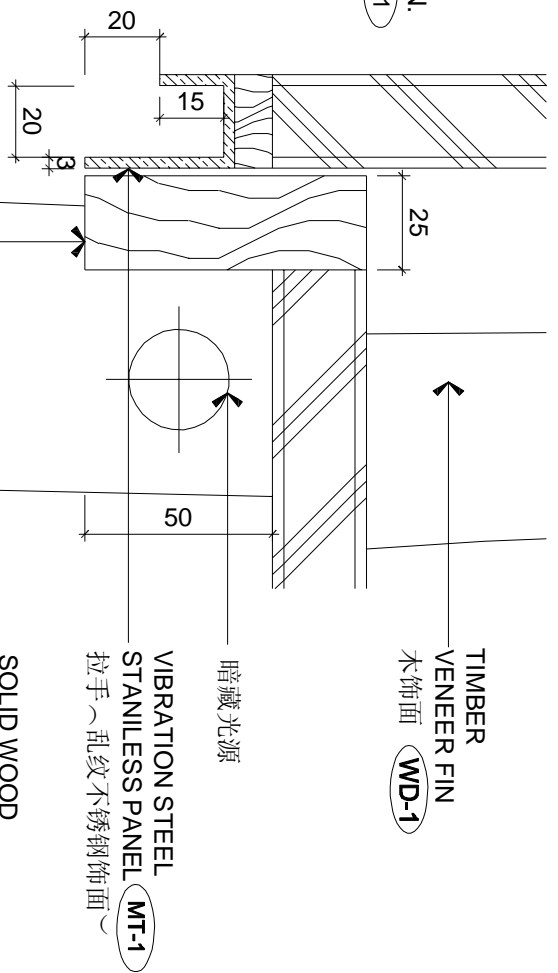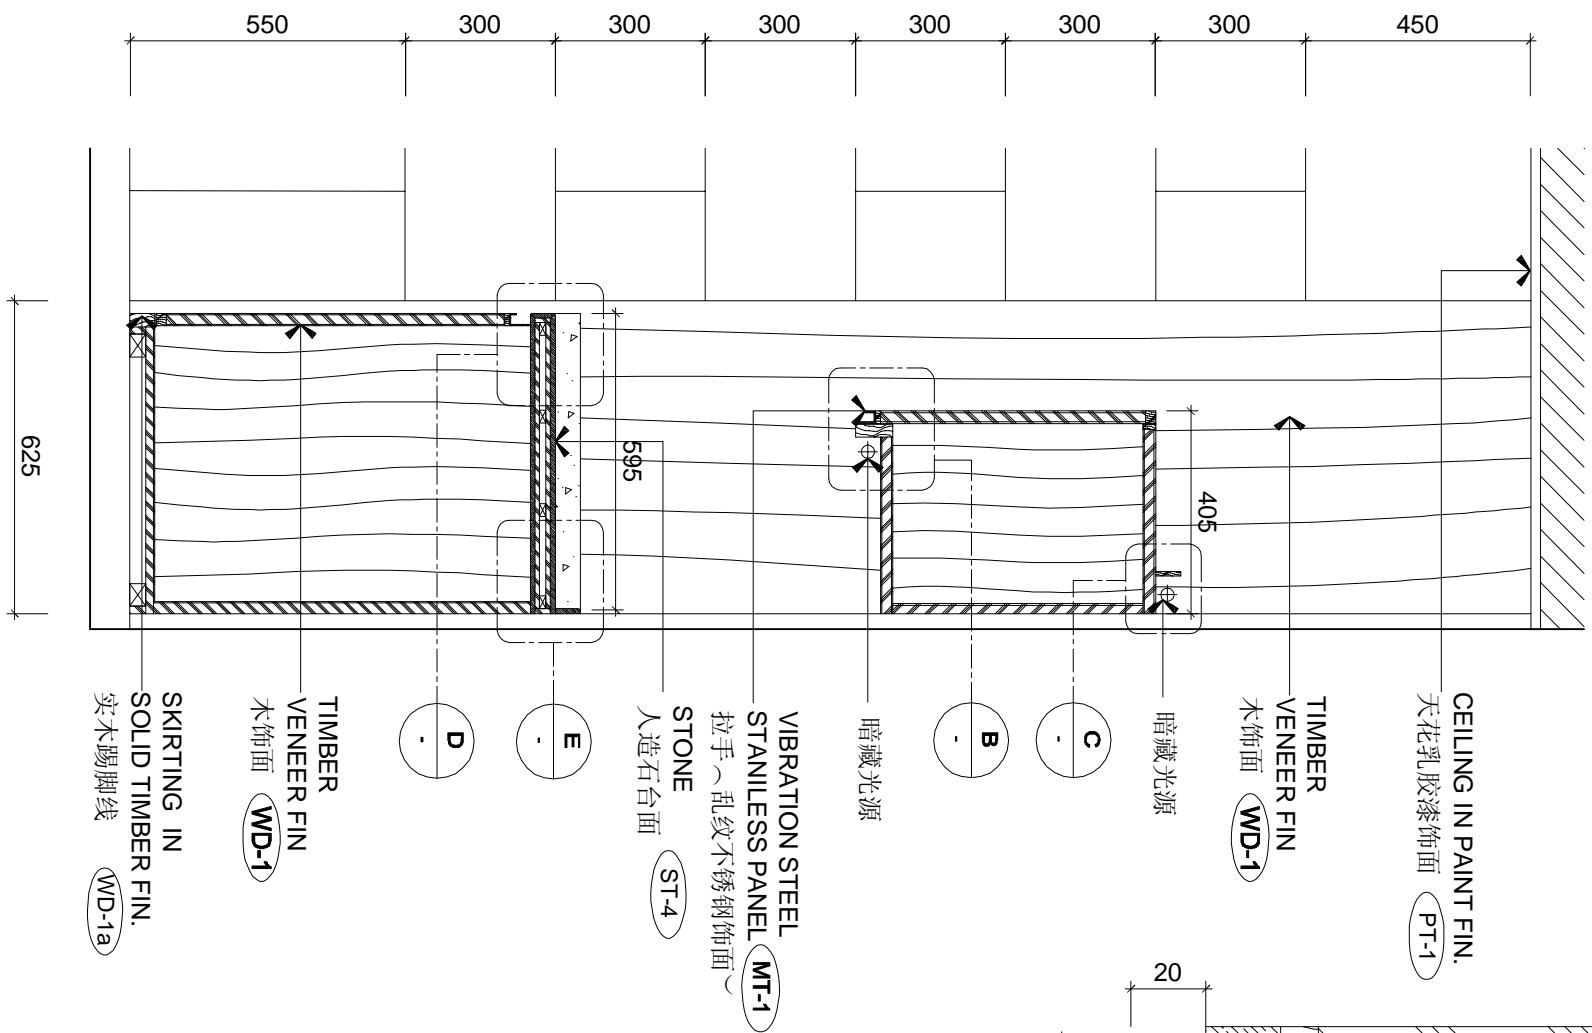

DETAIL

SCALE 1:15

DETAIL

SCALE 1 : 2

DETAIL

SCALE 1:2

[illegible]