


REV	DATE	DESCRIPTION
-	16/05/07	ISSUED FOR INFORMATION

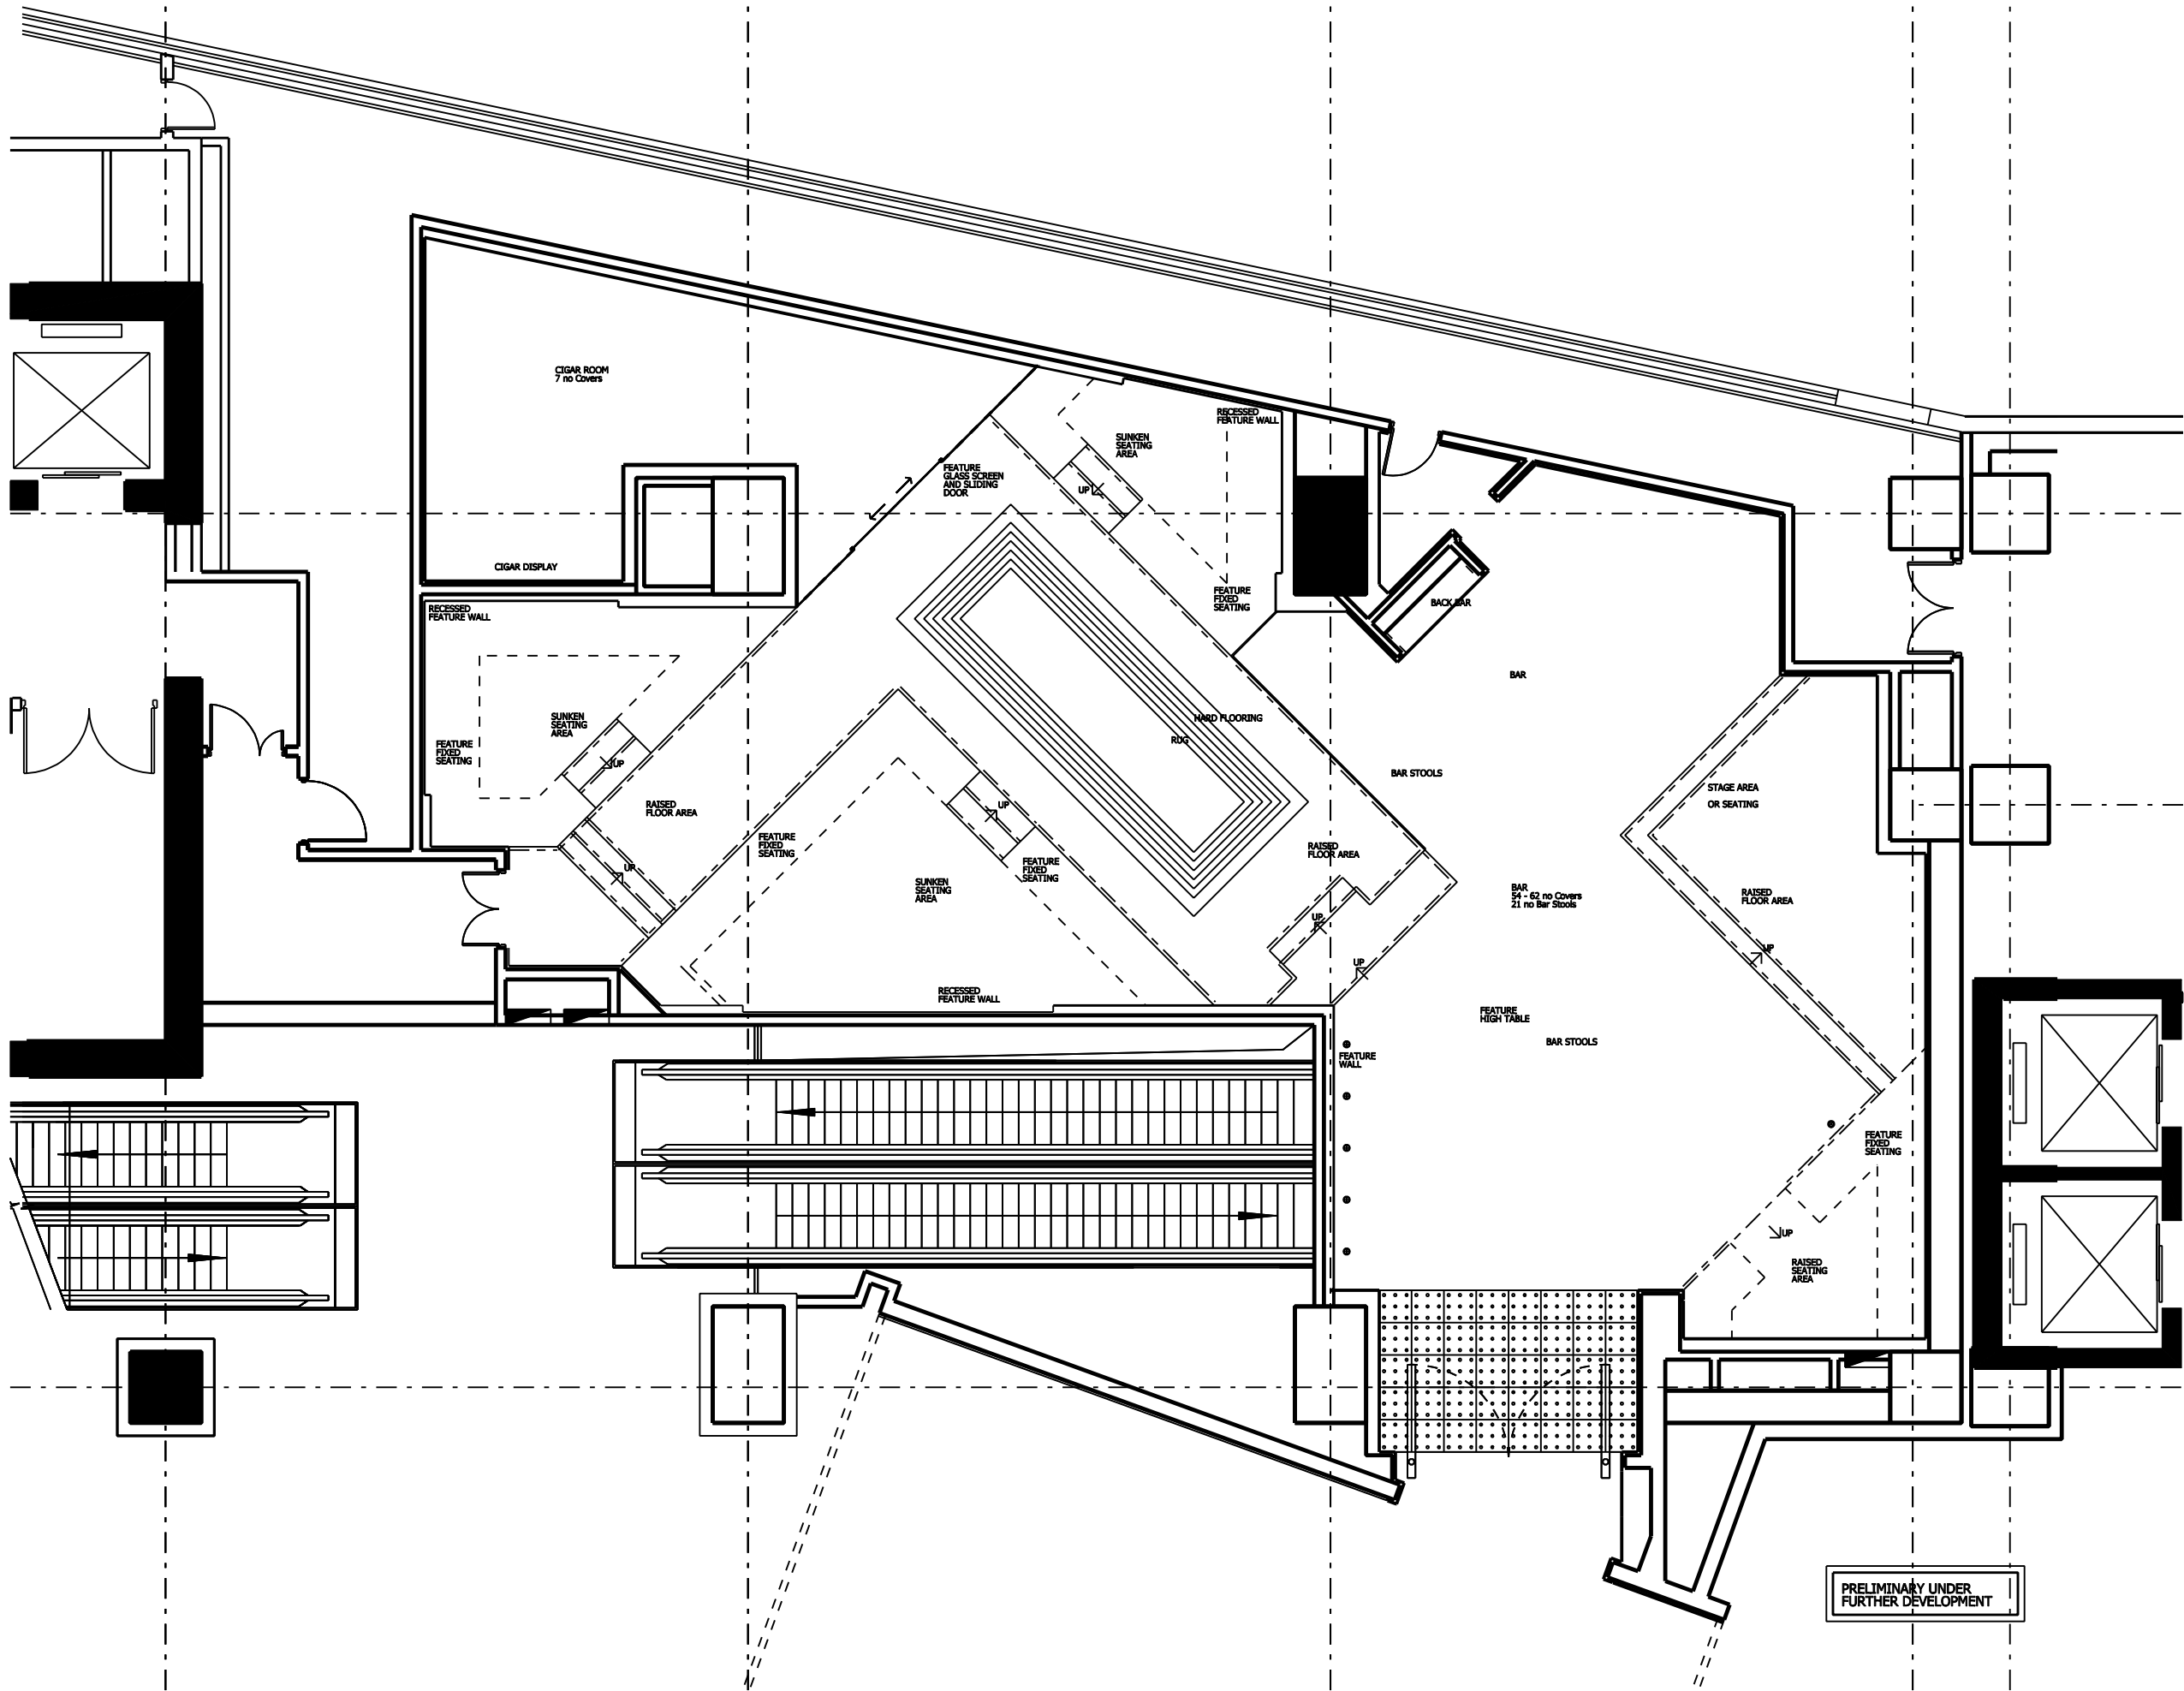

SMALL POWER/ELECTRICAL
LAYOUT PLAN TO BE
COORDINATED WITH
ELECTRICAL CONSULTANT,
F&B, AV AND LIGHTING
CONSULTANT



CLIENT
BEIJING MODERN ASIA PACIFIC
REAL ESTATE COMPANY LTD
PROJECT
WESTIN BEIJING
CHAOYANG HOTEL
PROJECT NO. 448

DESCRIPTION		
AREA 06 DARK BAR		
LEVEL 2		
GA ELECTRICAL LAYOUT PLAN		
SCALE	DATE	DRAWN BY
1:50@A1	09/05/07	J.I

WORK TO FIGURED DIMENSIONS
DO NOT SCALE THIS DWG
CHECK DIMENSIONS ON SITE
BEFORE COMMENCING WORK

KCA 448 06 05

