




04 SECTION @ DOOR D-02
Scale: 1 : 5

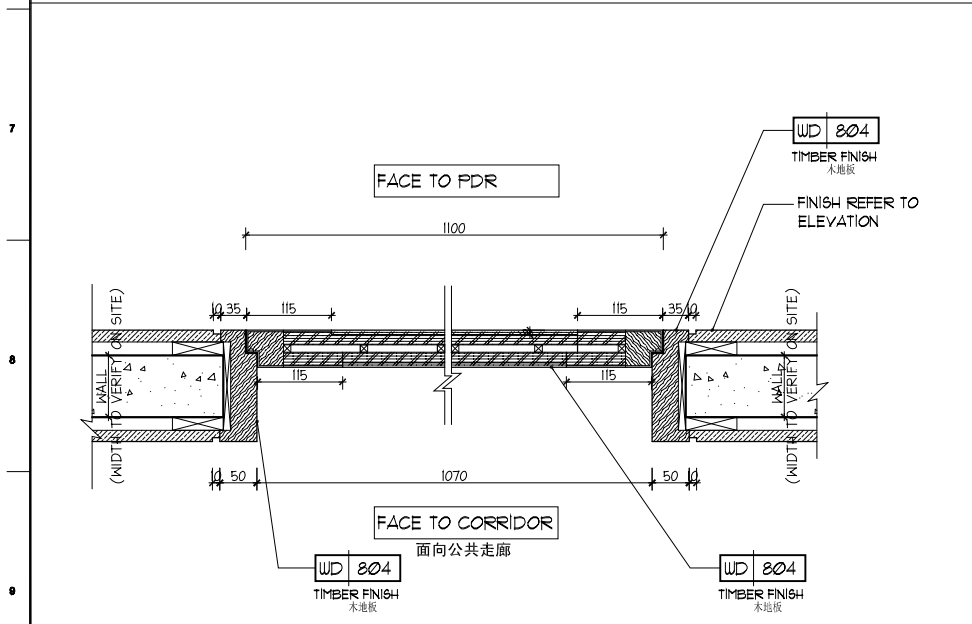

03 PLAN @ DOOR D-02
Scale: 1 : 5

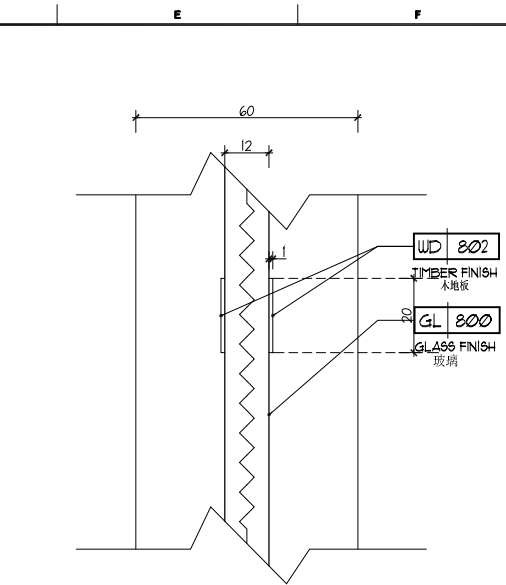


B DETAIL
Scale: 1 : 1

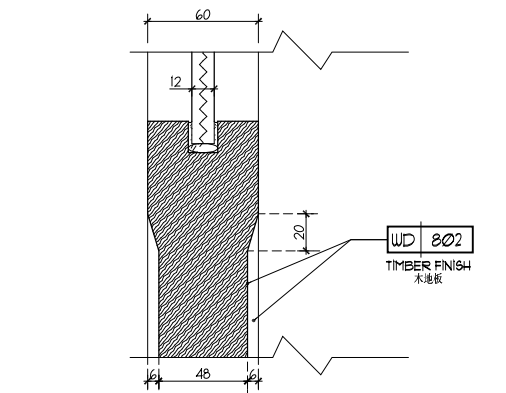


A DETAIL
Scale: 1 : 2

02 SECTION @ DOOR D-01
Scale: 1 : 5

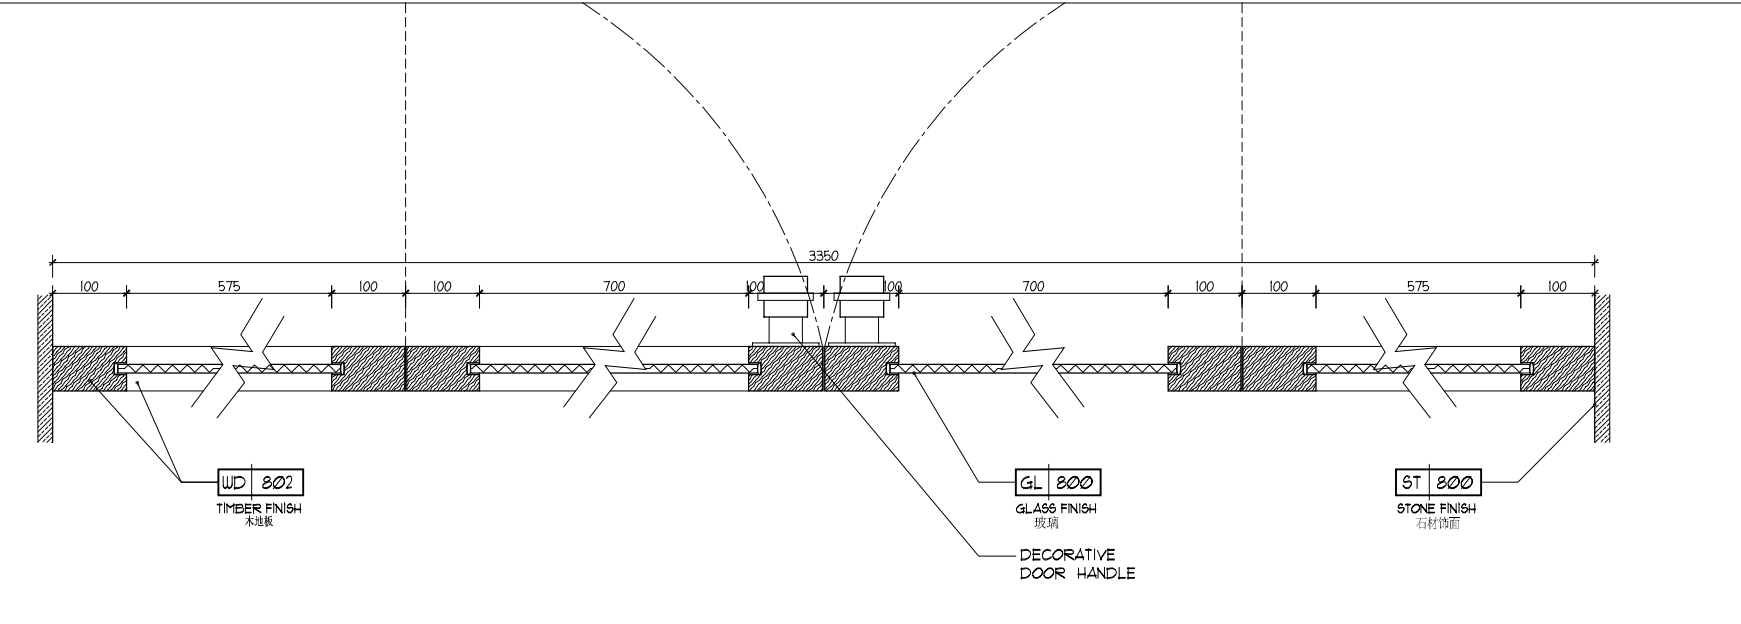


01 PLAN @ DOOR D-01
Scale: 1 : 5

 * CONTRACTOR TO SUBMIT PROVIDE SHOP DRAWING & CALCULATION FOR STRUCTURAL ENGINEER / DESIGNER'S APPROVAL BEFORE CONSTRUCTION.
承建商/生产商须提交相关的生产图及物料样板予客方及设计师审批。
工程中，如有牵涉到影响楼宇结构、消防系统、机电系统等事宜；相关的专业顾问（如：结构工程师、消防顾问、机电顾问等），均须参与有关的协调工作，并确保该项目能符合当地之政府规范要求。



WWW.HBDESIGN.COM

杭州萧山雷迪森酒店
LANDISON HOTEL
XIAOSHAN HANGZHOU

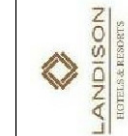

LEVEL 35
ITALIAN RESTAURANT & EXECUTIVE LOUNGE
DOOR DETAIL
三十五层行政酒廊 / 意大利餐厅 门详图

17 APRIL 2012
REVISIONS DATE

This drawing is for information only to be used by the contractor as a general arrangement of interior conditions. It has been made from available information; however measurements are to be verified on project site. This drawing must be verified and approved prior to final detailing and construction.
This drawing is the property of HIRSCH BEDNER AND ASSOCIATES and is not to be reproduced or copied in whole or in part. It is to only be used for the project and site specifically identified herein and is not to be used on any other project. It is to be returned upon request.

APPROVED

DRAWN BY

DATE

SCALE AS SHOWN

SHEET No.
DD
10.1-1
PROJECT No.
2829.00

HIRSCH BEDNER ASSOCIATES ■ DESIGN CONSULTANTS ■ 23/F VICWOOD PLAZA ■ 199 DES VOEUX ROAD CENTRAL ■ HONG KONG ■ 852-2542-2022