

## Project 項目名稱 | 賽高城市廣場洲際酒店, 西安

Job No.項目編號 ABC-600-標準客房樣板房 \_ (大床及雙床)


DAY 日	16
MONTH 月	12
YEAR 年	2013

[illegible][illegible]








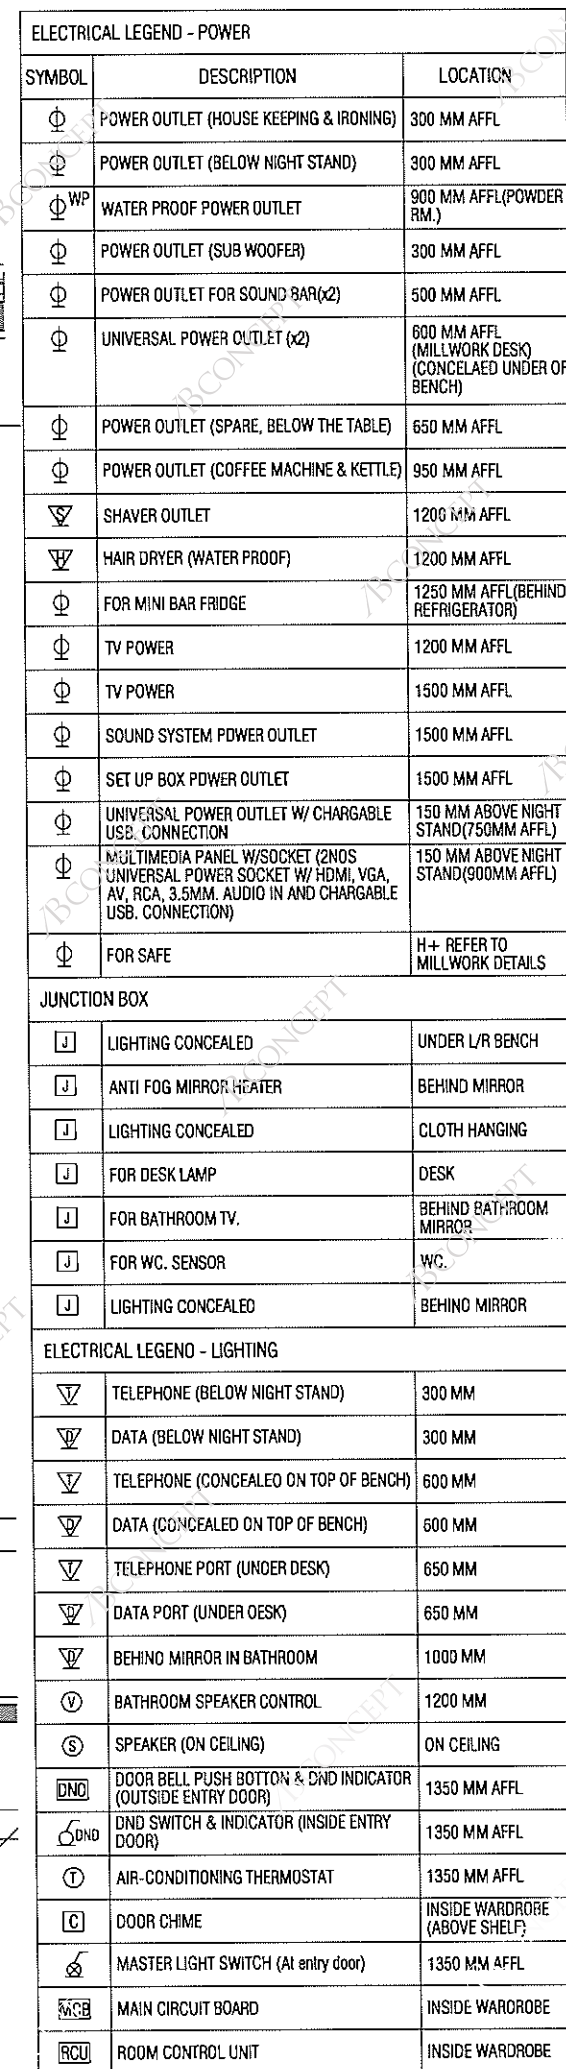

EM 機電分佈圖 规模-1:25

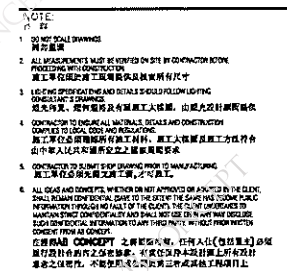


△ 招標階段發送	16 DEC 2013
<p>註釋:</p> <ul style="list-style-type: none"> <li>-有關所有機電、燈光、隔音、影音、消防、廚房、結構、保安、升降機、建築、外牆及雕塑設計，請參考有關顧問及專家提供之詳圖及資料</li> <li>-施工單位</li> <li>-施工單位必須提交施工圖及樣板予設計師確認方可施工</li> </ul>	


ARCHITECTURAL CONSULTANT

DRAWING TITLE :  
圖名  
MOCK UP ROOM  
FLOOR COVERING PLAN  
地坪飾面圖


DWG NO: 7 3

P5-001 




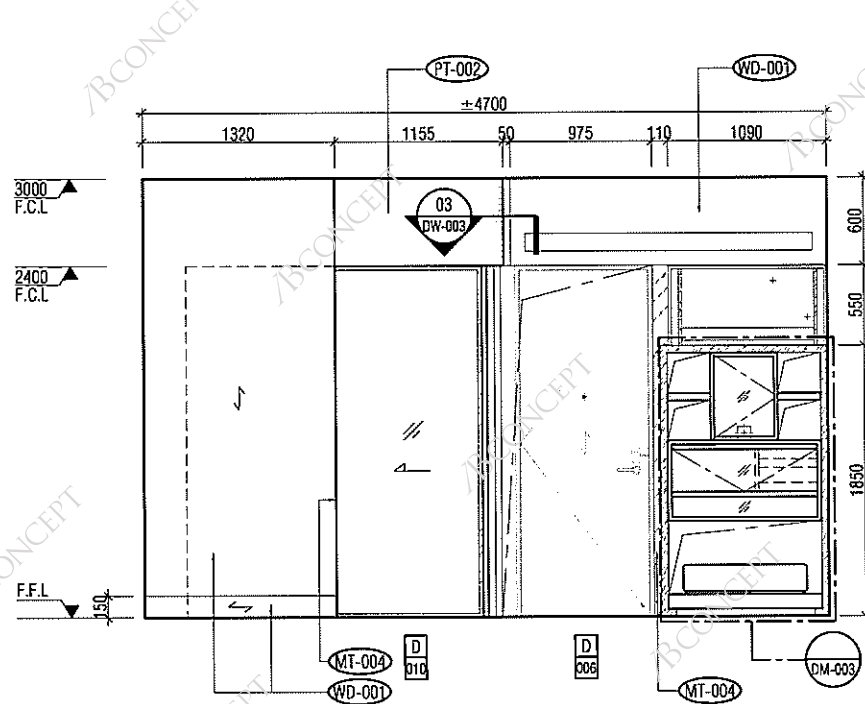


01 立面圖  
KING ROOM 规模-1:25

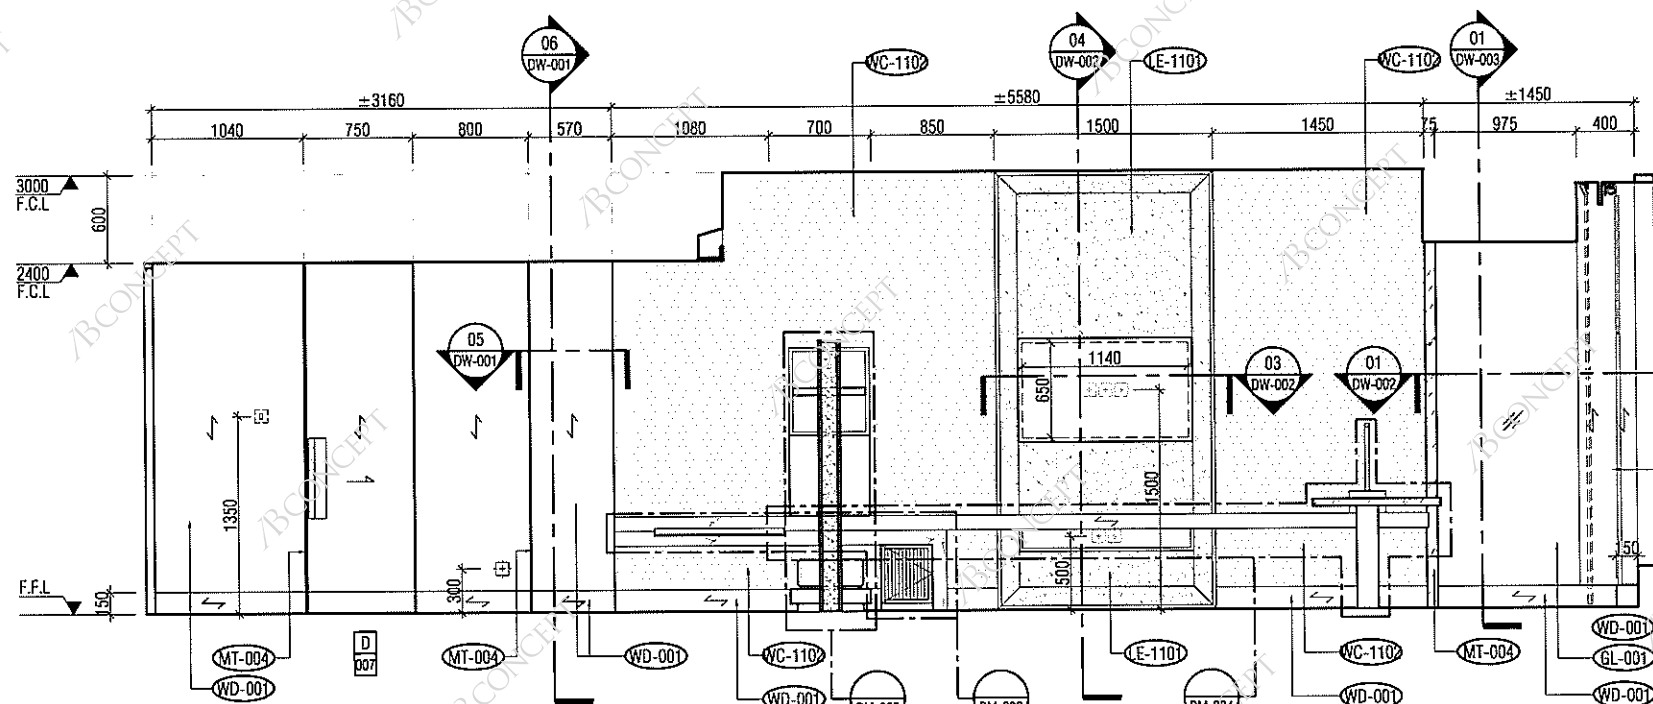

02 立面圖  
KING ROOM 规模-1:25

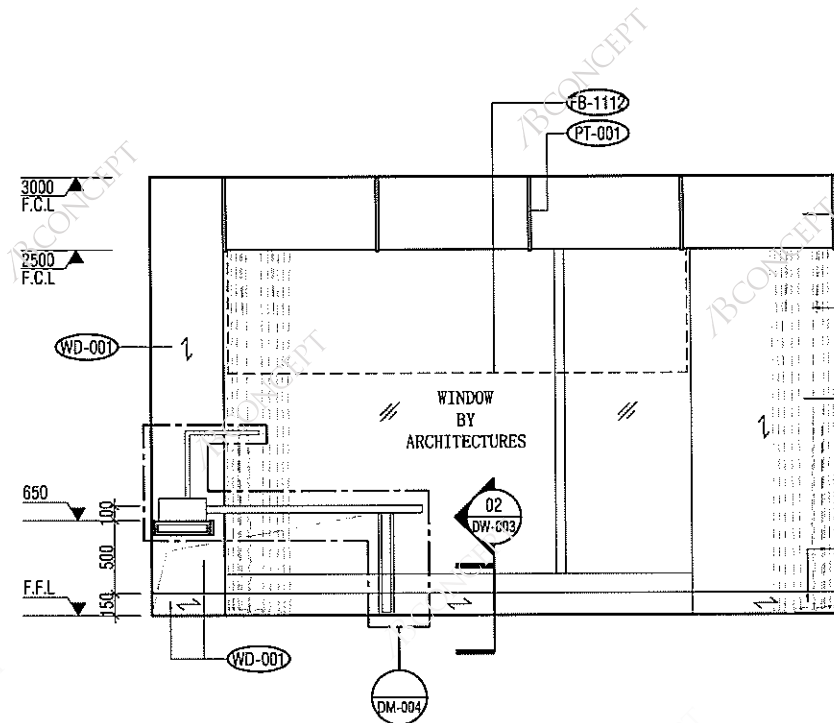

03 立面圖  
KING ROOM 规模-1:25

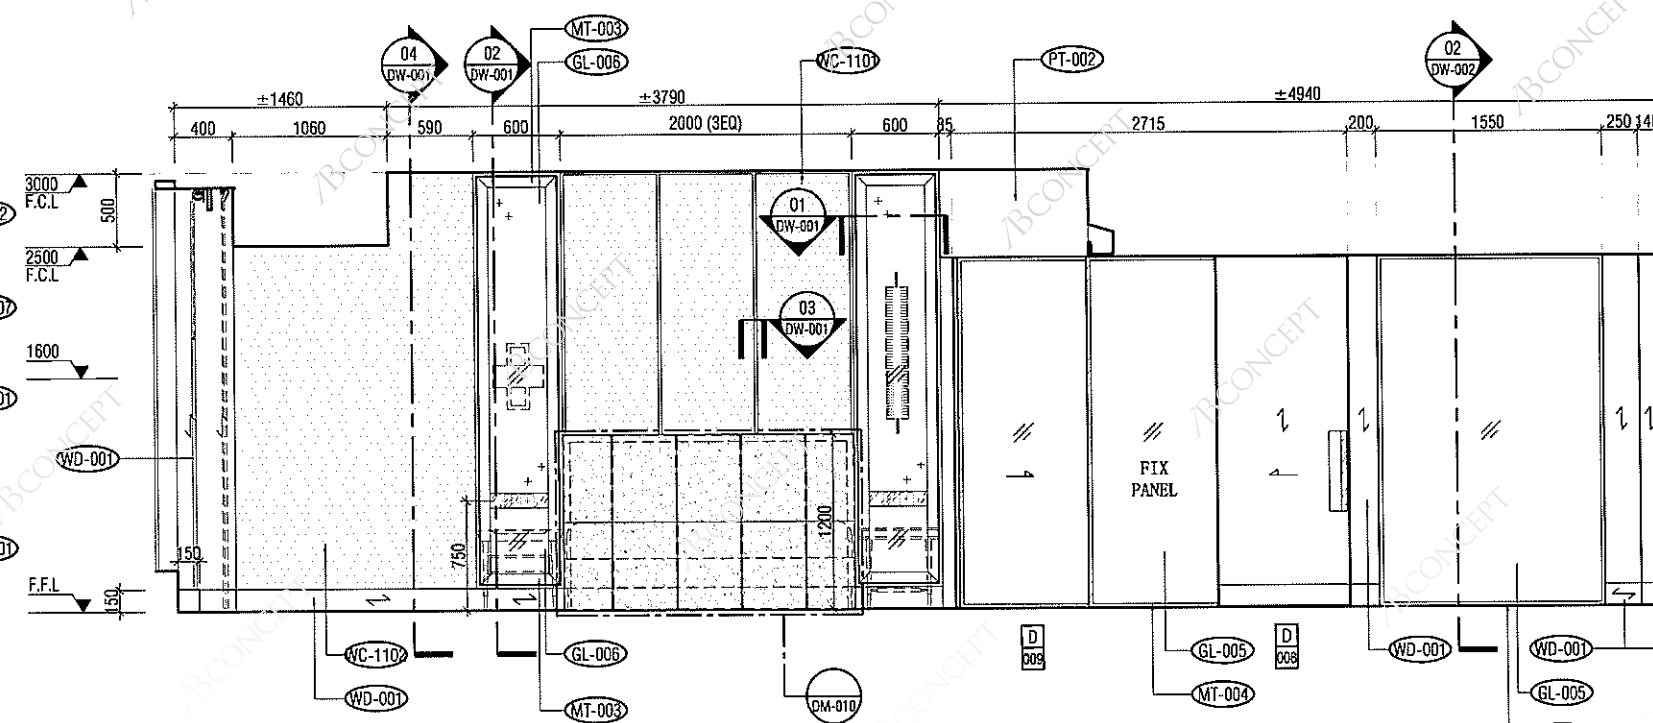

04 立面圖  
KING ROOM 规模-1:25

NOTE:  
1. ALL DIMENSIONS MUST BE VERIFIED BY CONSTRUCTION WORK.  
2. ALL DIMENSIONS MUST BE VERIFIED BY CONSTRUCTION WORK.  
3. ALL DIMENSIONS MUST BE VERIFIED BY CONSTRUCTION WORK.  
4. ALL DIMENSIONS MUST BE VERIFIED BY CONSTRUCTION WORK.  
5. ALL DIMENSIONS MUST BE VERIFIED BY CONSTRUCTION WORK.

REVISIONS	DATE
1	16 DEC 2013

招標階段發送 16 DEC 2013  
註釋:  
-有關所有機電、燈光、隔音、影音、消防、廚房、結構、保安、升降機、建築、外牆及牆面設計, 請參考有關顧問及專家提供之詳圖及資料。  
-施工單位  
-施工單位必須提交施工圖及樣板予設計師, 經認可方可施工。

PROJECT MANAGER: ☐

M&E CONSULTANT: ☐

ARCHITECTURAL CONSULTANT: ☐

DESIGNER:  
**ABCONCEPT**  
All Design Limited  
1101 Lantau Centre, Cheung Chee, Hong Kong  
電話: 2626 0000  
www.abconcept.com.hk

DRAWING TITLE:  
標準樣板房  
大床房  
立面圖

PROJECT NAME:  
中國西安  
賽高城市廣場洲際酒店

PROJECT NO:  
ABC-600

CHECKED BY:  
ABC

DATE:  
16 DEC 2013

DRAWN BY:  
J.L.

SCALE:  
A1 = 1:25  
A3 = 1:50

DWG NO:  
EL-001

[illegible]

△ 招標階段發送	16 DEC 2013
註釋:	
<p>-有關所有機電、燈光、隔音、影音、消防、廚房、電梯、保安、升降機、建築、外牆及牆壁設計，請參考有關圖則及專家提供之詳圖及資料</p> <p>-施工單位</p> <p>-施工單位必須提交施工圖及樣板予設計師確認方可施工</p>	

PROJECT MANAGER: ☐

MSE CONSULTANT ☐

ARCHITECTURAL CONSULTANT: ☐

DESIGNER:

**B CONCEPT**

AB Concept Limited  
1801 Legation Court, Causeway Bay, Hong Kong  
威利利銀禧中心 1801室  
www.abconcept.com.hk Tel: +852 25252616

DRAWING TITLE:  
標準樣板房  
大床浴室  
立面圖


PROJECT NAME  
I 型水櫃

 
中國西安  
賽高城市廣場洲際酒店

PROJECT NO	
100000	ABC - 600
CHECKED BY:	DRAWN BY:

DATE	SCALE
1/15	A1 = 1:25

16-DEC-2013 A3 = 1:50  
DWG NO: 1000  
K M

EL-002      



[illegible]

- 施工單位  
- 施工單位必須提交施工圖及樣板予設計師  
確認方可施工

ARCHITECTURAL CONSULTANT:

DWG NO:

  EL-003 

[illegible]

註釋:  
-有關所有機電、燈光、隔音、影音、消防、廚房、結構、保安、升降機、建築、外牆及雕塑設計,請參考有關顧問及專家提供之詳圖及資料

- 施工單位
- 施工單位必須提交施工圖及樣板予設計師  
 驗製方可施工

PROJECT MANAGER: \_\_\_\_\_

M&amp;E CONSULTANT

ARCHITECTURAL CONSULTANT

DESIGNER:

**ABCONCEPT**

AB Concept Limited  
1801 Leighton Centre, Colman St, Hong Kong  
香港利源中心1801室  
web: [www.abconcept.net](http://www.abconcept.net) Tel: +852-2525408

DRAWING TITLE :  
圖 名  
標準樣板房  
衛生間  
立面圖

PROJECT NAME  
工程名称

中國西安  
賽高城市廣場洲際酒店

PROJECT NO  
工程號 ABC-600


CHECKED BY: 20 09 ABC	DRAWN BY: 20 09 J.L
--------------------------	------------------------

DATE	SCALE
	A1 = 1:25


13-DEC-2013 A3 = 1:50

FI-004 A


\_\_\_\_\_

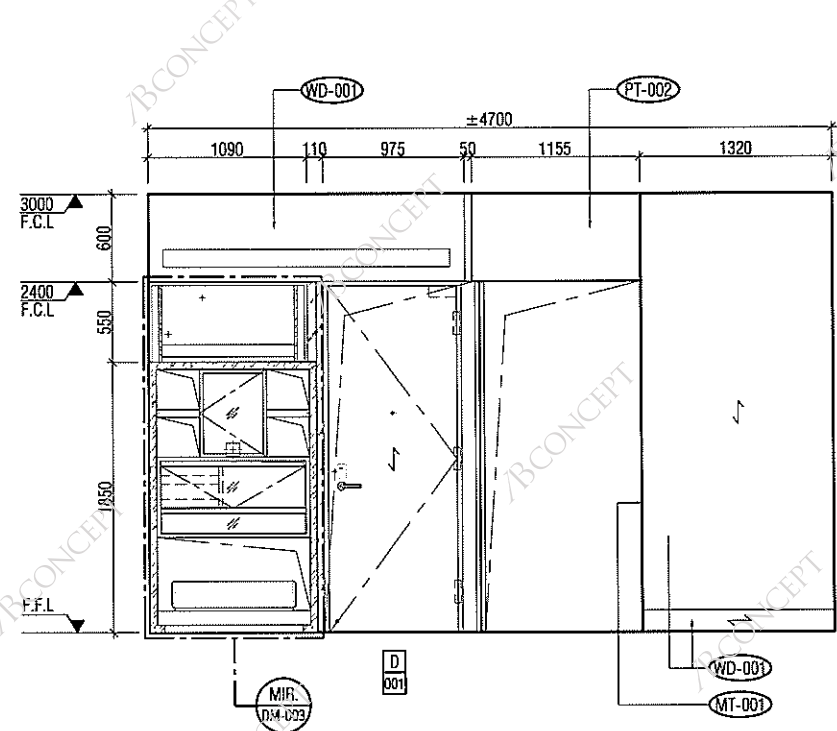


17 立面圖  
標準雙人房 規模-1:25

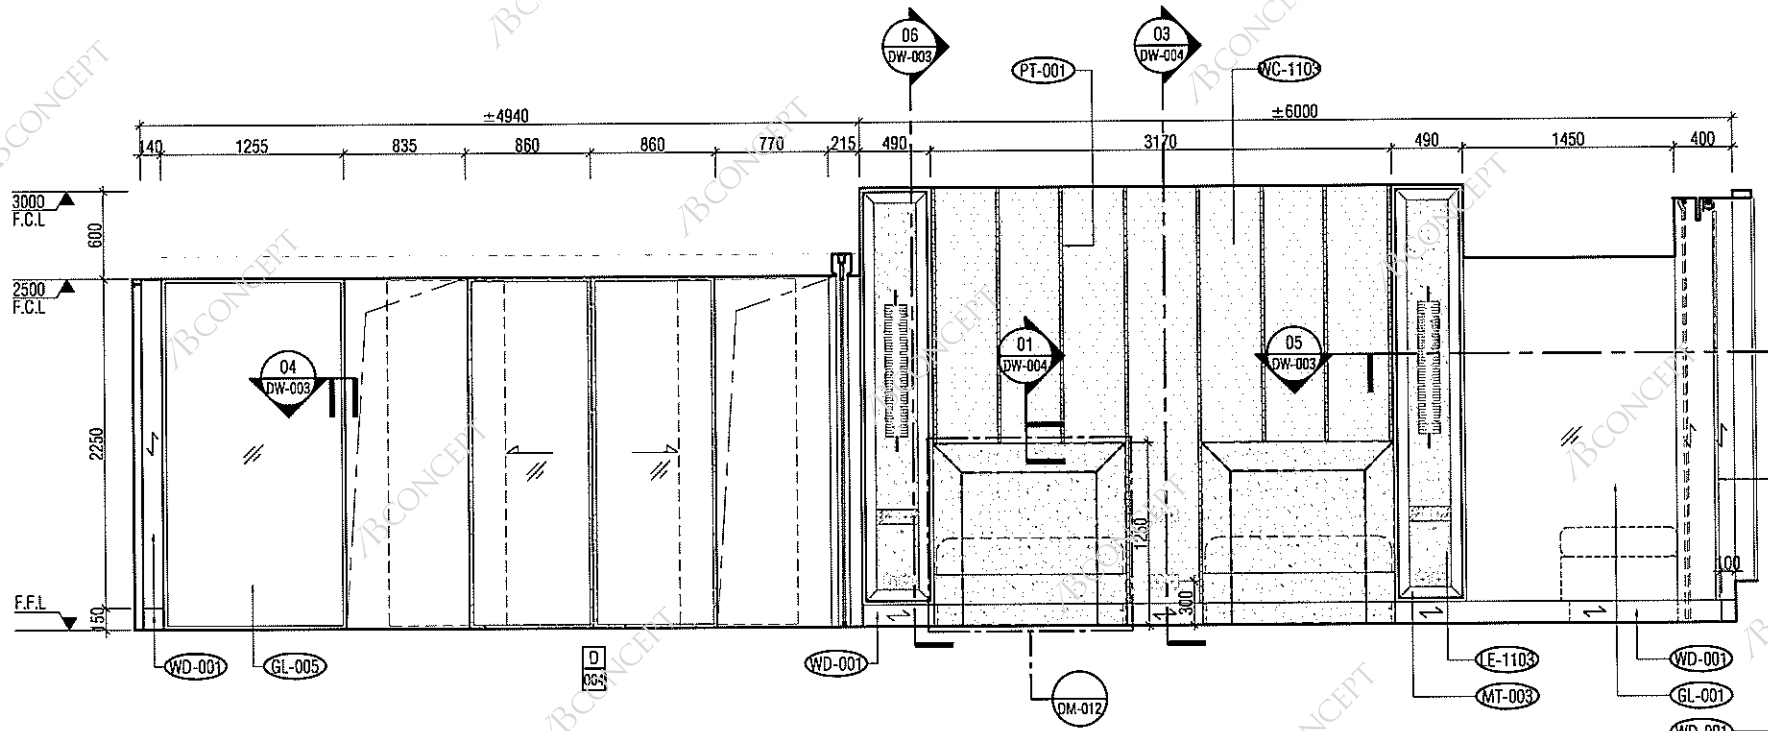

18 立面圖  
標準雙人房 規模-1:25

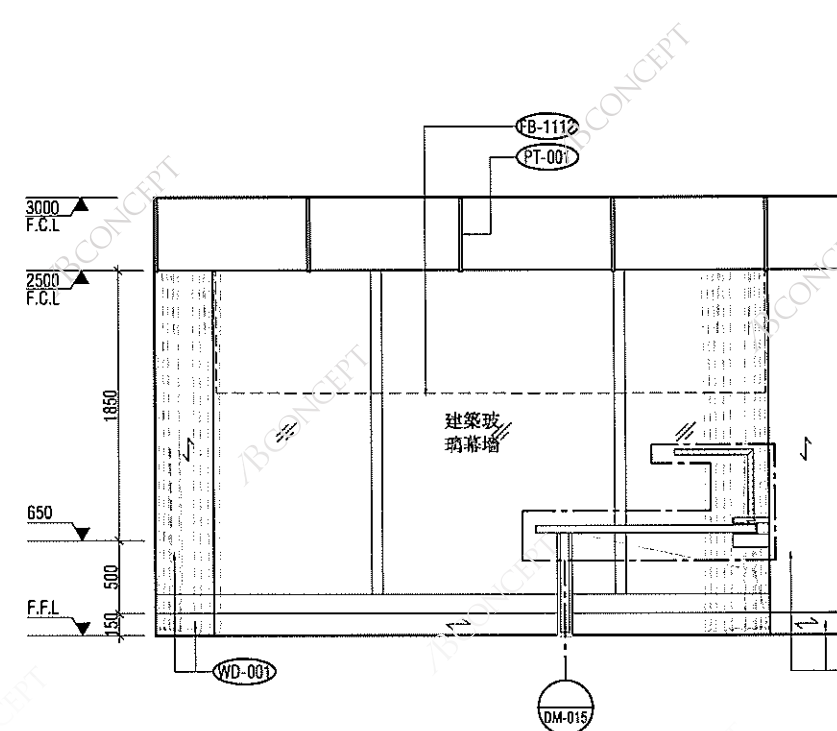

19 立面圖  
標準雙人房 規模-1:25

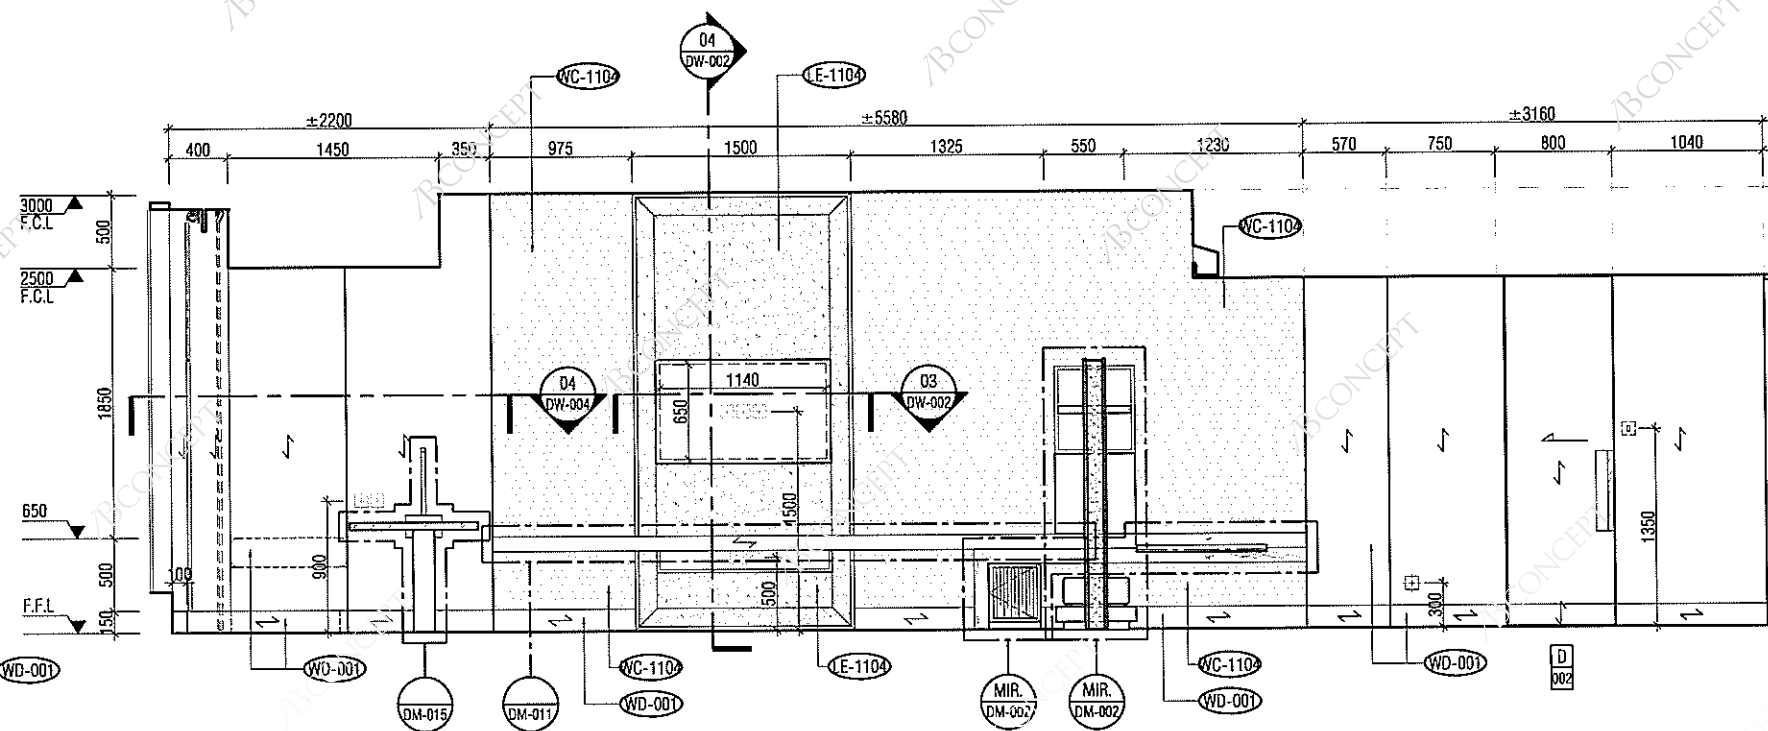

20 立面圖  
標準雙人房 規模-1:25

NOTE:  
1. ALL DIMENSIONS ARE IN METERS UNLESS OTHERWISE SPECIFIED.  
2. ALL DIMENSIONS ARE TO FACE UNLESS OTHERWISE SPECIFIED.  
3. ALL DIMENSIONS ARE TO FACE UNLESS OTHERWISE SPECIFIED.  
4. ALL DIMENSIONS ARE TO FACE UNLESS OTHERWISE SPECIFIED.  
5. ALL DIMENSIONS ARE TO FACE UNLESS OTHERWISE SPECIFIED.

REVISIONS NO.	DATE
1	16 DEC 2013

招標階段發送 16 DEC 2013  
註釋:  
-有關所有機電、燈光、隔音、影音、消防、廚房、結構、保安、升降機、建築、外牆及牆面設計, 請參考有關圖則及專家提供之詳圖及資料  
-施工單位  
-施工單位必須提交施工圖及樣板予設計師核對方可施工

PROJECT MANAGER: ☐

M&E CONSULTANT: ☐

ARCHITECTURAL CONSULTANT: ☐


DESIGNER:  
**ABCONCEPT**  
All Design Limited  
1001 Leighton Road, Causeway Bay, Hong Kong  
www.abconcept.com.hk Tel: +852 2224 9191

DRAWING TITLE:  
標準樣板房  
雙床房  
立面圖


PROJECT NAME:  
中國西安  
賽高城市廣場洲際酒店

PROJECT NO:  
ABC-600  
CHECKED BY:  
ABC  
DATE:  
16-DEC-2013  
DRAWN BY:  
K.K.  
SCALE:  
A1 = 1:25  
A3 = 1:50


DWG. NO.:  
EL-005

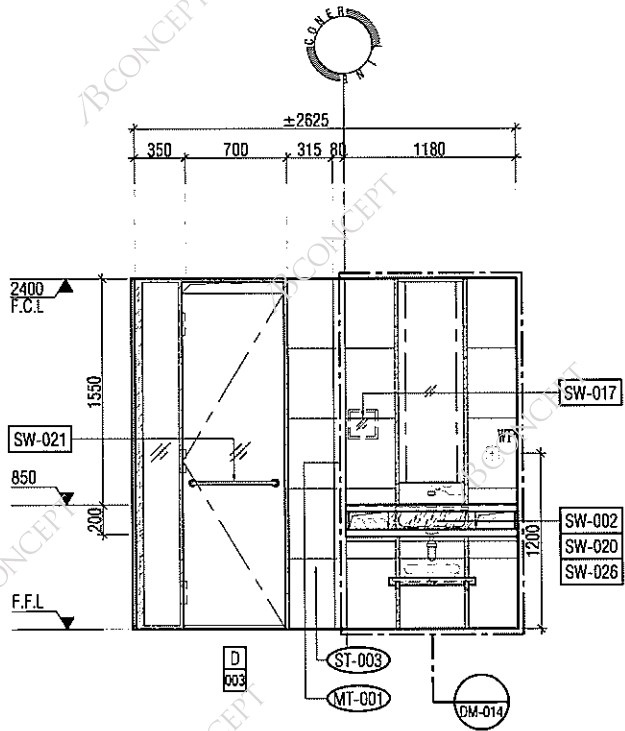


21 平面圖  
浴室 规模-1:25

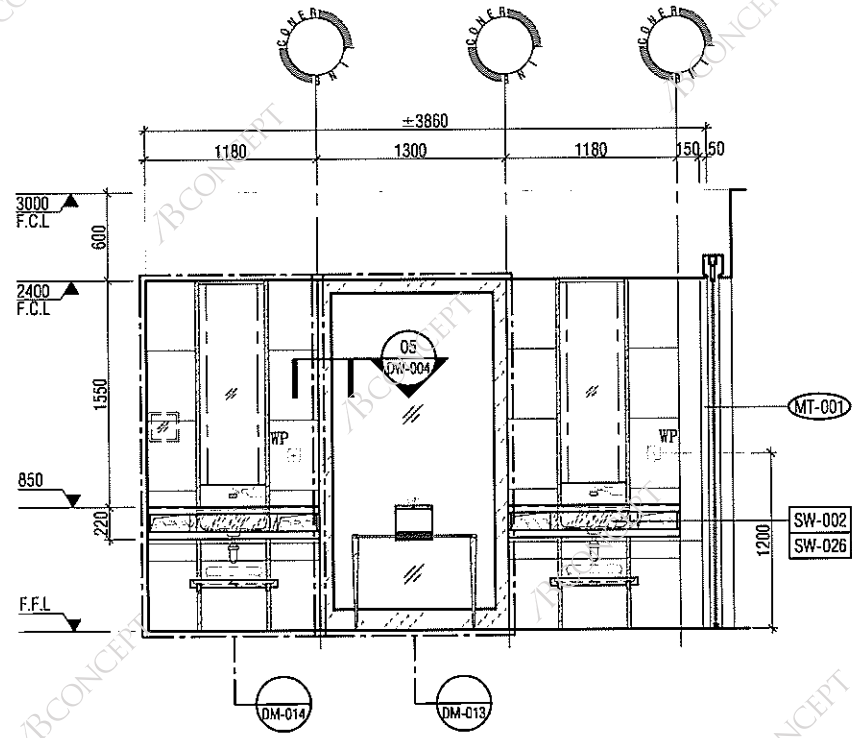

22 平面圖  
浴室 规模-1:25

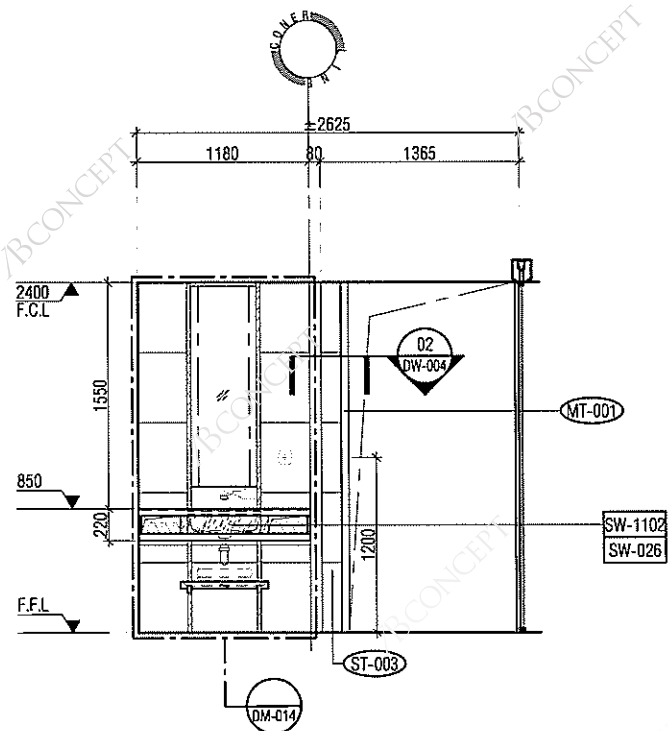

23 立面圖  
浴室 规模-1:25

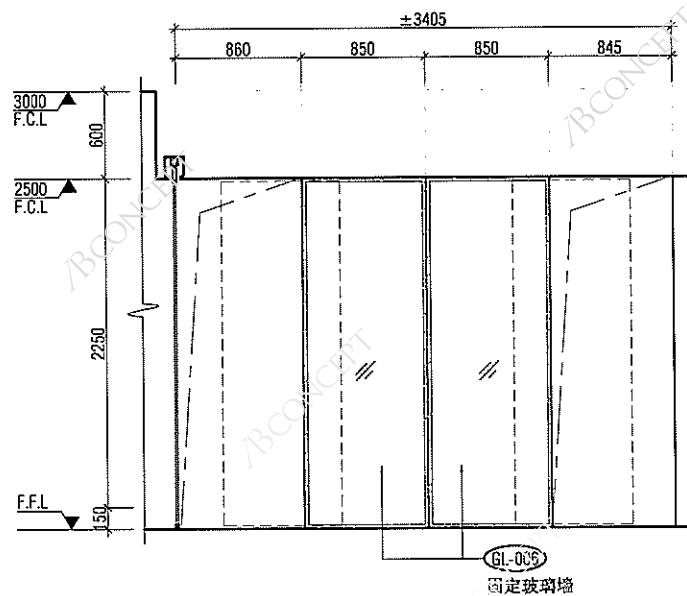

24 立面圖  
浴室 规模-1:25

NOTE:  
1. ALL DIMENSIONS MUST BE VERIFIED ON SITE BY CONSTRUCTION WORKERS.  
2. ALL DIMENSIONS MUST BE VERIFIED ON SITE BY CONSTRUCTION WORKERS.  
3. ALL DIMENSIONS MUST BE VERIFIED ON SITE BY CONSTRUCTION WORKERS.  
4. ALL DIMENSIONS MUST BE VERIFIED ON SITE BY CONSTRUCTION WORKERS.  
5. ALL DIMENSIONS MUST BE VERIFIED ON SITE BY CONSTRUCTION WORKERS.  
6. ALL DIMENSIONS MUST BE VERIFIED ON SITE BY CONSTRUCTION WORKERS.

REVISIONS NO.	DATE
1	16 DEC 2013
2	
3	
4	
5	
6	
7	
8	
9	
10	

△ 招標階段發送 16 DEC 2013  
註釋:  
-有關所有機電、燈光、隔音、影音、消防、廚房、結構、保安、升降機、建築、外牆及牆面設計, 請參考有關圖則及專家提供之詳圖及資料  
-施工單位  
-施工單位必須提交施工圖及樣板予設計師審閱方可施工

PROJECT MANAGER ☐

MSE CONSULTANT ☐

ARCHITECTURAL CONSULTANT ☐

DESIGNER  
**BCONCEPT**  
All Concept Limited  
107 Lantau Centre, Cheung Kong, Hong Kong  
香港新界大埔區中心107樓  
Tel: +852 2622 2222 Fax: +852 2622 2222

DRAWING TITLE:  
標準樣板房  
雙床房浴室  
立面圖

PROJECT NAME  
中國西安  
賽高城市廣場洲際酒店

PROJECT NO.  
ABC-600


CHECKED BY  
ABC

DATE  
16-DEC-2013


DRAWN BY  
K.K.

SCALE  
A1 = 1:25  
A3 = 1:50


DWG. NO.  
EL-006

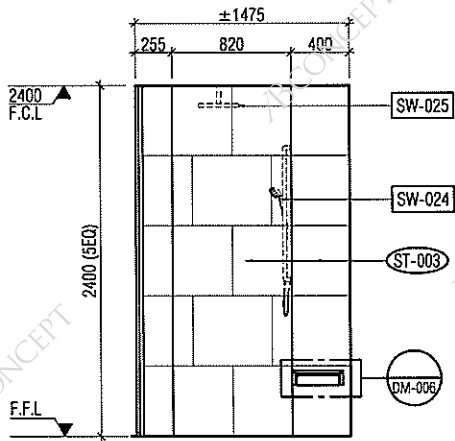


25 平面圖  
浴室 规模- 1:25

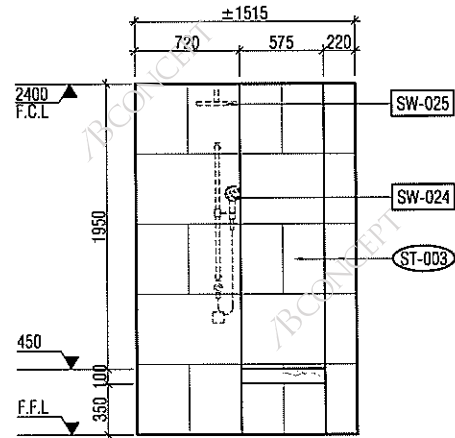

26 平面圖  
浴室 规模- 1:25

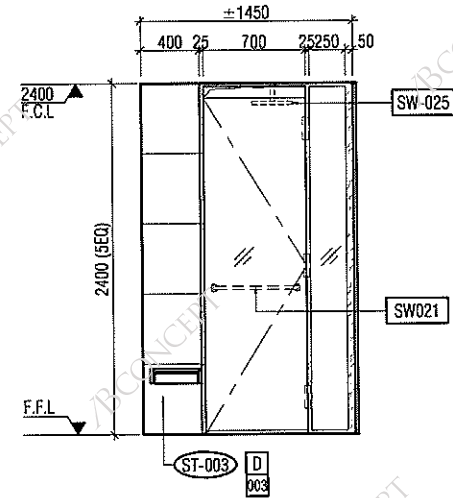

27 立面圖  
浴室 规模- 1:25

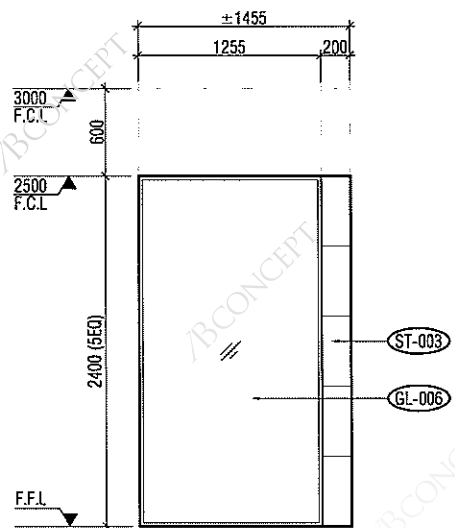

28 立面圖  
浴室 规模- 1:25

NOTE:  
1. ALL DIMENSIONS SHALL BE VERIFIED ON SITE BY CONSTRUCTION BEFORE PROCEEDING WITH CONSTRUCTION.  
2. ALL DIMENSIONS SHALL BE VERIFIED ON SITE BY CONSTRUCTION BEFORE PROCEEDING WITH CONSTRUCTION.  
3. ALL DIMENSIONS SHALL BE VERIFIED ON SITE BY CONSTRUCTION BEFORE PROCEEDING WITH CONSTRUCTION.  
4. ALL DIMENSIONS SHALL BE VERIFIED ON SITE BY CONSTRUCTION BEFORE PROCEEDING WITH CONSTRUCTION.  
5. ALL DIMENSIONS SHALL BE VERIFIED ON SITE BY CONSTRUCTION BEFORE PROCEEDING WITH CONSTRUCTION.  
6. ALL DIMENSIONS SHALL BE VERIFIED ON SITE BY CONSTRUCTION BEFORE PROCEEDING WITH CONSTRUCTION.  
7. ALL DIMENSIONS SHALL BE VERIFIED ON SITE BY CONSTRUCTION BEFORE PROCEEDING WITH CONSTRUCTION.  
8. ALL DIMENSIONS SHALL BE VERIFIED ON SITE BY CONSTRUCTION BEFORE PROCEEDING WITH CONSTRUCTION.




REVISIONS	DATE
1	16 DEC 2013
2	
3	
4	
5	
6	
7	
8	
9	
10	

△ 招標階段發送  
註釋:  
-有關所有機電、燈光、隔音、影音、消防、廚房、結構、保安、升降機、建築、外牆及屋頂設計, 請參考有關圖則及專家提供之詳圖及資料  
-施工單位  
-施工單位必須提交施工圖及樣板予設計師過目方可施工

PROJECT MANAGER ☐  
MSE CONSULTANT ☐  
ARCHITECTURAL CONSULTANT ☐

DESIGNER:  
**BCONCEPT**  
44 Street View  
1401 Lantau Island, Cheung Chau, Hong Kong  
電話: 2361 0000  
傳真: 2361 0001  
WWW.BCONCEPT.COM  
DRAWING TITLE:  
標準樣板房  
雙床沐浴間  
立面圖

   PROJECT NAME:  
中國西安  
賽高城市廣場洲際酒店  
PROJECT NO:  
ABC - 600  
CHECKED BY:  
ABC  
DRAWN BY:  
K.K.  
DATE:  
16-DEC-2013  
SCALE:  
A1 = 1:25  
A3 = 1:50  
DWG NO:  
EL-007



- [illegible]

<b>△ 招標階段發送</b>	<b>16 DEC 2013</b>
<b>註釋:</b> 有關所有機電、燈光、隔音、影音、消防、廚房、結構、保安、升降機、建築、外牆及牆型設計，請參考有關顧問及專家提供之詳圖及資料 <b>-施工單位</b> 施工單位必須提交施工圖方及樣板予設計師核對方可施工	

PROJECT MANAGER: \_\_\_\_\_

MSE CONSULTANT

ARCHITECTURAL CONSULTANT

DESIGNER:

**B CONCEPT**

A.B. CONCEPT LIMITED  
13011 Lighthorse Square, Coomaraswamy, Hong Kong  
TEL: 3433 8888 FAX: 3433 4511  
E-MAIL: [info@abconcept.com.hk](mailto:info@abconcept.com.hk) WWW: [www.abconcept.com.hk](http://www.abconcept.com.hk)

DRAWING TITLE :  
 天花大樣圖

PROJECT NAME: \_\_\_\_\_  
 T 30 4 38

 
 
 
中國西安  
賽高城市廣場洲際酒店

PROJECT NO. ABC-600

CHECKED BY: R. B. ABC	DRAWN BY: S. J. S.J.
--------------------------	-------------------------

DATE (15)	SCALE U.P.
16-DEC-2013	A1 = 1:2 A3 = 1:4

DWG NO: DC-001 A



- [illegible]

註釋：  
一有關所有電機、燈光、隔音、影音、消防、廚房、結構、保安、升降機、通風、外牆及雕塑設計，請參考有關顧問及專家提供之詳圖及資料

—施工單位  
—該工程單位必須製交施工圖及樓板予設計師核覆方可施工

PROJECT MANAGER:

M&amp;E CONSULTANT:

ARCHITECTURAL CONSULTANT:

DESIGNER



**AB CONCEPT**

  AB Concept Limited  
1621 Unifirst Centre, Colindale Ave, Hong Kong  
Tel: +852 2418 8141 Fax: +852 2418 8142  
Web: [www.abconcept.hk](http://www.abconcept.hk) Tel: +852 2222 0029

DRAWING TITLE:  
図名  
天花大様圖

PROJECT NAME  
工程名稱  
中國西安  
賽高城市廣場洲際酒店

PROJECT NO. 工程編號		ABC-600
CHECKED BY 校核	ABC	DRAWN BY 繪製
DATE 日期	16-DEC-2013	SCALE 比例
		A1 = AS SHOWN
DWG NO. 圖號		DC-002



- [illegible]

註釋:

有關所有機電、燈光、隔音、影音、消防、廚房、結構、保安、升降機、建築、外牆及雕塑設計，請參考有關顧問及專家提供之詳圖及資料。

- 施工單位
- 施工單位必須提交施工圖及樓板予設計師面議方可施工

---

PROJECT MANAGER:

M&amp;E CONSULTANT

ARCHITECTURAL CONSULTANT:

DESIGNER:

**ABCONCEPT**  
All Concept Limited  
14011 Lightstar Centre, Gasimay Bay, Hong Kong  
香港將軍澳光星中心 14011室  
web: [www.abconcept.hk](http://www.abconcept.hk) tel: +852-55251658

DRAWING TITLE :

地台大樣圖  
FLOOR DETAILS

PROJECT NAME  
T E S T I N G

中國西安  
賽高城市廣場洲際酒店

PROJECT NO. ABC - 600

CHECKED BY: 张 伟	ABC	DRAWN BY: 陈 亮	S.T.
--------------------	-----	------------------	------

DATE	SCALE
10	A1 = 1:1

16-DEC-2013	A3 = 1:2
-------------	----------

DF-001

**TABLE 1**

**Summary of the Data Collection Process**

The following table summarizes the data collection process, showing the number of participants who completed each stage of the study.

**Participant Flow:**

- Initial sample size: 100
- Excluded due to incomplete data: 10
- Final sample size: 90

**Data Collection Stages:**

- Stage 1: Initial assessment (n = 100)
- Stage 2: Intervention phase (n = 80)
- Stage 3: Follow-up assessment (n = 70)

**Data Analysis:**

The data were analyzed using SPSS version 25.0. Descriptive statistics were calculated for all variables. Inferential statistics, including t-tests and ANOVAs, were used to compare groups and assess the significance of differences over time.

**Ethical Approval:**

The study was approved by the Institutional Review Board (IRB) at [University Name]. All participants provided informed consent before participating in the study.

**Limitations:**

The study has several limitations. First, the sample size was relatively small, which may limit the generalizability of the findings. Second, the study was conducted over a short period, which may not capture long-term effects. Third, the self-reported nature of some data may introduce bias.

**Conclusion:**

The study found that the intervention had a significant positive effect on [outcome variable]. These findings suggest that the intervention may be effective in improving [outcome variable] in this population. Further research is needed to confirm these results and explore the underlying mechanisms.

**Acknowledgments:**

We thank the participants who made this study possible. We also thank the research assistants and staff who supported the data collection process.

**Funding:**

This study was funded by [Funding Source].

**References:**

[List of references]

**Appendix A:**

[Detailed description of the intervention protocol]

**Appendix B:**

[Sample questionnaire items]

**Appendix C:**

[Statistical output tables]

**Appendix D:**

[Flowchart of participant flow]

**Appendix E:**

[Ethical approval letter excerpt]

**Appendix F:**

[Informed consent form excerpt]

**Appendix G:**

[Data management plan excerpt]

**Appendix H:**

[Data dictionary]

**Appendix I:**

[Data cleaning log]

**Appendix J:**

[Data analysis script]

**Appendix K:**

[Data visualization outputs]

**Appendix L:**

[Data storage and backup logs]

**Appendix M:**

[Data access request forms]

**Appendix N:**

[Data retention policy]

**Appendix O:**

[Data destruction procedure]

**Appendix P:**

[Data privacy statement]

**Appendix Q:**

[Data security measures]

**Appendix R:**

[Data quality assurance procedures]

**Appendix S:**

[Data documentation standards]

**Appendix T:**

[Data governance framework]

**Appendix U:**

[Data lifecycle management plan]

**Appendix V:**

[Data impact assessment report]

**Appendix W:**

[Data transparency report]

**Appendix X:**

[Data accountability report]

**Appendix Y:**

[Data ethics review report]

**Appendix Z:**

[Data compliance report]

**Appendix AA:**

[Data audit trail]

**Appendix AB:**

[Data breach response plan]

**Appendix AC:**

[Data incident response plan]

**Appendix AD:**

[Data recovery plan]

**Appendix AE:**

[Data disaster recovery plan]

**Appendix AF:**

[Data business continuity plan]

**Appendix AG:**

[Data resilience plan]

**Appendix AH:**

[Data risk management plan]

**Appendix AI:**

[Data threat intelligence report]

**Appendix AJ:**

[Data vulnerability assessment report]

**Appendix AK:**

[Data penetration test report]

**Appendix AL:**

[Data security audit report]

**Appendix AM:**

[Data compliance audit report]

**Appendix AN:**

[Data privacy audit report]

**Appendix AO:**

[Data security certification report]

**Appendix AP:**

[Data privacy certification report]

**Appendix AQ:**

[Data security assessment report]

**Appendix AR:**

[Data privacy assessment report]

**Appendix AS:**

[Data security evaluation report]

**Appendix AT:**

[Data privacy evaluation report]

**Appendix AU:**

[Data security improvement plan]

**Appendix AV:**

[Data privacy improvement plan]

**Appendix AW:**

[Data security training module]

**Appendix AX:**

[Data privacy training module]

**Appendix AY:**

[Data security awareness campaign]

**Appendix AZ:**

[Data privacy awareness campaign]

**Appendix BA:**

[Data security policy document]

**Appendix BB:**

[Data privacy policy document]

**Appendix BC:**

[Data security standard document]

**Appendix BD:**

[Data privacy standard document]

**Appendix BE:**

[Data security guideline document]

**Appendix BF:**

[Data privacy guideline document]

**Appendix BG:**

[Data security best practice document]

**Appendix BH:**

[Data privacy best practice document]

**Appendix BI:**

[Data security checklist document]

**Appendix BJ:**

[Data privacy checklist document]

**Appendix BK:**

[Data security template document]

**Appendix BL:**

[Data privacy template document]

**Appendix BM:**

[Data security form document]

**Appendix BN:**

[Data privacy form document]

**Appendix BO:**

[Data security agreement document]

**Appendix BP:**

[Data privacy agreement document]

**Appendix BQ:**

[Data security disclaimer document]

**Appendix BR:**

[Data privacy disclaimer document]

**Appendix BS:**

[Data security waiver document]

**Appendix BT:**

[Data privacy waiver document]

**Appendix BU:**

[Data security release form document]

**Appendix BV:**

[Data privacy release form document]

**Appendix BW:**

[Data security acknowledgment document]

**Appendix BX:**

[Data privacy acknowledgment document]

**Appendix BY:**

[Data security confirmation document]

**Appendix BZ:**

[Data privacy confirmation document]

**Appendix CA:**

[Data security notification document]

**Appendix CB:**

[Data privacy notification document]

**Appendix CC:**

[Data security alert document]

**Appendix CD:**

[Data privacy alert document]

**Appendix CE:**

[Data security warning document]

**Appendix CF:**

[Data privacy warning document]

**Appendix CG:**

[Data security notice document]

**Appendix CH:**

[Data privacy notice document]

**Appendix CI:**

[Data security announcement document]

**Appendix CJ:**

[Data privacy announcement document]

**Appendix CK:**

[Data security press release document]

**Appendix CL:**

[Data privacy press release document]

**Appendix CM:**

[Data security media kit document]

**Appendix CN:**

[Data privacy media kit document]

**Appendix CO:**

[Data security FAQ document]

**Appendix CP:**

[Data privacy FAQ document]

**Appendix CQ:**

[Data security glossary document]

**Appendix CR:**

[Data privacy glossary document]

**Appendix CS:**

[Data security terminology document]

**Appendix CT:**

[Data privacy terminology document]

**Appendix CU:**

[Data security definitions document]

**Appendix CV:**

[Data privacy definitions document]

**Appendix CW:**

[Data security acronyms document]

**Appendix CX:**

[Data privacy acronyms document]

**Appendix CY:**

[Data security abbreviations document]

**Appendix CZ:**

[Data privacy abbreviations document]

**Appendix DA:**

[Data security symbols document]

**Appendix DB:**

[Data privacy symbols document]

**Appendix DC:**

[Data security icons document]

**Appendix DD:**

[Data privacy icons document]

**Appendix DE:**

[Data security logos document]

**Appendix DF:**

[Data privacy logos document]

**Appendix DG:**

[Data security branding document]

**Appendix DH:**

[Data privacy branding document]

**Appendix DI:**

[Data security visual identity document]

**Appendix DJ:**

[Data privacy visual identity document]

**Appendix DK:**

[Data security style guide document]

**Appendix DL:**

[Data privacy style guide document]

**Appendix DM:**

[Data security design system document]

**Appendix DN:**

[Data privacy design system document]

**Appendix DO:**

[Data security user interface document]

**Appendix DP:**

[Data privacy user interface document]

**Appendix DQ:**

[Data security user experience document]

**Appendix DR:**

[Data privacy user experience document]

**Appendix DS:**

[Data security usability testing document]

**Appendix DT:**

[Data privacy usability testing document]

**Appendix DU:**

[Data security accessibility document]

**Appendix DV:**

[Data privacy accessibility document]

**Appendix DW:**

[Data security localization document]

**Appendix DX:**

[Data privacy localization document]

**Appendix DY:**

[Data security internationalization document]

**Appendix DZ:**

[Data privacy internationalization document]

**Appendix EA:**

[Data security translation document]

**Appendix EB:**

[Data privacy translation document]

**Appendix EC:**

[Data security proofreading document]

**Appendix ED:**

[Data privacy proofreading document]

**Appendix EE:**

[Data security editing document]

**Appendix EF:**

[Data privacy editing document]

**Appendix EG:**

[Data security formatting document]

**Appendix EH:**

[Data privacy formatting document]

**Appendix EI:**

[Data security layout document]

**Appendix EJ:**

[Data privacy layout document]

**Appendix EK:**

[Data security typesetting document]

**Appendix EL:**

[Data privacy typesetting document]

**Appendix EM:**

[Data security printing document]

**Appendix EN:**

[Data privacy printing document]

**Appendix EO:**

[Data security distribution document]

**Appendix EP:**

[Data privacy distribution document]

**Appendix EQ:**

[Data security archiving document]

**Appendix ER:**

[Data privacy archiving document]

**Appendix ES:**

[Data security backup document]

**Appendix ET:**

[Data privacy backup document]

**Appendix EU:**

[Data security restoration document]

**Appendix EV:**

[Data privacy restoration document]

**Appendix EW:**

[Data security recovery document]

**Appendix EX:**

[Data privacy recovery document]

**Appendix EY:**

[Data security disaster recovery document]

**Appendix EZ:**

[Data privacy disaster recovery document]

**Appendix FA:**

[Data security business continuity document]

**Appendix FB:**

[Data privacy business continuity document]

**Appendix FC:**

[Data security resilience document]

**Appendix FD:**

[Data privacy resilience document]

**Appendix FE:**

[Data security risk management document]

**Appendix FF:**

[Data privacy risk management document]

**Appendix FG:**

[Data security threat intelligence document]

**Appendix FH:**

[Data privacy threat intelligence document]

**Appendix FI:**

[Data security vulnerability assessment document]

**Appendix FJ:**

[Data privacy vulnerability assessment document]

**Appendix FK:**

[Data security penetration test document]

**Appendix FL:**

[Data privacy penetration test document]

**Appendix FM:**

[Data security security audit document]

**Append**

