 

[illegible]

 
 
DWM-001 Z

DWM-001 Z






一施工單位必須提交施工圖及樣板予設計師
繪圖方可施工

DWG NO: DW-002 



- | | |
|--|--------------------|
| △ 招標階段發送 | 18 DEC 2013 |
| 註釋:
一所有所有電機、燈光、隔音、影音、消防、廚房、結構、保安、升降機、建築、外牆及牆壁設計，請參考有關顧問及專家提供之詳圖及資料
一施工單位
一施工單位必須提交施工圖及樣板予設計師審閱方可施工 | |

   DW-003 



- 施工單位必須提交施工圖及樣板予設計師
確認方可施工

DW-004

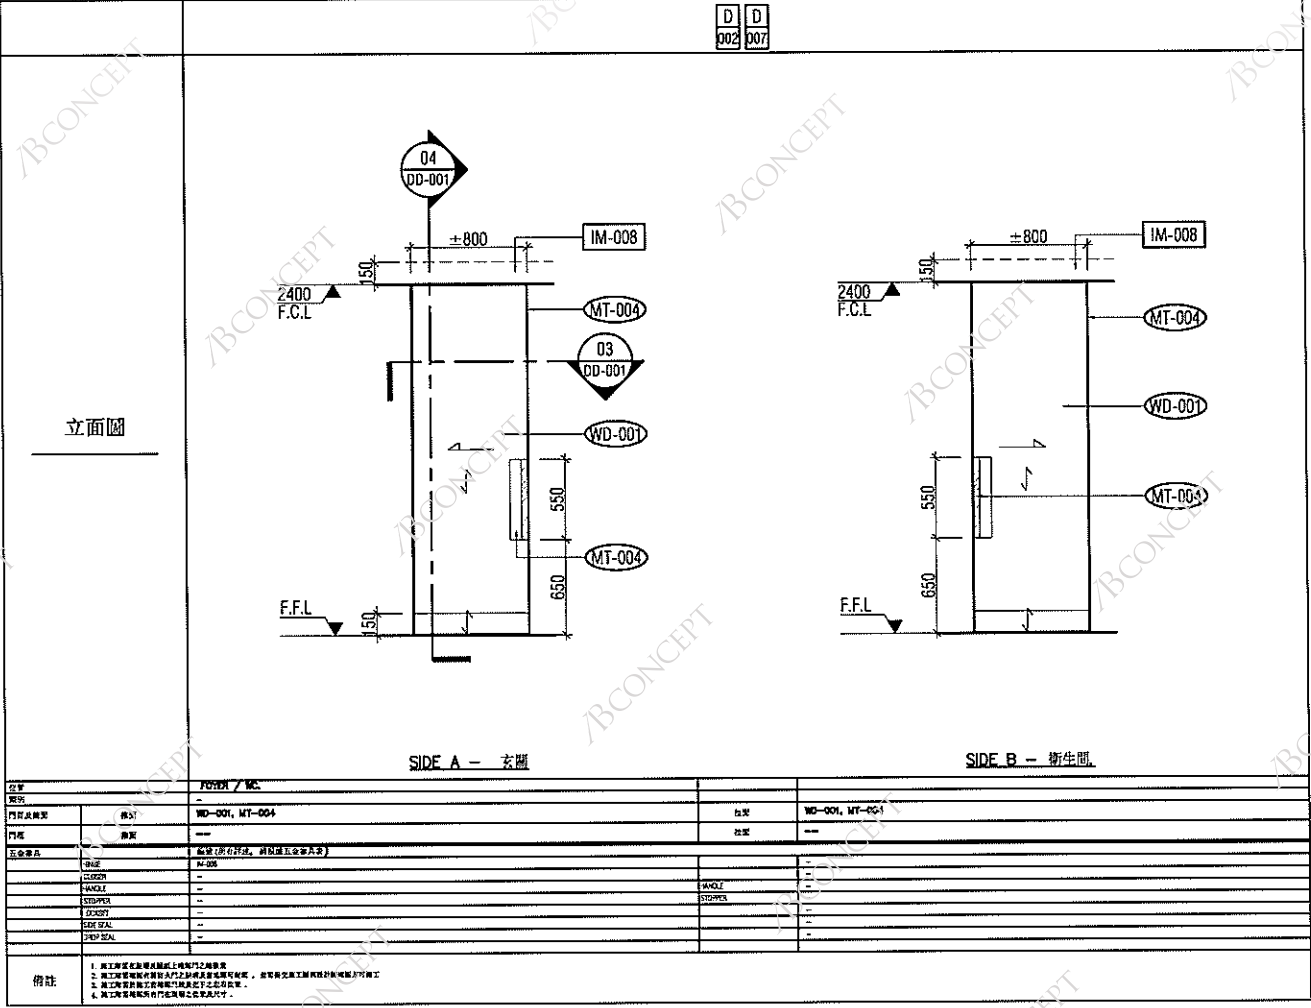
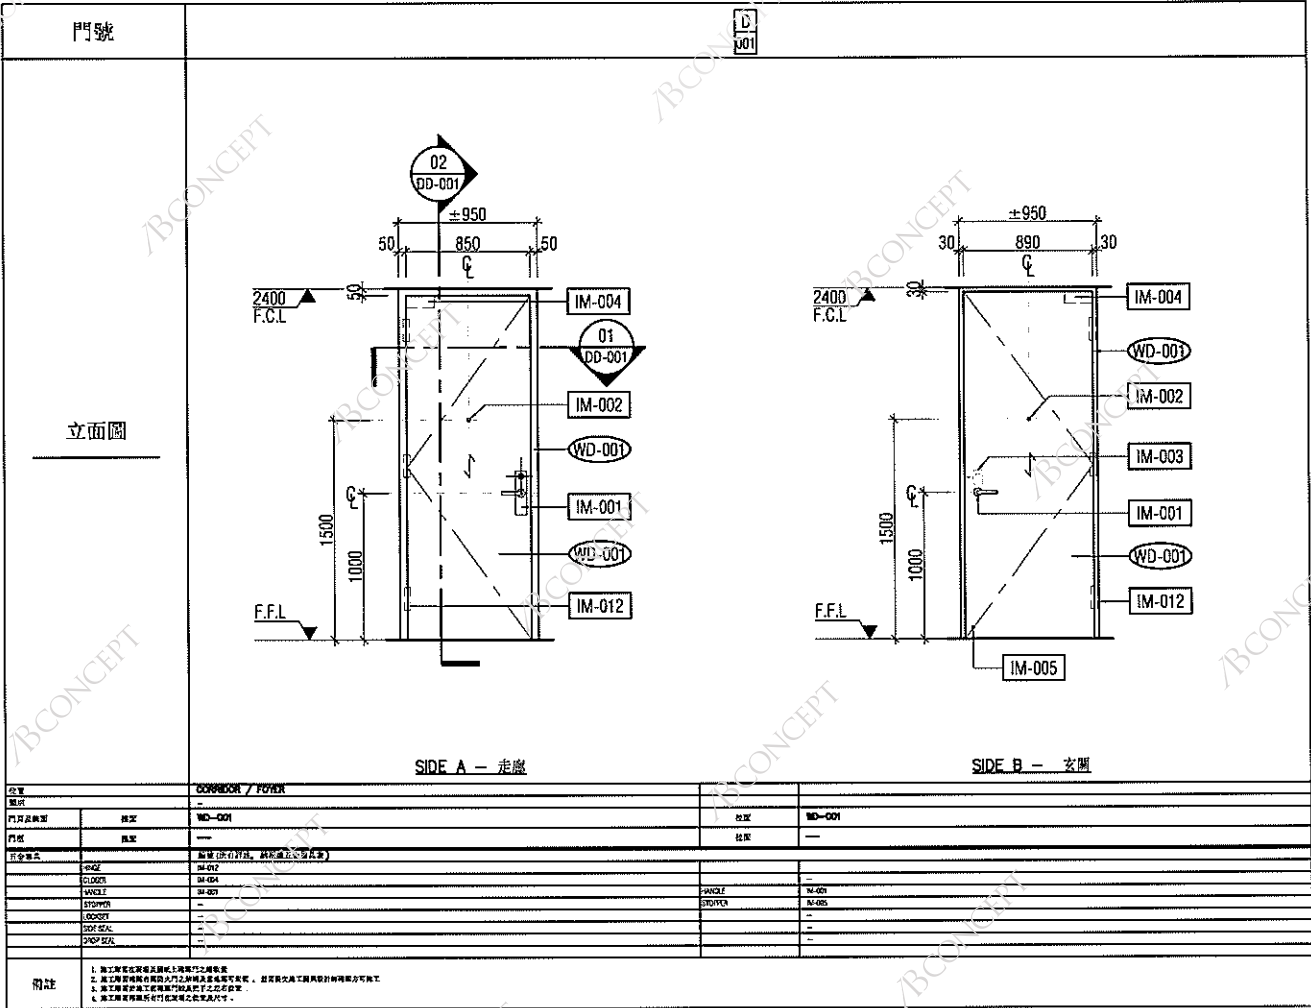


Table with 2 columns: REVISIONS and DATE. It contains a list of revisions and the date 18 DEC 2013.

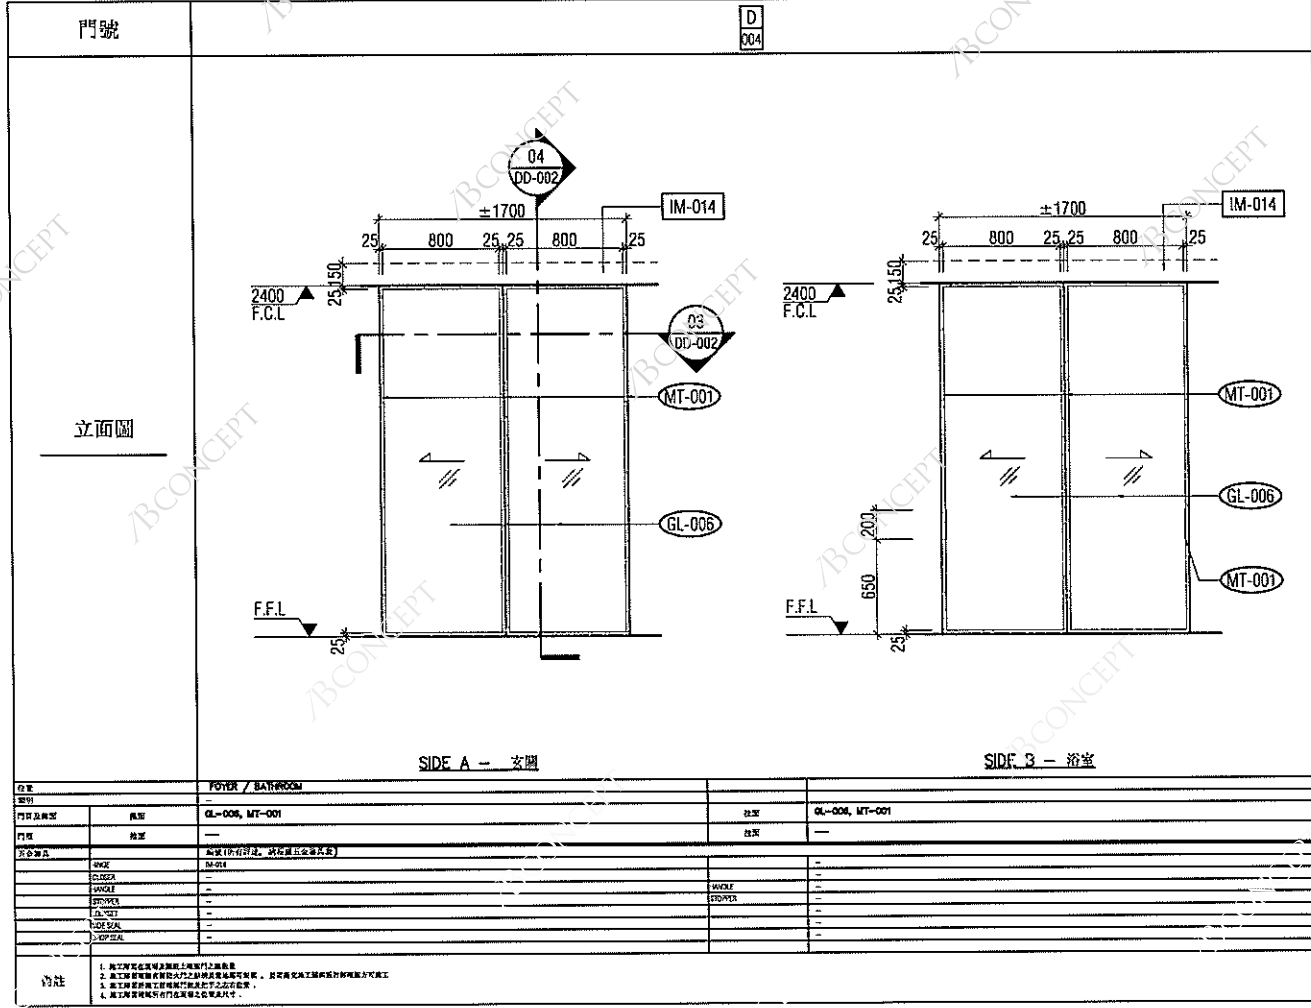
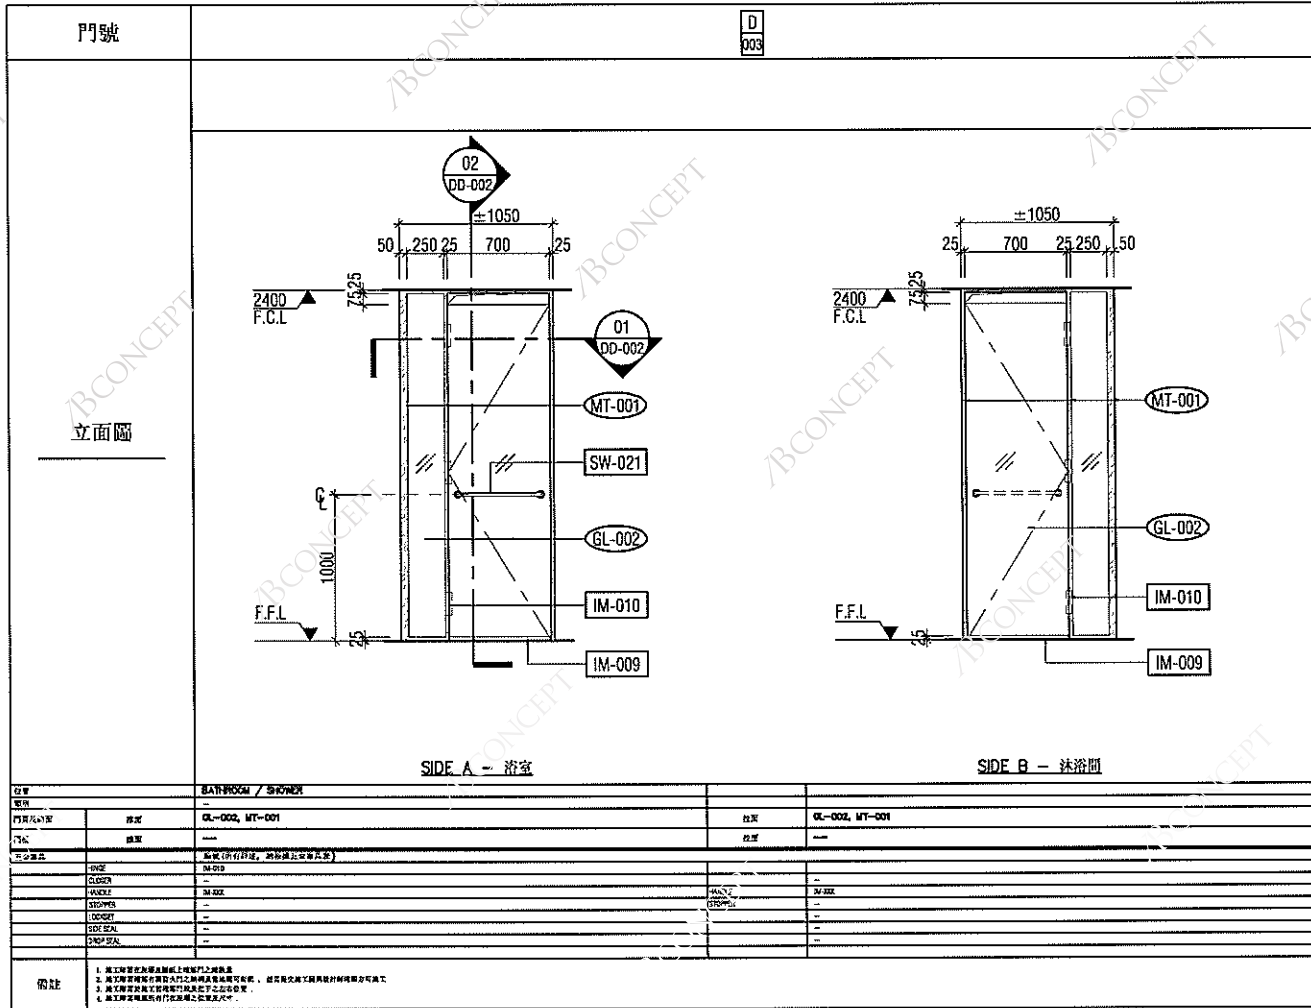
 
 
 
 
 


Table with 2 columns: PROJECT NAME and PROJECT NO. It contains the project name '中國西安 賽高城市廣場洲際酒店' and the project number 'ABC-500'.

[illegible]

△ 招標階段發送	18 DEC 2011
<p>註釋:</p> <p>-有關所有機電、燈光、隔音、影音、消防、廚房、結構、保安、升降機、建築、水及暖氣設計，請參考有關顧問及專家提供的詳圖及資料</p> <p>-施工單位</p> <p>-施工單位必須提交施工圖及樓板予設計工程師方可施工</p>	

PROJECT MANAGER

M&E CONSULTANTS

ARCHITECTURAL CONSULTANT:

DESIGNER:

BCONCEPT

AS Concept Limited
1821 Leighton Centre, Coleman Bay, Hong Kong
香港利源中心1821室
tel. 9098 8000 / fax 9098 8008

DRAWING TITLE:
圖 名
標準樣板房
門大樣圖

PROJECT NAME 工程名稱	
中國西安 賽高城市廣場洲際酒店	
PROJECT NO. 工程編號	
ABC-600	
CHECKED BY: 校核	DRAWING BY: 繪圖
ABC	S.T.
DATE 日期	SCALE 比例
17-DEC-2013	A1= AS SH
DWG NO: 圖號	
DD-001	

[illegible]

註釋:
-有關所有機電、燈光、隔音、影音、消防、廚房、紙梯、保安、升降機、建築、外牆及牆面設計,請參考有關顧問及專家提供之詳圖及資料

-施工單位

-施工單位必須裝設施工圍及樣板予設計師監閱方可施工

PROJECT MANAGER: _____

M&E CONSULTANT

ARCHITECTURAL CONSULTANT:

DESIGNER:
BCONCEPT
B Concept Limited
187 Leighton Centre, Gateway Way, Hong Kong
香港新城市廣場中心 187 樓
tel: 994 4869/9111 fax: 994 4559/9109

DRAWING TITLE:
圖 名
標準樣板房
門大樣圖

PROJECT NAME: _____
[87 1 09]

中國西安
賽高城市廣場洲際酒店

PROJECT NO
7 在 0 5 ABC - 600


CHECKED BY:	DRAWN BY:
ABC	ST

DATE	SCALE
------	-------


17-DEC-2013 A1 = AS SHOT

DD-002 A


DD-002 7-64

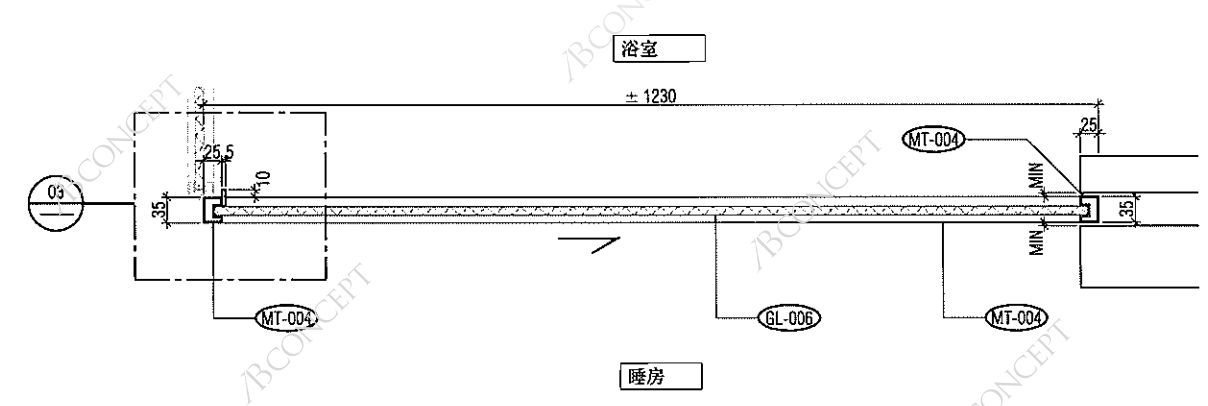

01 平剖面
D-005 规模- 1:5

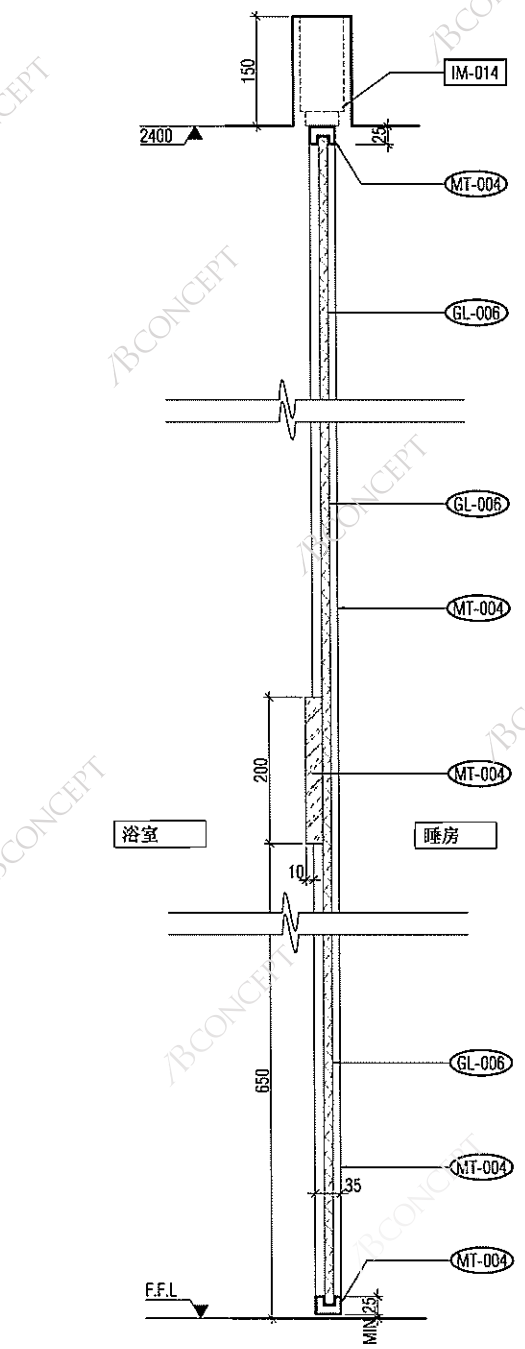

02 直剖面
D-005 规模- 1:5

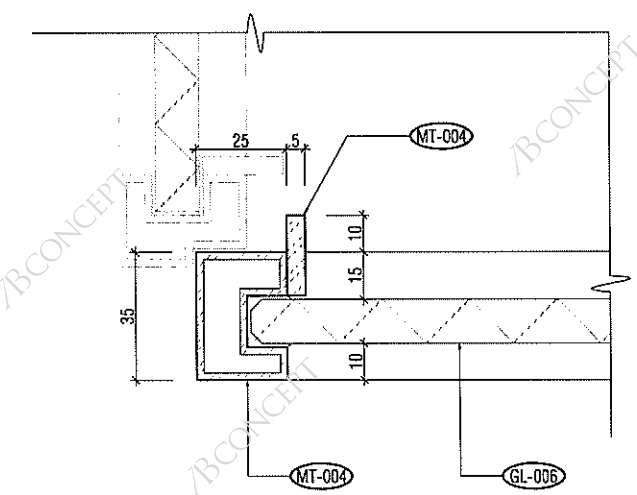

03 大樣圖
D-005 规模- 1:1

NOTE

1. DO NOT SCALE DRAWINGS

2. ALL DIMENSIONS MUST BE CHECKED ON SITE BY CONTRACTOR BEFORE PROCEEDING WITH CONSTRUCTION

3. CONTRACTOR SHALL BE RESPONSIBLE FOR OBTAINING ALL NECESSARY PERMITS AND APPROVALS FROM THE RELEVANT AUTHORITIES

4. CONTRACTOR SHALL BE RESPONSIBLE FOR OBTAINING ALL NECESSARY PERMITS AND APPROVALS FROM THE RELEVANT AUTHORITIES

5. CONTRACTOR SHALL BE RESPONSIBLE FOR OBTAINING ALL NECESSARY PERMITS AND APPROVALS FROM THE RELEVANT AUTHORITIES

6. CONTRACTOR SHALL BE RESPONSIBLE FOR OBTAINING ALL NECESSARY PERMITS AND APPROVALS FROM THE RELEVANT AUTHORITIES

7. CONTRACTOR SHALL BE RESPONSIBLE FOR OBTAINING ALL NECESSARY PERMITS AND APPROVALS FROM THE RELEVANT AUTHORITIES

8. CONTRACTOR SHALL BE RESPONSIBLE FOR OBTAINING ALL NECESSARY PERMITS AND APPROVALS FROM THE RELEVANT AUTHORITIES

9. CONTRACTOR SHALL BE RESPONSIBLE FOR OBTAINING ALL NECESSARY PERMITS AND APPROVALS FROM THE RELEVANT AUTHORITIES

10. CONTRACTOR SHALL BE RESPONSIBLE FOR OBTAINING ALL NECESSARY PERMITS AND APPROVALS FROM THE RELEVANT AUTHORITIES

REVISIONS NO.	DATE
1	18 DEC 2013

招標階段發送

18 DEC 2013

註釋:

-有關所有機電、燈光、隔音、影音、消防、廚房、結構、保安、升降機、建築、外牆及牆面設計，請參考有關顧問及專家提供之詳圖及資料

-施工單位

-施工單位必須與交施圖及樣板予設計師，經認可方可施工

PROJECT MANAGER

M&E CONSULTANT

ARCHITECTURAL CONSULTANT

DESIGNER

BCONCEPT

All Concept Limited
1101 Lippo Centre, Canton Road, Hong Kong
香港中環皇后大道中1101號
電話: 2828 2222

DRAWING TITLE:

標準樣板房
門大樣圖

PROJECT NAME:

中國西安
賽高城市廣場洲際酒店

PROJECT NO:

ABC - 600

CHECKED BY:

ABC

DRAWN BY:

U.A.

DATE:

 
17-DEC-2013

SCALE:

A1 = AS SHOW

DWG NO:

DD-003




△ 招標階段發送 18 DEC 2013


註釋:

- 有關所有機電、燈光、隔音、影音、消防、廚房、電梯、保安、升降機、建築、外牆及雕塑設計，請參考有關顧問及專家提供之詳圖及資料
- 施工單位
- 施工單位必須提交施工圖及樣板予設計師確認方可施工


ARCHITECTURAL CONSULTANT:DD-004

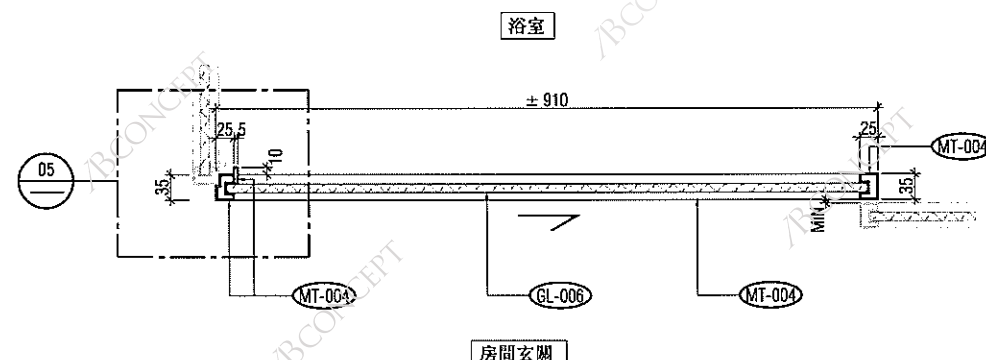


01 平剖面
D-009 规模-1:5

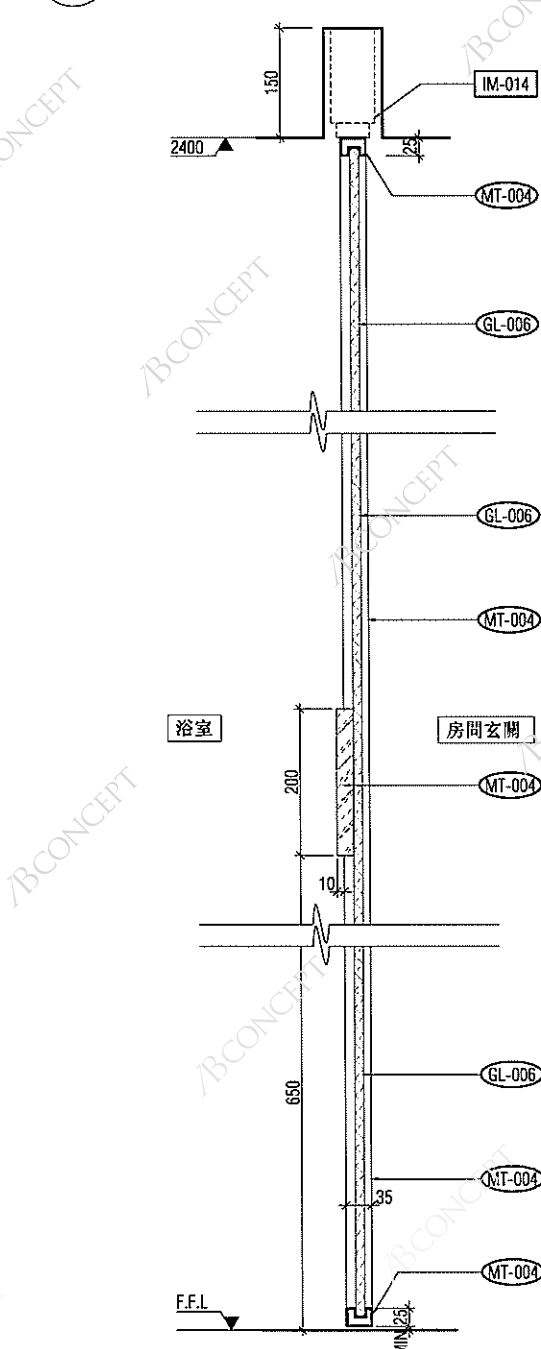


02 直剖面
D-009 规模-1:5

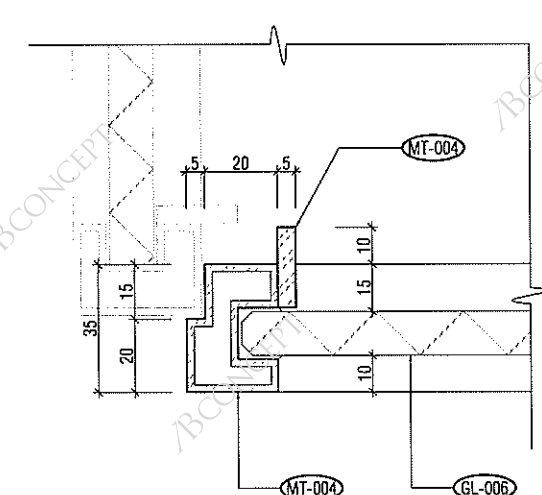


05 DETAILS
D-009 规模-1:1

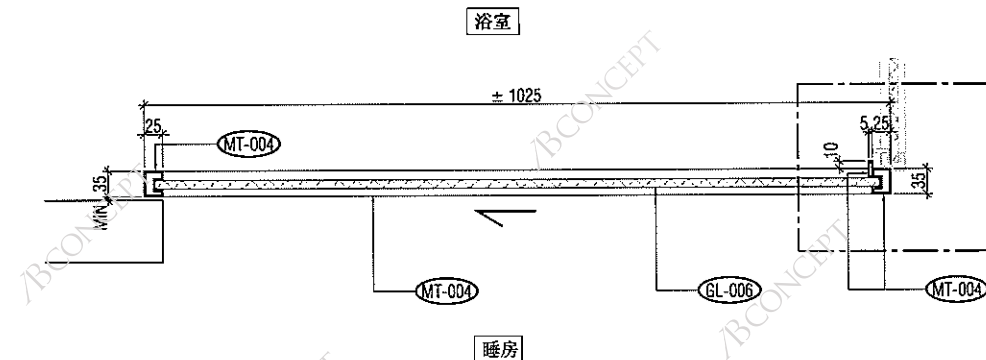

03 平剖面
D-010 规模-1:5

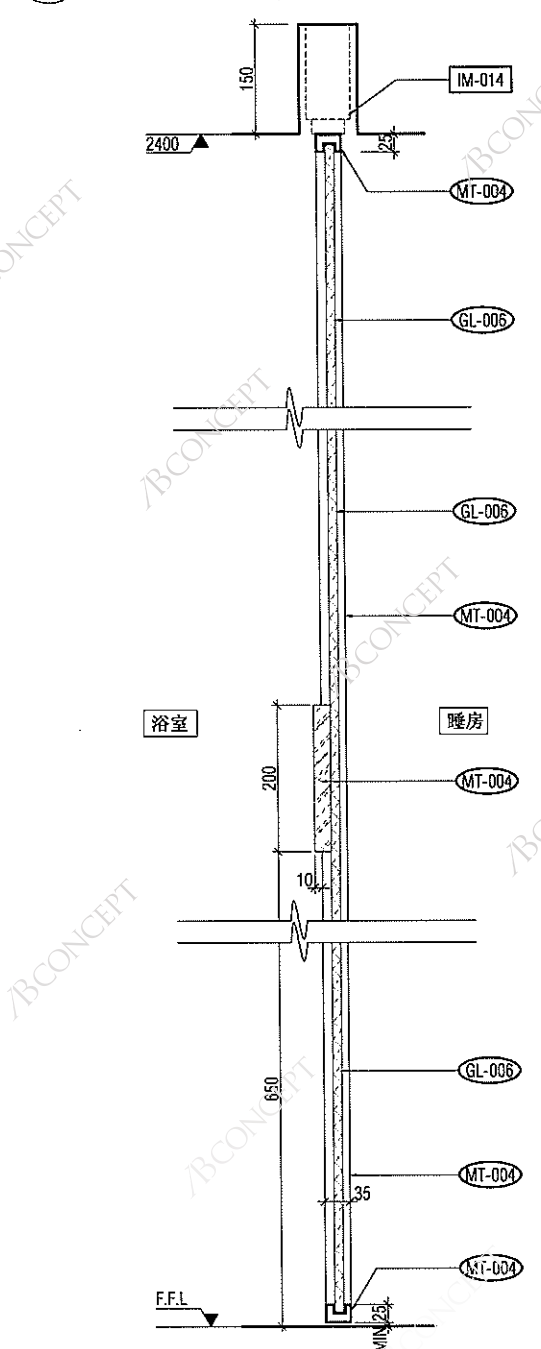

04 直剖面
D-010 规模-1:5

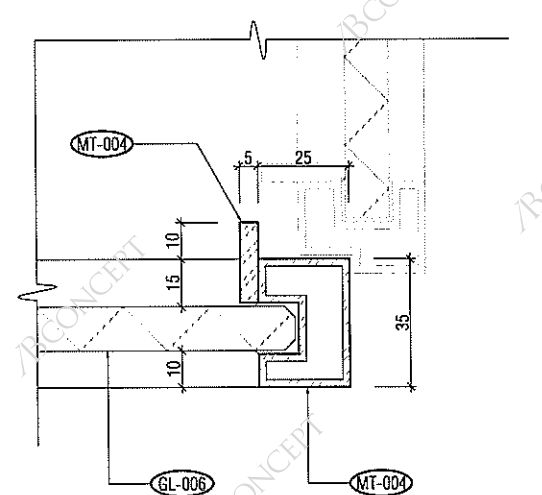

06 DETAILS
D-010 规模-1:1

NOTE:
1. ALL WORK SHALL BE DONE IN ACCORDANCE WITH THE SPECIFICATIONS AND STANDARDS OF THE CONTRACTOR.
2. ALL WORK SHALL BE DONE IN ACCORDANCE WITH THE SPECIFICATIONS AND STANDARDS OF THE CONTRACTOR.
3. ALL WORK SHALL BE DONE IN ACCORDANCE WITH THE SPECIFICATIONS AND STANDARDS OF THE CONTRACTOR.
4. ALL WORK SHALL BE DONE IN ACCORDANCE WITH THE SPECIFICATIONS AND STANDARDS OF THE CONTRACTOR.
5. ALL WORK SHALL BE DONE IN ACCORDANCE WITH THE SPECIFICATIONS AND STANDARDS OF THE CONTRACTOR.
6. ALL WORK SHALL BE DONE IN ACCORDANCE WITH THE SPECIFICATIONS AND STANDARDS OF THE CONTRACTOR.

REVISIONS	DATE
1	18 DEC 2013

△ 招標階段發送

註冊:
-有關所有機電、燈光、隔音、影音、消防、廚房、結構、保安、升降機、建築、外牆及屋頂設計，請參考有關圖則及專家提供之詳圖及資料。
-施工單位
-施工單位必須提交施工圖及樣板予設計師核對方可施工。

PROJECT MANAGER: ☐

ME CONSULTANT: ☐

ARCHITECTURAL CONSULTANT: ☐

DESIGNER:
BCONCEPT
401-402, 403, 404, 405, 999, 1000.

DRAWING TITLE:
標準樣板房
門大樣圖

PROJECT NAME:
中國西安
賽高城市廣場洲際酒店


PROJECT NO:
ABC - 600

CHECKED BY:
ABC


DATE:
17-DEC-2013

DWG. NO.:
DD-005


SCALE:
A1 = AS SHOWN

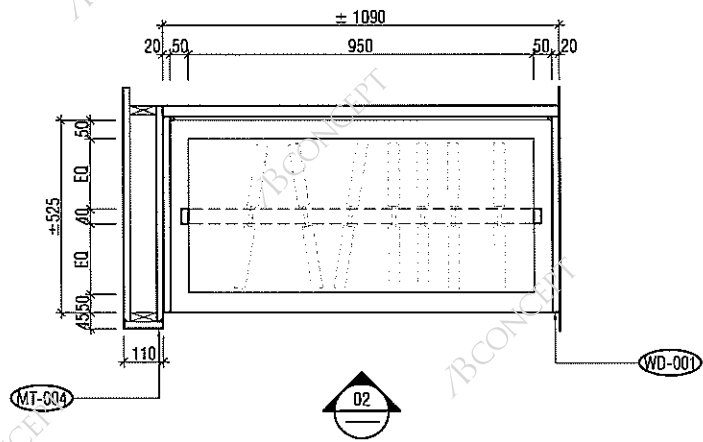


01 平面圖
规模-1:10

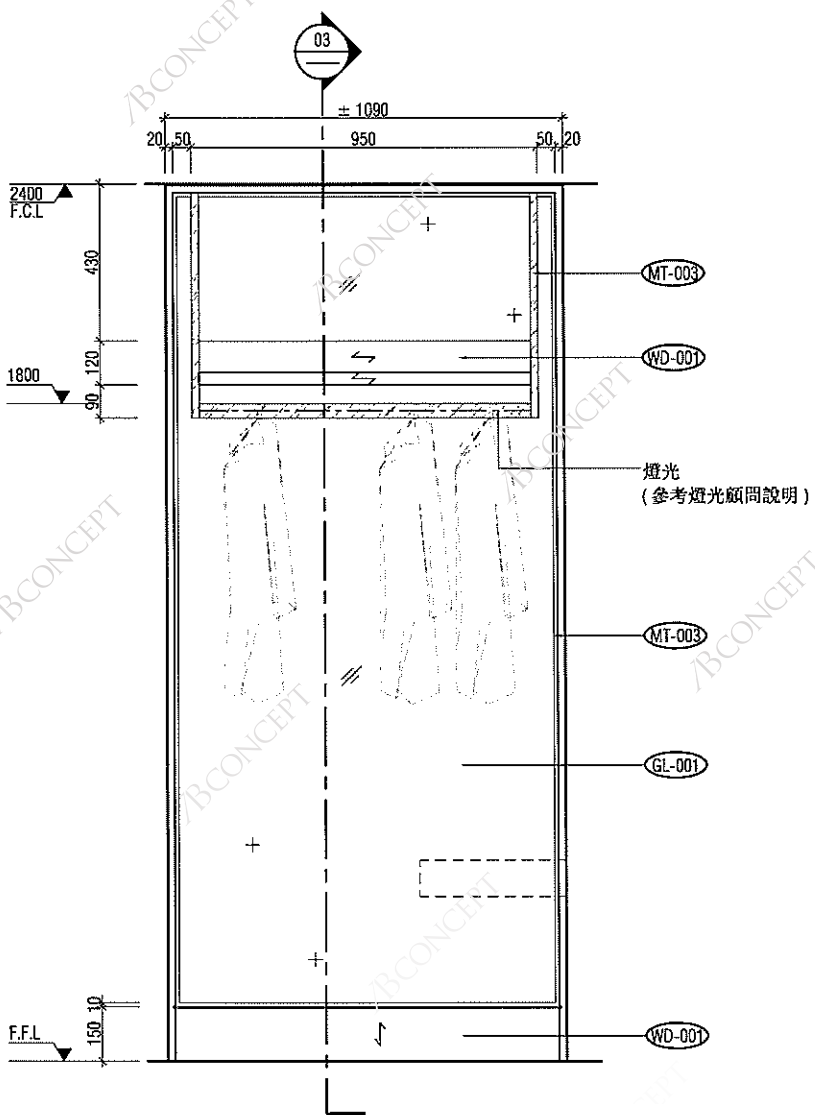


02 立面圖
规模-1:10

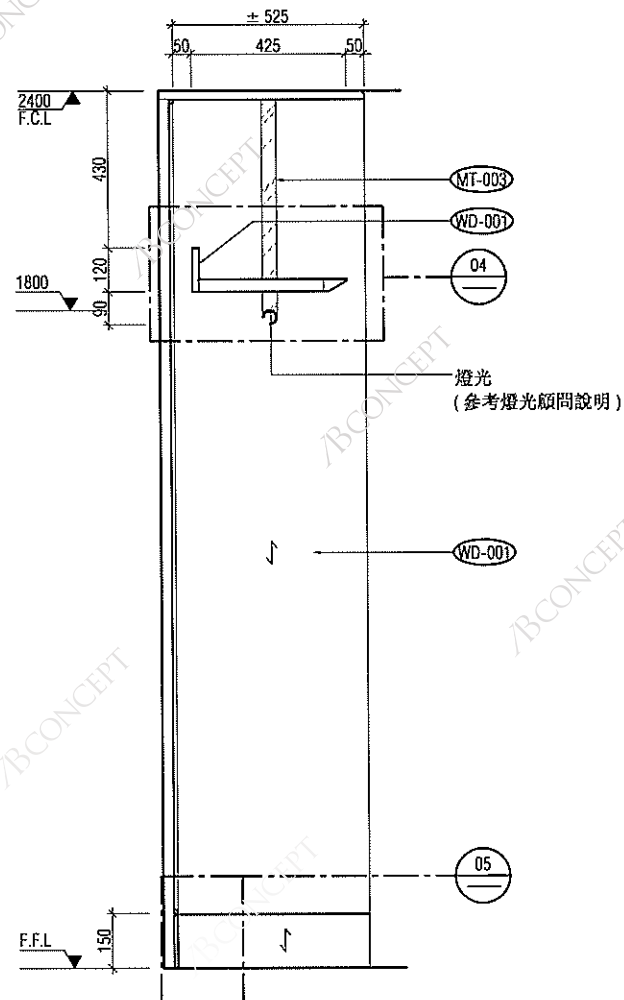

03 剖面圖
规模-1:10

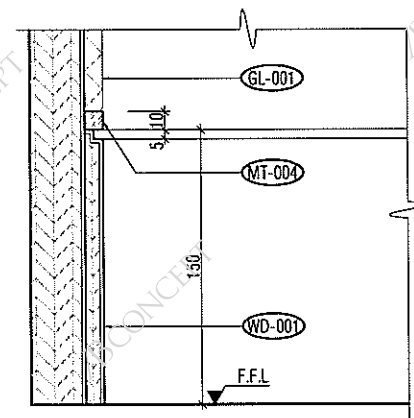

05 大樣圖
规模-1:2

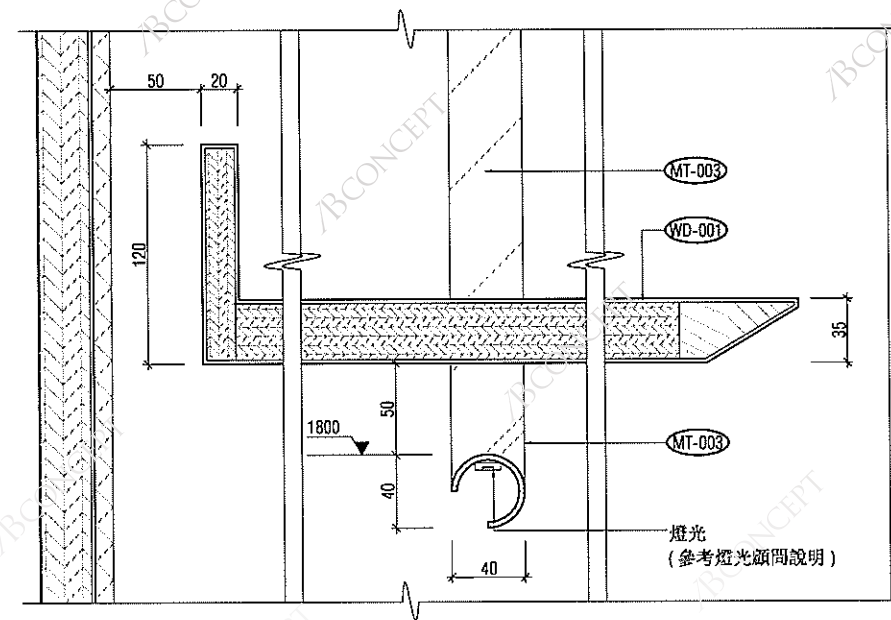

04 大樣圖
规模-1:2

NOTE:
1. ALL DIMENSIONS ARE TO BE VERIFIED BY THE CONTRACTOR BEFORE PROCEEDING WITH CONSTRUCTION.
2. ALL DIMENSIONS ARE TO BE VERIFIED BY THE CONTRACTOR BEFORE PROCEEDING WITH CONSTRUCTION.
3. ALL DIMENSIONS ARE TO BE VERIFIED BY THE CONTRACTOR BEFORE PROCEEDING WITH CONSTRUCTION.
4. ALL DIMENSIONS ARE TO BE VERIFIED BY THE CONTRACTOR BEFORE PROCEEDING WITH CONSTRUCTION.
5. ALL DIMENSIONS ARE TO BE VERIFIED BY THE CONTRACTOR BEFORE PROCEEDING WITH CONSTRUCTION.
6. ALL DIMENSIONS ARE TO BE VERIFIED BY THE CONTRACTOR BEFORE PROCEEDING WITH CONSTRUCTION.
7. ALL DIMENSIONS ARE TO BE VERIFIED BY THE CONTRACTOR BEFORE PROCEEDING WITH CONSTRUCTION.
8. ALL DIMENSIONS ARE TO BE VERIFIED BY THE CONTRACTOR BEFORE PROCEEDING WITH CONSTRUCTION.
9. ALL DIMENSIONS ARE TO BE VERIFIED BY THE CONTRACTOR BEFORE PROCEEDING WITH CONSTRUCTION.
10. ALL DIMENSIONS ARE TO BE VERIFIED BY THE CONTRACTOR BEFORE PROCEEDING WITH CONSTRUCTION.

REVISION NO.	DATE
1	18 DEC 2013
2	
3	
4	
5	
6	
7	
8	
9	
10	

△ 招標階段發送
註釋:
-有關所有機電、燈光、隔音、幕音、消防、廚房、結構、保安、升降機、建築、外牆及屋頂設計, 請參考有關圖則及專家提供之詳圖及資料
-施工單位
-施工單位必須提交施工圖及樓板予設計師確認方可施工

PROJECT MANAGER

M&E CONSULTANT

ARCHITECTURAL CONSULTANT



DESIGNER
ABC CONCEPT
All Contract Limited
1871 United Centre, 1871 United Centre, 1871 United Centre, 1871 United Centre, 1871 United Centre
Tel: +852 2522 0000 Fax: +852 2522 0000

DRAWING TITLE:
木器大樣圖

PROJECT NAME:
中國西安
賽高城市廣場洲際酒店



PROJECT NO.: ABC-600
CHECKED BY: ABC
DATE: 17-DEC-2013
SCALE: A1 = AS SHOWN

DWG NO.: DM-001

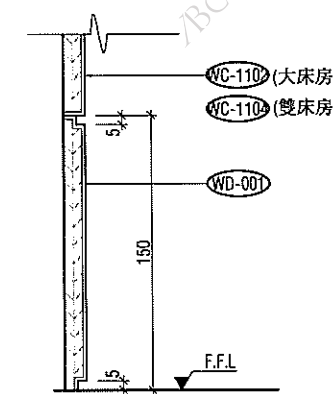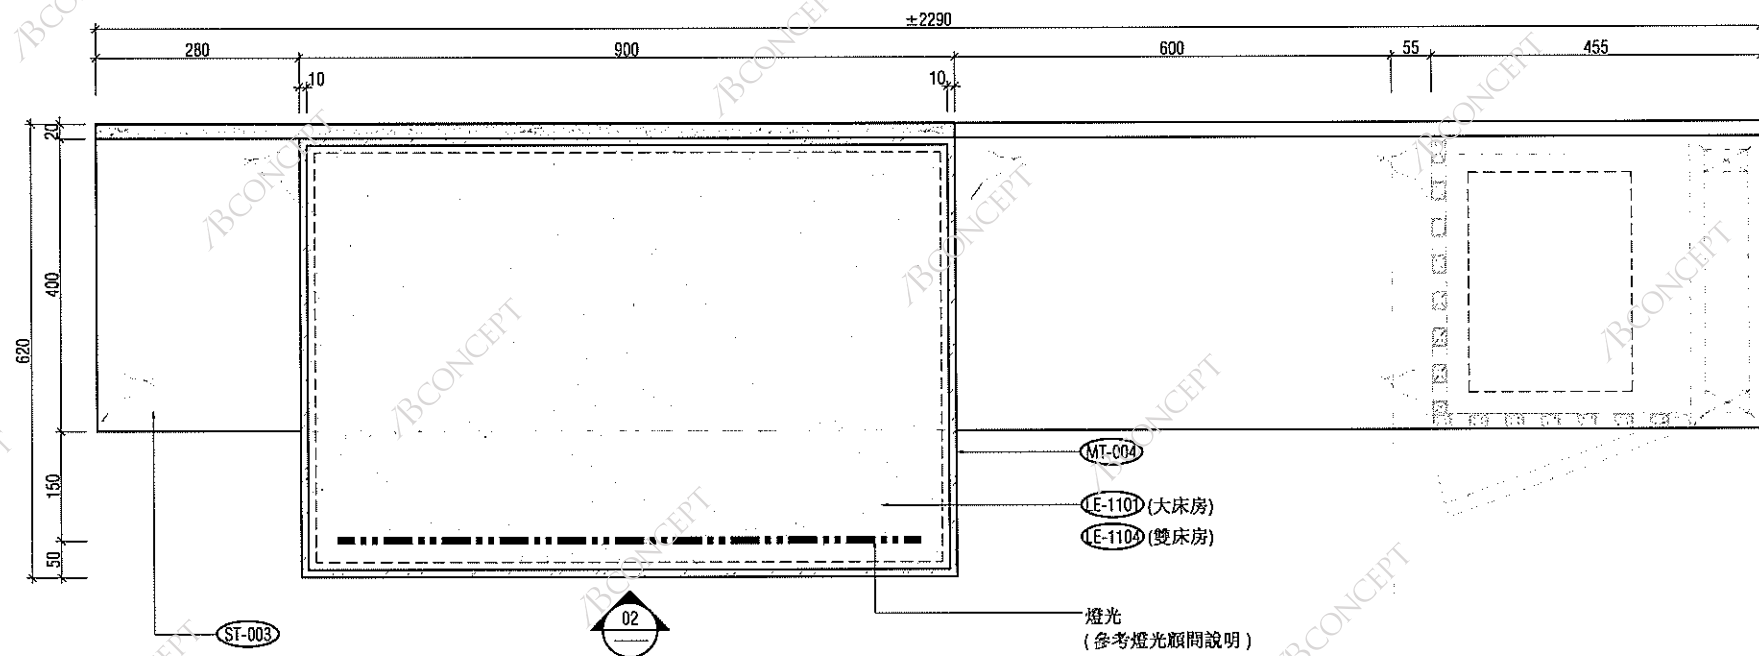

01 平面圖
规模-1:5

04 剖面圖
规模-1:2

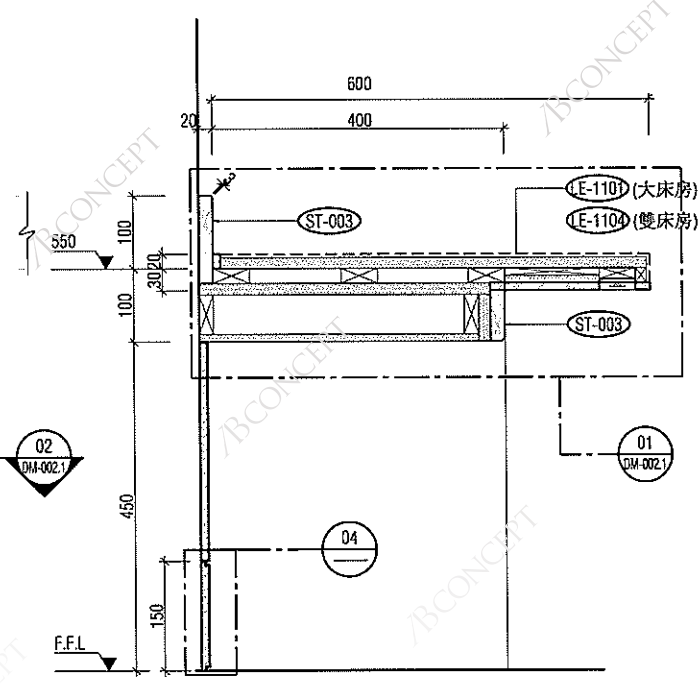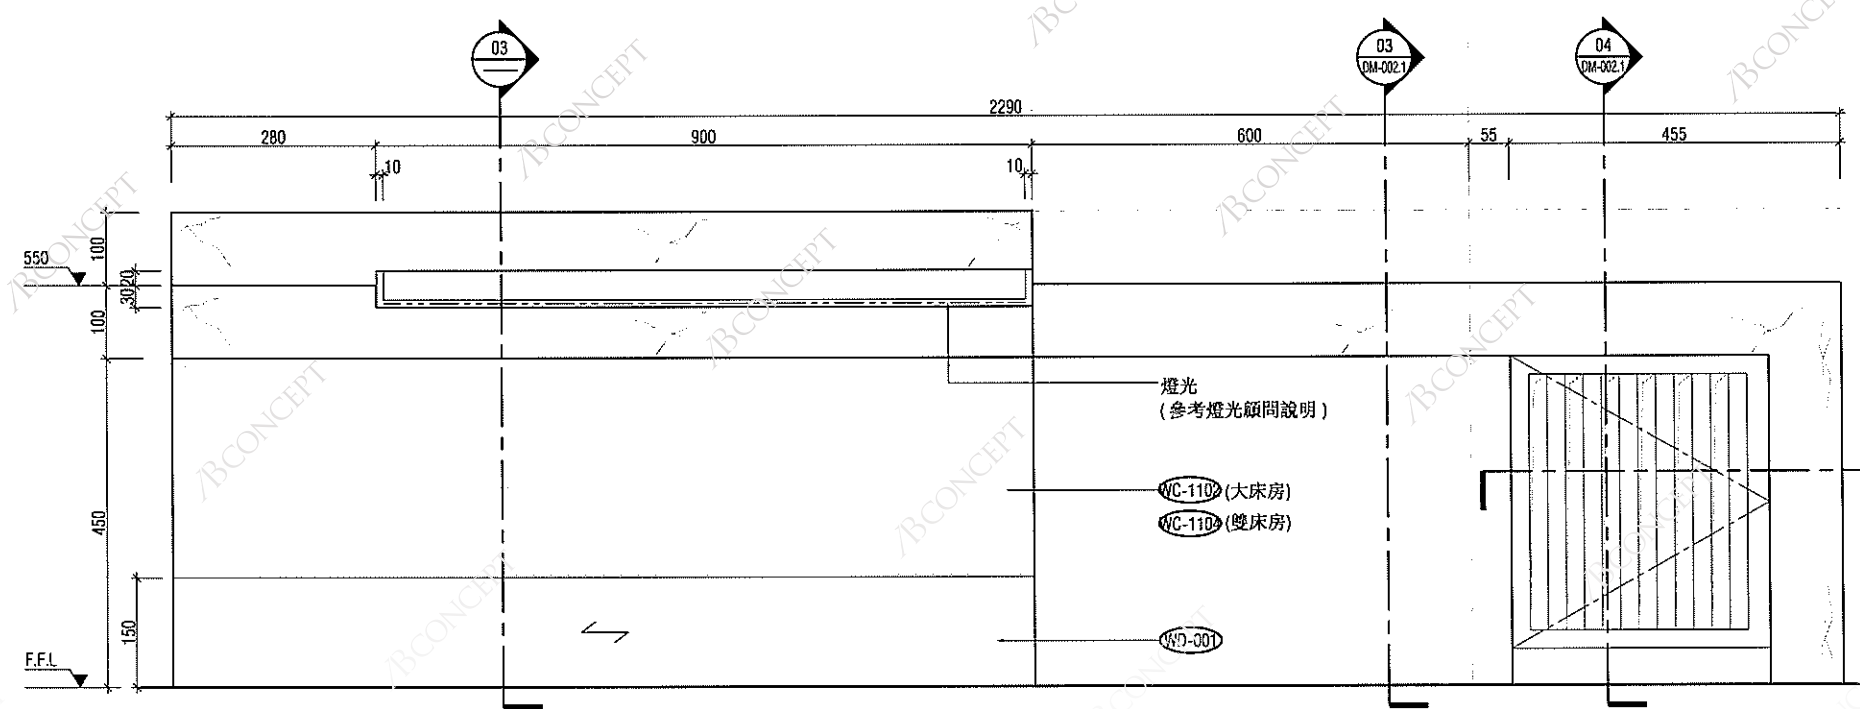

02 立面圖
规模-1:5

03 剖面圖
规模-1:5

NOTE:
1. 20 METERS OR MORE
2. ALL DIMENSIONS SHALL BE VERIFIED ON SITE BY CONTRACTOR BEFORE PROCEEDING WITH CONSTRUCTION
3. LOCATING DIMENSIONS AND DISTANCES TO THE FOLLOWING THE CONTRACT DOCUMENTS
4. CONTRACTOR SHALL BE RESPONSIBLE FOR THE ACCURACY OF THE DIMENSIONS AND DISTANCES TO THE FOLLOWING THE CONTRACT DOCUMENTS
5. CONTRACTOR SHALL BE RESPONSIBLE FOR THE ACCURACY OF THE DIMENSIONS AND DISTANCES TO THE FOLLOWING THE CONTRACT DOCUMENTS
6. CONTRACTOR SHALL BE RESPONSIBLE FOR THE ACCURACY OF THE DIMENSIONS AND DISTANCES TO THE FOLLOWING THE CONTRACT DOCUMENTS

REVISIONS NO.	DATE
1	18 DEC 2013

△ 招標階段發送

註釋:
-有關所有機電、燈光、隔音、影音、消防、廚房、結構、保安、升降機、建築、外牆及牆面設計, 請參考有關顧問及專家提供之詳圖及資料
-施工單位
-施工單位必須提交施工圖及樣板予設計師確認方可施工

PROJECT MANAGER: ☐

M&E CONSULTANT: ☐

ARCHITECTURAL CONSULTANT: ☐

DESIGNER: **BCONCEPT**

ALL CONCEPTS
100% Design, Drawing, Construction, etc. etc.
中國西安賽高城市廣場洲際酒店
100% Design, Drawing, Construction, etc. etc.
Tel: +86 22 2222 2222

DRAWING TITLE:
木器大樣圖

PROJECT NAME:
中國西安
賽高城市廣場洲際酒店

PROJECT NO.:
ABC-600

 
 
CHECKED BY: ABC
DATE: 17-DEC-2013
SCALE: 1/50
DRAWN BY: A.N.
SCALE: A1=AS SHOWN

DWG. NO.:
DM-002

[illegible]



—施工單位必須提交施工圖及模板予設計師
—確認方可施工

DM-002.1



- 施工單位必須提交施工圖及標板予設計師
確認方可施工

  DM-003.1

[illegible]

△ 招標階段發送	18 DEC 2013
註釋: 有關所有機電、燈光、隔音、影音、消防、廚房、結構、保安、升降機、建築、外牆及雕塑設計，請參考有關顧問及專家提供之詳圖及資料	
-施工單位 施工單位必須提交施工圖及標明子設計師協方可施工	


DESIGNER:
AB CONCEPT
AB Concept Limited
1801 Lighthouse Circle, Causeway Bay, Hong Kong
夢見無限樓海城中心 1801室
tel. +852 25252419

PROJECT NAME:
中國西安
賽高城市廣場洲際酒店

PROJECT NO: 工程號碼		ABC - 500	
CHECKED BY: 查核		ABC	DRAWN BY: 繪製
DATE 日期		17-DEC-2013	SCALE 比例
DWG NO: 圖號		A1=AS SHOW	

DM-004.1

 △




△ 招標階段發送	18 DEC 2013
<p>註釋:</p> <ul style="list-style-type: none"> -有關所有機電、燈光、隔音、影音、消防、廚房、結構、保安、升降機、建築、外牆及牆壁設計，請參考有關顧問及專家提供之詳圖及資料 -施工單位 -施工單位必須提交施工圖及樣板予設計師預覽方可施工 	


ARCHITECTURAL CONSULTANT:

DRAWING TITLE:
總 括
木器大樣圖

PROJECT NAME:
工程名稱
中國西安
賽高城市廣場洲際酒店

PROJECT NO (工程号) ABC-600	
CHECKED BY: (审核) ABC	DRAWN BY: (制图) S.Y.
DATE (日期) 17-DEC-2013	SCALE (比例) A1=AS SHOWN

 DWG NO:
K M DM-005 




△ 招標階段發送 18 DEC 2013


註釋:

- 有關所有機電、燈光、隔音、影音、消防、廚房、結構、保安、升降機、建築、外牆及牆面設計，請參考有關顧問及專家提供之詳圖及資料
- 施工單位
- 施工單位必須提交施工圖及樓板予設計師核對方可施工


PROJECT NO 工程號		ABC - 600	
DESIGNED BY 設計師		DRAWN BY 繪圖員	
ABC		S.Y.	
DATE 日期		SCALE 比例	
17-DEC-2013		A1 = AS SHOWN	
DWG NO: 圖號		DM-005.1	

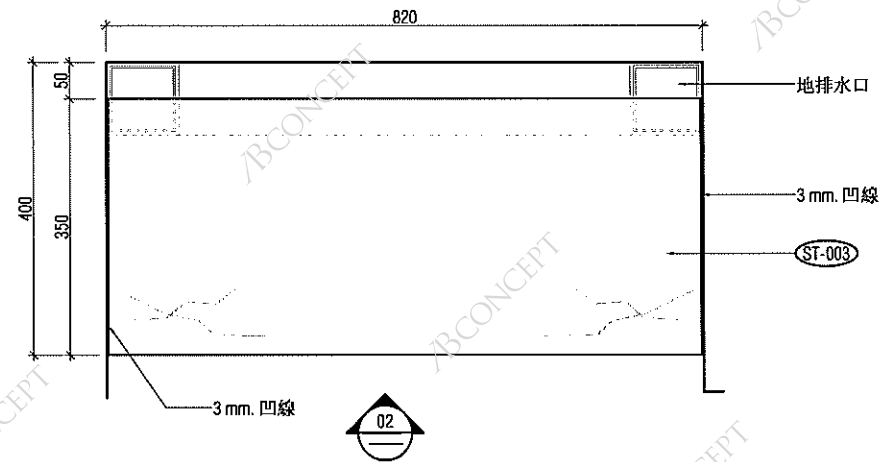


01 平面圖
规模-1:5

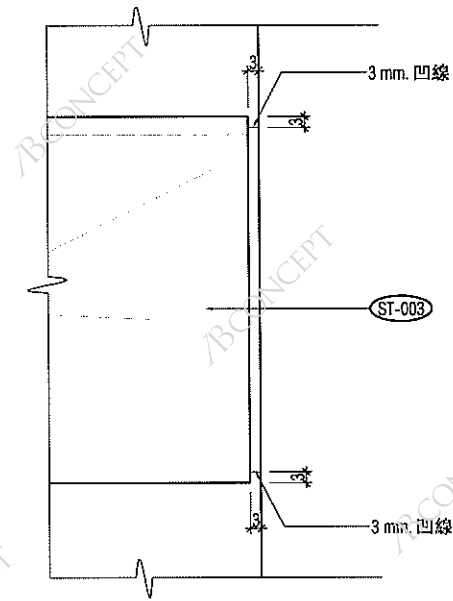

04 大樣圖
规模-1:1

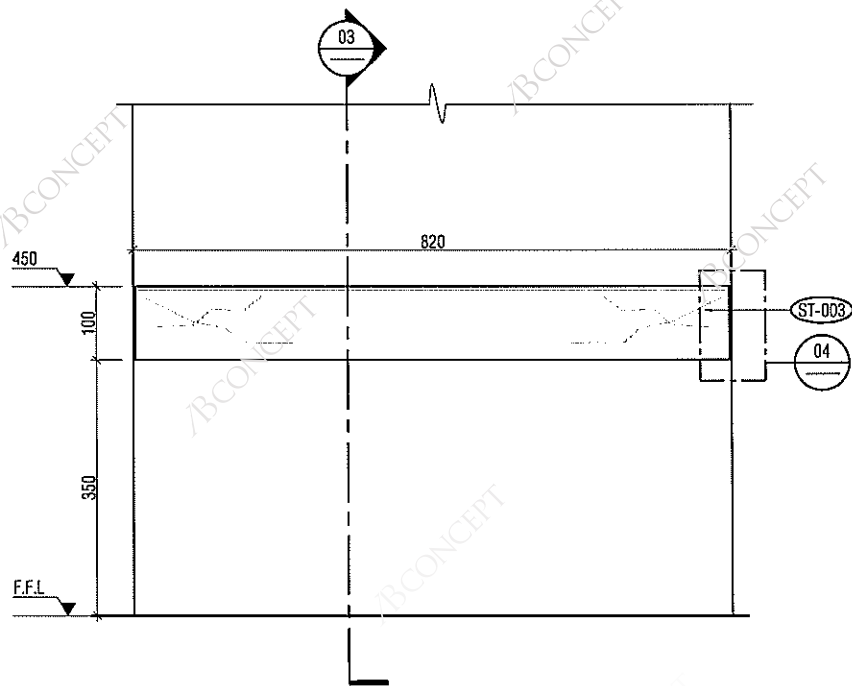

02 立面圖
规模-1:5

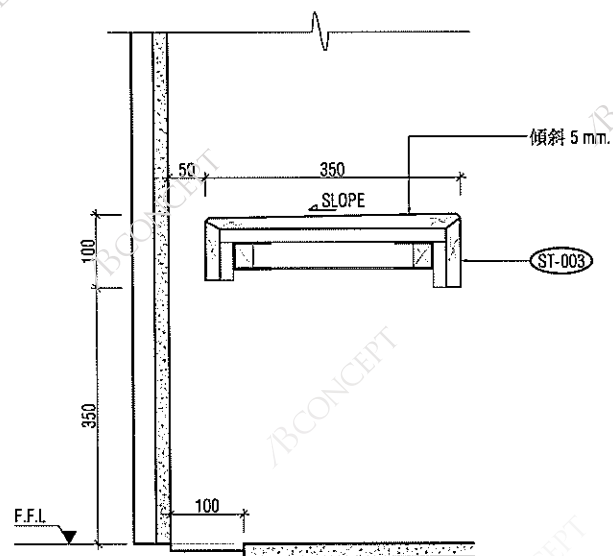

03 剖面圖
规模-1:5

NOTE
1. ALL DIMENSIONS ARE TO BE SHOWN ON SITE BY DIMENSION LINE.
2. ALL DIMENSIONS ARE TO BE SHOWN ON SITE BY DIMENSION LINE.
3. ALL DIMENSIONS ARE TO BE SHOWN ON SITE BY DIMENSION LINE.
4. ALL DIMENSIONS ARE TO BE SHOWN ON SITE BY DIMENSION LINE.
5. ALL DIMENSIONS ARE TO BE SHOWN ON SITE BY DIMENSION LINE.
6. ALL DIMENSIONS ARE TO BE SHOWN ON SITE BY DIMENSION LINE.
7. ALL DIMENSIONS ARE TO BE SHOWN ON SITE BY DIMENSION LINE.
8. ALL DIMENSIONS ARE TO BE SHOWN ON SITE BY DIMENSION LINE.
9. ALL DIMENSIONS ARE TO BE SHOWN ON SITE BY DIMENSION LINE.
10. ALL DIMENSIONS ARE TO BE SHOWN ON SITE BY DIMENSION LINE.

REVISIONS	DATE
1	18 DEC 2013
2	
3	
4	
5	
6	
7	
8	
9	
10	

招標階段發送
註釋:
-有關所有機電、燈光、隔音、影音、消防、廚房、結構、保安、升降機、建築、外牆及牆面設計, 請參考有關圖則及專家提供之詳圖及資料
-施工單位
-施工單位必須提交施工圖及樣板予設計師預覽方可施工

PROJECT MANAGER

MSE CONSULTANT

ARCHITECTURAL CONSULTANT

DESIGNER:
BCONCEPT
44 Onsen Street, 4th Floor, Singapore 119 119
Tel: +65 6339 8888 Fax: +65 6339 8889

DRAWING TITLE:
木器大樣圖

PROJECT NAME:
中國西安

賽高城市廣場洲際酒店

PROJECT NO:
ABC-500

CHECKED BY:
ABC

DRAWN BY:
U.A.

DATE:
17-DEC-2013

SCALE:
As SHOWN

DWG NO:
DM-006

01 平面圖

規模-1:10

02 立面圖 规模-1:10

03 剖面圖 規模-1:5

05 大樣圖 规模-1:1

04 大樣圖 规模-1:1

- [illegible]

[illegible]

△ 招標階段發送	18 DEC 2013
<p>註釋:</p> <ul style="list-style-type: none"> 有關所有機電、燈光、隔音、影音、消防、廚房、結構、保安、升降機、建築、外牆及牆體設計，請參考有關顧問及專家提供之詳圖及資料 施工單位 施工單位必須提交施工圖及樓板予設計師覆核方可施工 	

PROJECT MANAGER ☐

M&E CONSULTANT ☐

ARCHITECTURAL CONSULTANT: ☐

DESIGNER:

B CONCEPT

AB Concept Limited
1807 Union Square, Gateway Bldg, Hong Kong
香港新加坡匯豐中心1807室
tel: www.abconcept.net tel: +852-25224545

DRAWING TITLE:


此 名

木器大樣圖

PROJECT NAME:
Y. 27 4 0 0
中國西安
賽高城市廣場洲際酒店

PROJECT NO T 号 图 号		ABC - 600	
CHECKED BY 姓 名		DRAWN BY 姓 名	
ABC		A.N.	
DATE 年 月 日		SCALE 比 例	
16-DEC-2013		A1 = AS SHOWN	



 
DM-007 



- [illegible]

- 施工單位
- 施工單位必須提交施工圖及模板預設計師
簽署方可施工

   DM-008 A


[illegible]

 
 
 
一、施工單位必須提交施工圖及樑板予設計師
確認方可施工

ARCHITECTURAL CONSULTANT. []

木器大様圖


中國西安
賽高城市廣場洲際酒店


DIV-009 




註釋:

- 有關所有機電、燈光、隔音、影音、消防、廚房、結構、保安、升降機、建築、外牆及雕塑設計，請參考有關顧問及專家提供之詳圖及資料
- 施工單位
- 施工單位必須提交施工圖及樣板予設計師確認方可施工

DM-010 

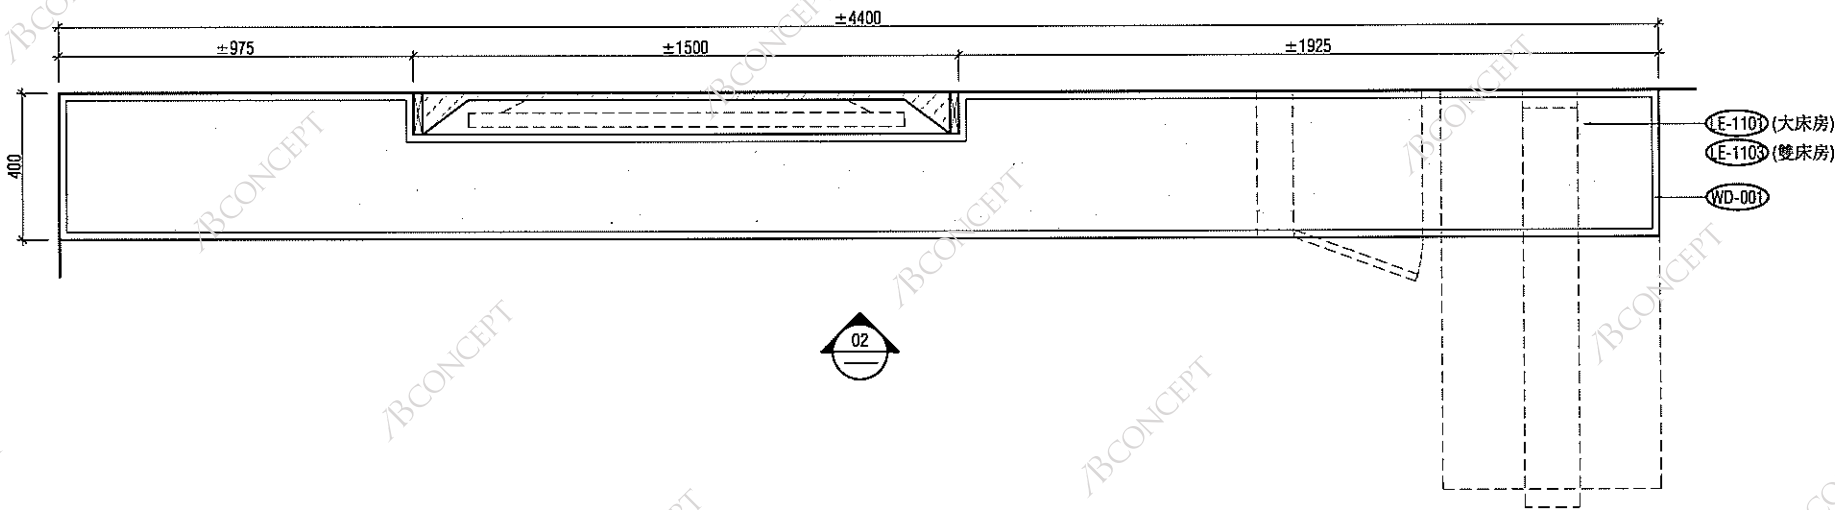

01 平面圖
规模- 1:10

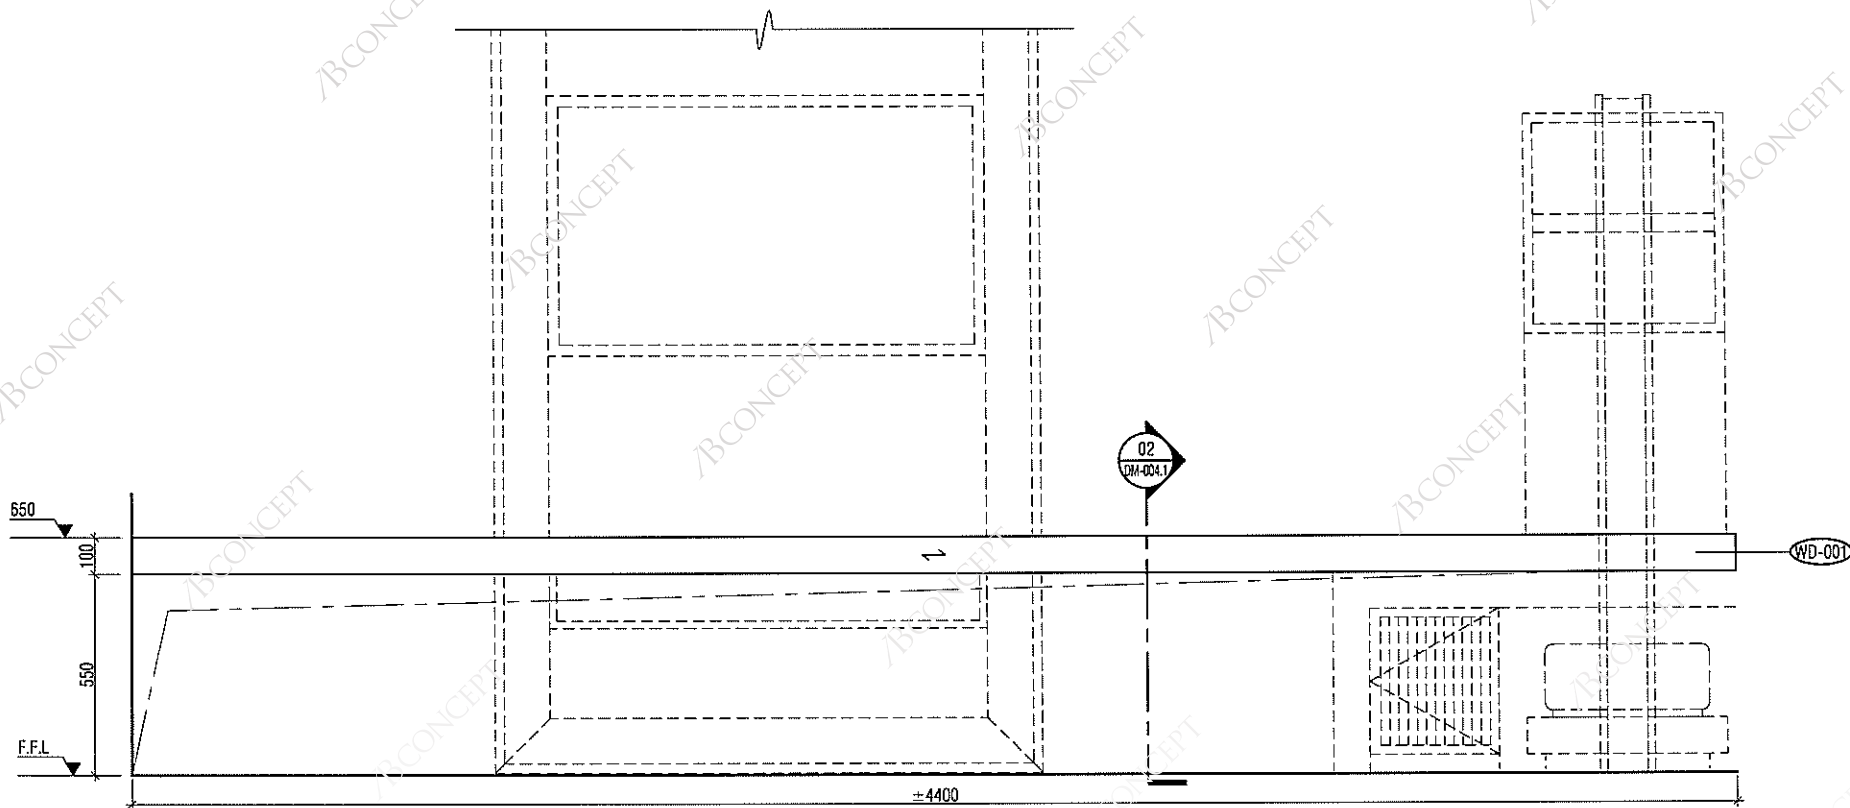

02 立面圖
规模- 1:10

REVISIONS	
NO.	DATE
1	18 DEC 2013
2	
3	
4	
100	

REVISIONS	
NO.	DATE
1	18 DEC 2013
2	
3	
4	
100	

△ 招標階段發送 18 DEC 2013
註釋:
-有關所有機電、燈光、隔音、影音、消防、廚房、結構、保安、升降機、建築、外牆及牆面設計, 請參考有關圖則及專家提供之詳圖及資料
-施工單位
-施工單位必須提交施工圖及樣板予設計師
-應預方可施工

PROJECT MANAGER: ☐

MSE CONSULTANT: ☐


ARCHITECTURAL CONSULTANT: ☐

DESIGNER:
/BCONCEPT
All Concept Limited
1111 Canton Road, Suite 1111, Hong Kong
電話: 2828 2828
FAX: 2828 2828
DRAWING TITLE:
傢俬


木器大樣圖

PROJECT NAME:
中國西安
賽高城市廣場洲際酒店


PROJECT NO:
ABC-600
CHECKED BY:
ABC
DRAWN BY:
K.K.
DATE:
17-DEC-2013
SCALE:
A1=AS SHOWN
DWG. NO.:
DM-011

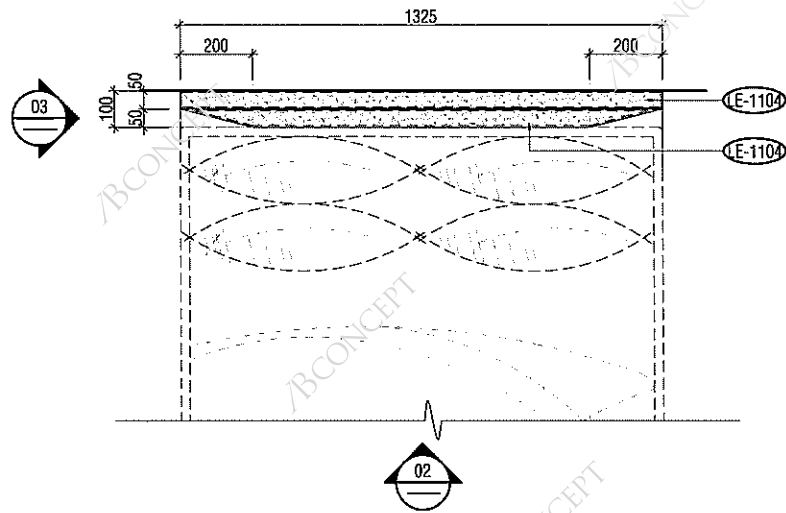


01 平面圖
规模-1:10

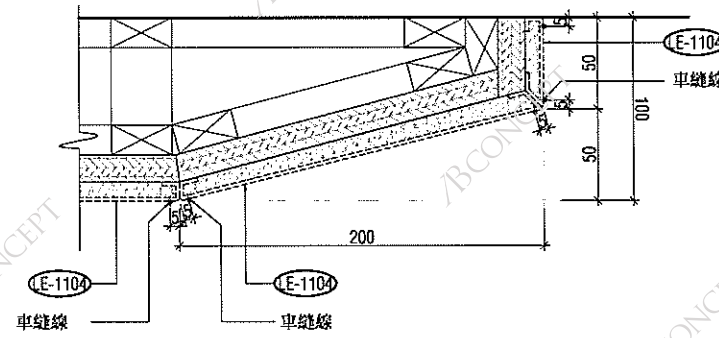


07 大樣圖
规模-1:2

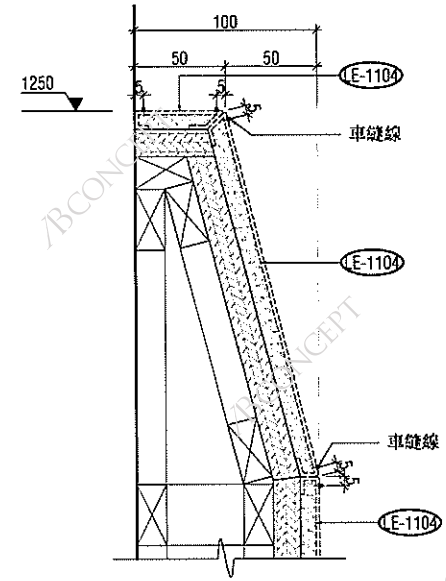


06 大樣圖
规模-1:2

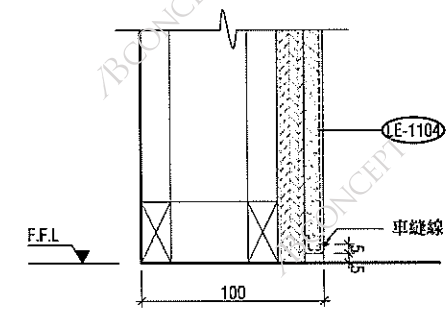


05 大樣圖
规模-1:2

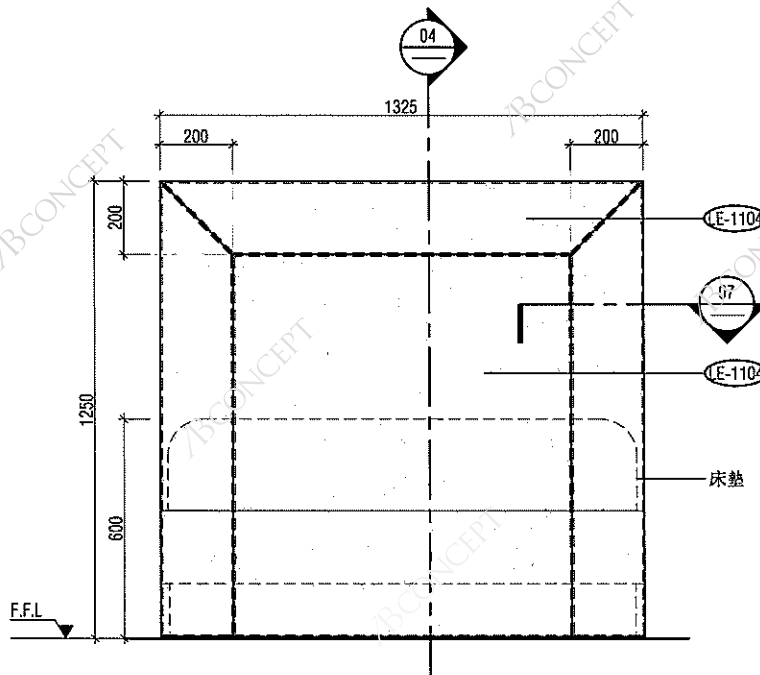

02 立面圖
规模-1:10

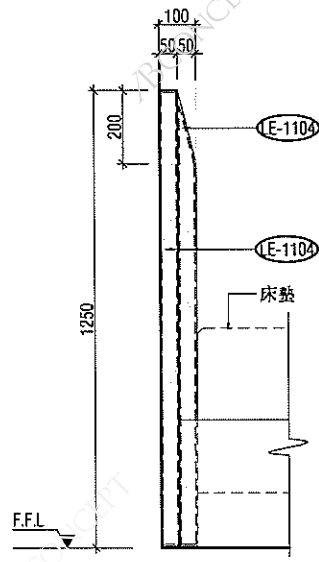

03 立面圖
规模-1:10

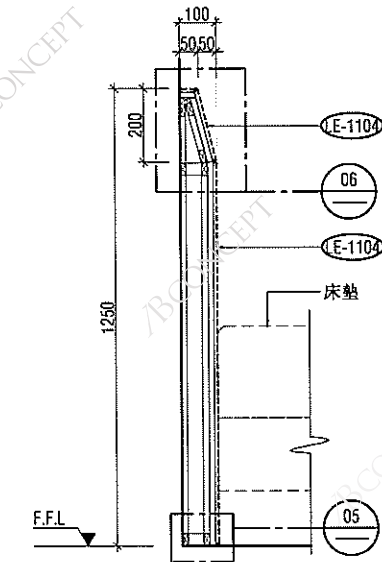

04 剖面圖
规模-1:10

NOTE
1. ALL DIMENSIONS MUST BE CHECKED ON SITE BY CONTRACTOR BEFORE PROCEEDING WITH CONSTRUCTION.
2. ALL DIMENSIONS MUST BE CHECKED ON SITE BY CONTRACTOR BEFORE PROCEEDING WITH CONSTRUCTION.
3. ALL DIMENSIONS MUST BE CHECKED ON SITE BY CONTRACTOR BEFORE PROCEEDING WITH CONSTRUCTION.
4. ALL DIMENSIONS MUST BE CHECKED ON SITE BY CONTRACTOR BEFORE PROCEEDING WITH CONSTRUCTION.
5. ALL DIMENSIONS MUST BE CHECKED ON SITE BY CONTRACTOR BEFORE PROCEEDING WITH CONSTRUCTION.
6. ALL DIMENSIONS MUST BE CHECKED ON SITE BY CONTRACTOR BEFORE PROCEEDING WITH CONSTRUCTION.
7. ALL DIMENSIONS MUST BE CHECKED ON SITE BY CONTRACTOR BEFORE PROCEEDING WITH CONSTRUCTION.
8. ALL DIMENSIONS MUST BE CHECKED ON SITE BY CONTRACTOR BEFORE PROCEEDING WITH CONSTRUCTION.
9. ALL DIMENSIONS MUST BE CHECKED ON SITE BY CONTRACTOR BEFORE PROCEEDING WITH CONSTRUCTION.
10. ALL DIMENSIONS MUST BE CHECKED ON SITE BY CONTRACTOR BEFORE PROCEEDING WITH CONSTRUCTION.

REVISIONS NO.	DATE	USE
1	18 DEC 2013	招標階段發送
2		
3		
4		
5		
6		
7		
8		
9		
10		

註釋:
-有關所有機電、燈光、隔音、影音、消防、廚房、結構、保安、升降機、建築、外牆及牆壁設計, 請參考有關顧問及專家提供之詳圖及資料。
-施工單位
-施工單位必須提交施工圖及樣板予設計師, 經認可方可施工。

PROJECT MANAGER: ☐

MSE CONSULTANT: ☐

 
ARCHITECTURAL CONSULTANT: ☐

DESIGNER:
BCONCEPT
All Rights Reserved
1001 Century Square, 21st Floor, Hong Kong
電話: 2828 2828
www.bconcept.com.hk


DRAWING TITLE:
木器大樣圖

PROJECT NAME:
中國西安
賽高城市廣場洲際酒店


PROJECT NO: ABC-600
CHECKED BY: ABC
DATE: 17-DEC-2013
DRAWN BY: J.L.
SCALE: A1=AS SHOWN
DWG NO: DM-012




DM-013

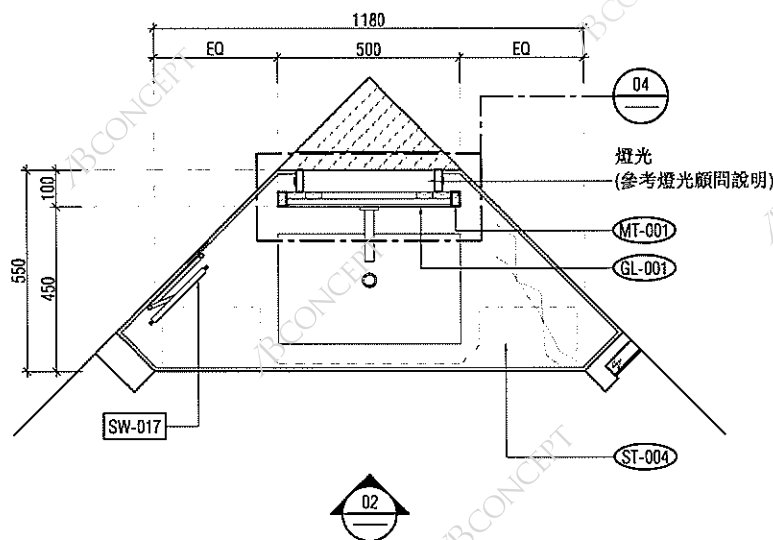


01 平面圖
规模- 1:10

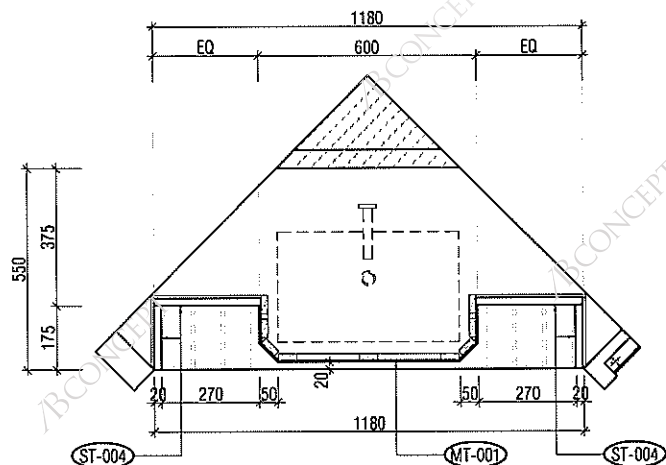


06 剖面圖
规模- 1:10

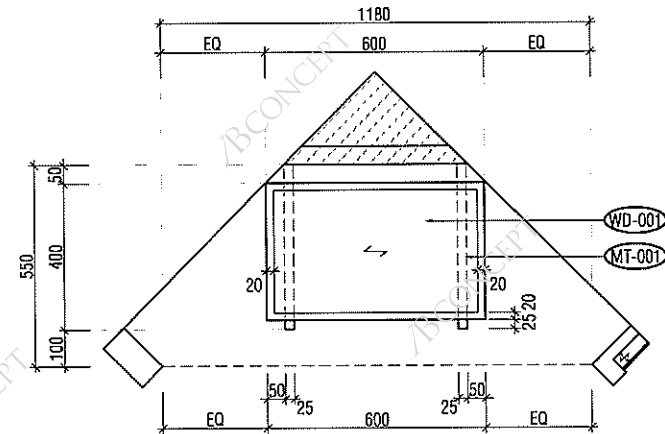


05 剖面圖
规模- 1:10

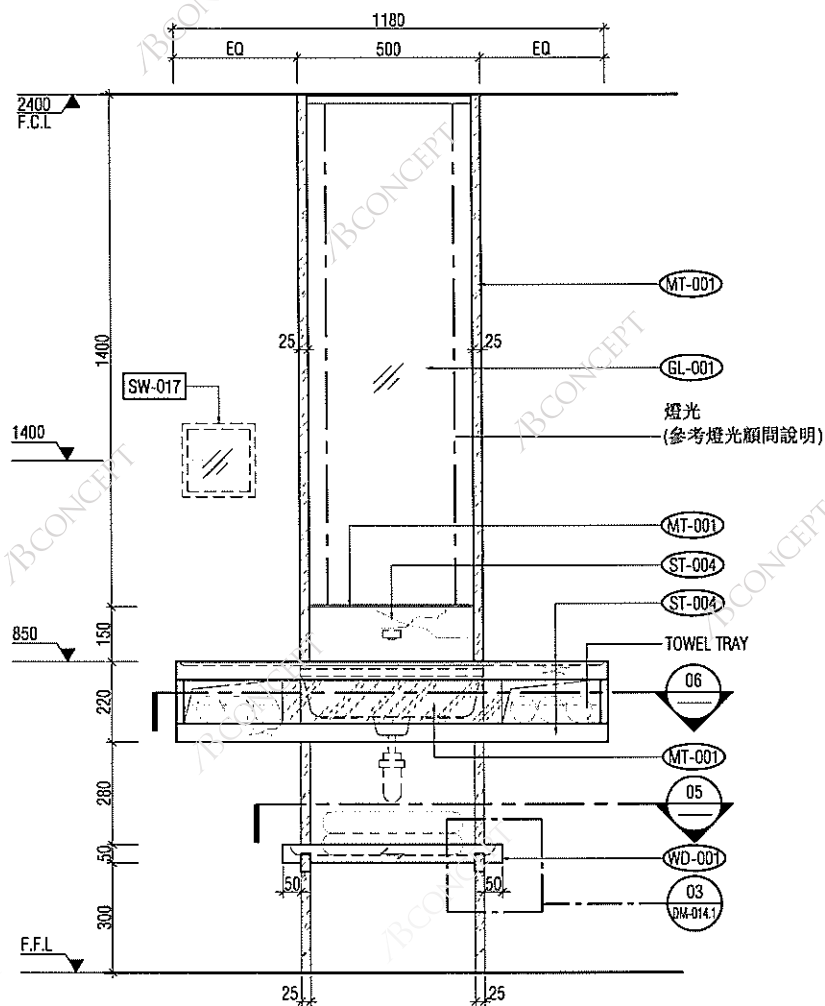

02 立面圖
规模- 1:10

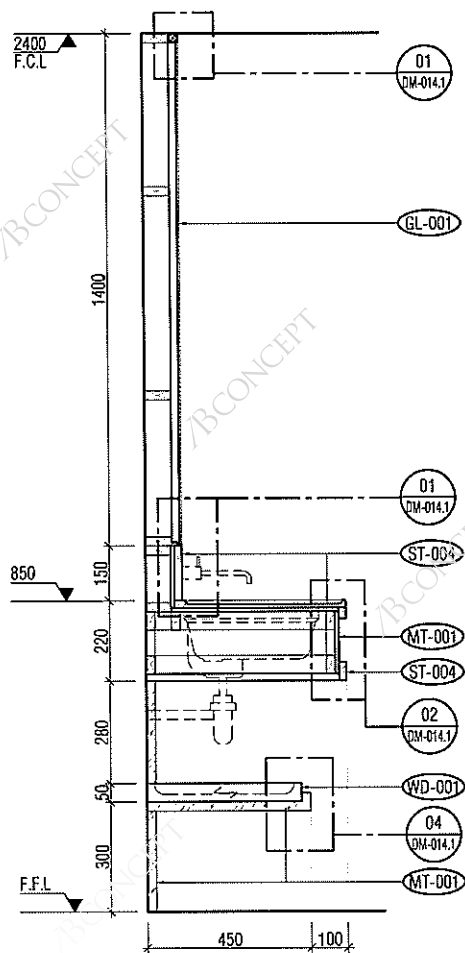

03 剖面圖
规模- 1:10

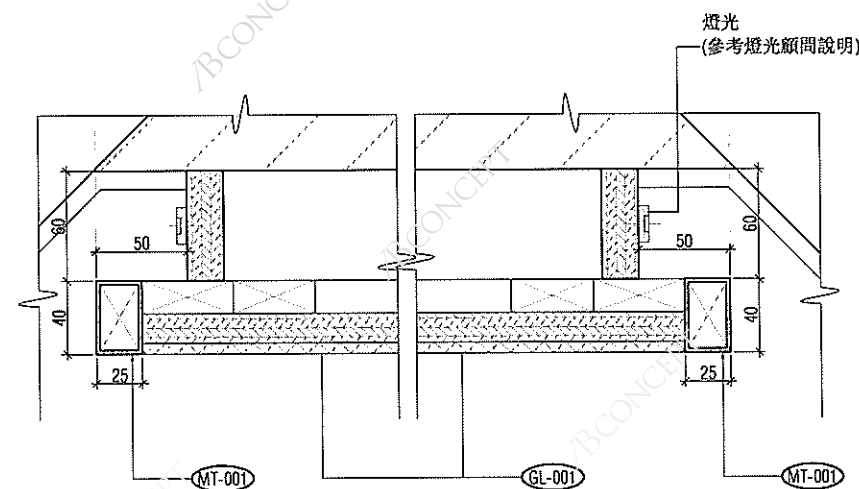

04 大樣圖
规模- 1:2

NOTES:

- DO NOT SCALE DRAWINGS
- ALL DIMENSIONS ARE TO FACE UNLESS OTHERWISE SPECIFIED
- CONSTRUCTION TO BE IN ACCORDANCE WITH THE LATEST EDITIONS OF THE CHINESE NATIONAL STANDARDS (GB) AND THE CHINESE NATIONAL STANDARDS FOR BUILDING MATERIALS (GB/T)
- CONSTRUCTION TO BE IN ACCORDANCE WITH THE LATEST EDITIONS OF THE CHINESE NATIONAL STANDARDS (GB) AND THE CHINESE NATIONAL STANDARDS FOR BUILDING MATERIALS (GB/T)
- CONSTRUCTION TO BE IN ACCORDANCE WITH THE LATEST EDITIONS OF THE CHINESE NATIONAL STANDARDS (GB) AND THE CHINESE NATIONAL STANDARDS FOR BUILDING MATERIALS (GB/T)

REVISIONS:

NO.	DATE	DESCRIPTION
1	18 DEC 2013	招標所發發送

18 DEC 2013

註釋:

- 有關所有機電、燈光、隔音、影音、消防、廚房、裝修、保安、升降機、建築、外牆及屋頂設計，請參考有關圖則及專家提供之詳圖及資料
- 施工單位
- 施工單位必須與建築師及樣板設計師聯絡方可施工

PROJECT MANAGER: ☐

MSE CONSULTANT: ☐

ARCHITECTURAL CONSULTANT: ☐

DESIGNER: **BCONCEPT**

PROJECT NAME: 中國西安賽高城市廣場洲際酒店

PROJECT NO: ABC-600

CHECKED BY: ABC

DATE: 17-DEC-2013

DRAWN BY: U.A.

SCALE: A1 = AS SHOWN

DWG NO: DM-014

[illegible]

- 施工單位
- 施工單位必須提交施工圖及樣板予設計師
確認可方可施工

ARCHITECTURAL CONSULTANT:

DRAWING TITLE :
總 圖
木器大樣圖

DM 0141

DM-014.1 \angle

[illegible]

ARCHITECTURAL CONSULTANT

木器大様圖

中國西安
賽高城市廣場洲際酒店

PROJECT NO. ABC-600

DATE	SCALE
------	-------

17-DEC-2013 A1 =AS SHO

ENG NO:

DM-015 A
